

SITE DEVELOPMENT PLANS
FOR
PROJECT JOY SALES CENTER
CANTON, MISSISSIPPI
MAY 2023

OWNER INFORMATION

CLARK BEVERAGE GROUP, INC.
300 OAKLAND FLATROCK ROAD
OAKLAND, KY 42159
TEL:
CONTACT: LUCAS MOHON

DESIGN BUILDER

DESIGN GROUP FACILITY SOLUTIONS, INC.
5 CHENELL DRIVE BOX 3
CONCORD, NH 03301
CONTACT: WILLIAM CROWE
TEL: (817) 350-4181

ENGINEER

CIVIL-LINK
CANTON, MS OFFICE
276 NISSAN PARKWAY,
BUILDING B, SUITE 300
CANTON, MS 39046
OFFICE: 601-259-3662
CWAGES@CIVIL-LINK.COM

SOUTHAVEN, MS OFFICE
5779 GETWELL RD,
SOUTHAVEN, MS 38672
OFFICE: 662-510-7763
FAX: 662-510-2197
CONTACT: CHAD WAGES
CWAGES@CIVIL-LINK.COM

UTILITY PROVIDERS

WATER, SEWER & GAS
CANTON MUNICIPAL UTILITIES
LOGAN HALE
601-859-2474
l.hale@cmu.com

ELECTRICITY
ENTERGY
MICHAEL FERRELL
mferre2@entergy.com

TELEPHONE & FIBER
UNITY FIBER
BRENT SONES
601-503-4529
brent.sones@unity.com

SURVEYOR


CIVIL-LINK
CANTON, MS OFFICE
276 NISSAN PARKWAY,
BUILDING B, SUITE 300
CANTON, MS 39046
OFFICE: 601-259-3662

SOUTHAVEN, MS OFFICE
5779 GETWELL RD,
SOUTHAVEN, MS 38672
OFFICE: 662-510-7763
FAX: 662-510-2197
CONTACT: CHAD WAGES
CWAGES@CIVIL-LINK.COM

APPROVAL AGENCIES

LANDSCAPE
ARCHITECT

WAS DESIGN
1510 N. State Street, #300
Jackson, MS 39202
TEL: 601.790.0781
CONTACT: JARED ACY

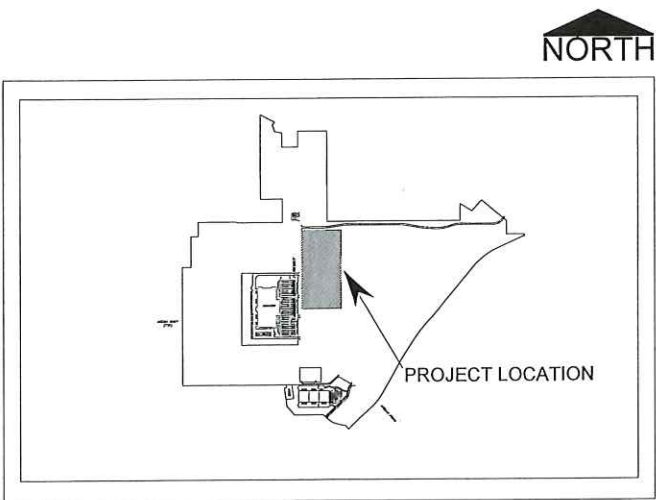

VICINITY MAP
SCALE: 1"=2000'

INDEX:

SHEET NO.	DESCRIPTION
C0.0	COVER PAGE
C0.1	GENERAL NOTES
C0.2	SUMMARY OF QUANTITIES
C1.0	EXISTING CONDITIONS / DEMO PLAN
C2.0	OVERALL SITE PLAN LAYOUT
C2.1	SITE PLAN GRID LAYOUT
C2.2	SITE PLAN LAYOUT
C2.3	SITE PLAN LAYOUT
C2.4	SITE PLAN LAYOUT
C2.5	SITE PLAN LAYOUT
C3.0	OVERALL GRADING & DRAINAGE PLAN LAYOUT
C3.1	GRADING & DRAINAGE PLAN GRID LAYOUT
C3.2	GRADING & DRAINAGE PLAN LAYOUT
C3.3	GRADING & DRAINAGE PLAN LAYOUT
C3.4	GRADING & DRAINAGE PLAN LAYOUT
C3.5	GRADING & DRAINAGE PLAN LAYOUT
C3.6	GRADING & DRAINAGE PLAN BORING LOGS
C3.7	GRADING & DRAINAGE PLAN LAYOUT
C3.8	GRADING & DRAINAGE PLAN & PROFILES
C3.9	CROSS SECTION OVERALL LAYOUT
C3.10	CROSS SECTION PLAN & PROFILE
C4.0	OVERALL UTILITY PLAN LAYOUT
C4.1	UTILITY PLAN GRID LAYOUT
C4.2	UTILITY PLAN LAYOUT
C4.3	UTILITY PLAN LAYOUT
C4.4	UTILITY PLAN LAYOUT
C4.5	UTILITY PLAN LAYOUT
C4.6	UTILITY PLAN LAYOUT
C4.7	UTILITY PLAN LAYOUT
C4.8	UTILITY PLAN & PROFILES
C4.9	LANDSCAPE LAYOUT
C5.0	OVERALL SITE STRIPING & SIGNAGE PLAN LAYOUT
C5.1	SITE STRIPING & SIGNAGE GRID LAYOUT
C5.2	SITE STRIPING & SIGNAGE LAYOUT
C5.3	SITE STRIPING & SIGNAGE LAYOUT
C5.4	SITE STRIPING & SIGNAGE LAYOUT
C5.5	SITE STRIPING & SIGNAGE LAYOUT
C6.0	PAVING LAYOUT
C7.0	EROSION CONTROL SITE PLAN LAYOUT
C8.0	DETAIL SHEET
C8.1	DETAIL SHEET
C8.2	DETAIL SHEET
C8.3	DETAIL SHEET
C8.4	DETAIL SHEET
C8.5	DETAIL SHEET
C8.6	DETAIL SHEET
C8.7	DETAIL SHEET
C8.8	DETAIL SHEET
C8.9	DETAIL SHEET
C8.10	DETAIL SHEET
C8.11	DETAIL SHEET
C8.12	DETAIL SHEET
C8.13	DETAIL SHEET
C8.14	DETAIL SHEET
C8.15	DETAIL SHEET
C8.16	DETAIL SHEET
C8.17	DETAIL SHEET
C8.18	DETAIL SHEET
C8.19	DETAIL SHEET
C8.20	DETAIL SHEET
C8.21	DETAIL SHEET



Design Group



DC ARCHITECTURAL AND ENGINEERING FACILITY SOLUTIONS, PLLC
1075 WINDWARD RIDGE PKWY, STE 100, ALPHARETTA, GA 30005
PHONE: (770) 567-5200 FAX: (770) 567-9221

REVISION	DATE	BY	W/C
0	5/17/23		



CLARK BEVERAGE GROUP, INC.
OAKLAND, KY
PROJECT JOY SALES CENTER
CANTON, MS

DRAWING TITLE
COVER PAGE



PROJECT NO. 2300638
ISSUED: 5-17-2023
SCALE: AS NOTED
DRAWN BY: VLC
DRAWING NO.

C0.0

GENERAL NOTES:

1. PUBLIC UTILITIES
- 1.1. WATER, SEWER & GAS --- CANTON MUNICIPAL UTILITIES --- LOGAN HALE--- 601-859-2474 --- l.hale@cmu.com
- 1.2. ELECTRICITY --- ENTERGY --- MICHAEL FERRELL --- mferre2@entergy.com
- 1.3. TELEPHONE & FIBER --- UNITY FIBER --- BRENT SONES --- 601-503-4529 --- brent.sones@uniti.com
2. IT SHALL BE THE RESPONSIBILITY OF THE CONTRACTOR TO PROTECT EXISTING STRUCTURES SUCH AS PIPES, INLETS, APRONS, BRIDGES, PAVEMENTS, ETC. FROM DAMAGE, WHICH MIGHT OCCUR DURING CONSTRUCTION. EXTREME CARE SHOULD BE EXERCISED IN UNDERCUT AREAS AND THE UNDERCUT DEPTH MAY BE ADJUSTED AT CROSS DRAINS, AS DIRECTED BY THE ENGINEER. THE CONTRACTOR SHALL REPLACE OR REPAIR, AS DIRECTED BY THE ENGINEER, ANY STRUCTURES DAMAGED DURING THE LIFE OF THE CONTRACT. NO PAYMENT WILL BE MADE FOR REPLACEMENT OR REPAIR OF DAMAGED ITEMS.
3. VOIDS CREATED BY THE REMOVAL OF POSTS, CONCRETE ANCHORS, FOOTINGS, ETC. SHALL BE BACK FILLED AND TAMPED IN ACCORDANCE WITH SECTION 203 OF THE MISSISSIPPI DEPARTMENT OF TRANSPORTATION STANDARD SPECIFICATIONS FOR ROAD AND BRIDGE CONSTRUCTION, LATEST EDITION.
4. EXISTING UNDERGROUND UTILITY LINES ARE SHOWN ON THE DRAWINGS BASED UPON THE BEST INFORMATION AVAILABLE TO THE ENGINEER. THE ENGINEER CANNOT AND DOES NOT WARRANT THAT THIS INFORMATION IS COMPLETE OR ACCURATE. THE CONTRACTOR MUST COORDINATE DIRECTLY WITH THE INVOLVED UTILITY OWNERS TO HAVE UNDERGROUND UTILITY LINES FIELD LOCATED IN ADVANCE OF CONSTRUCTION. --- MS ONE CALL 811 OR 800-227-6477
5. CONTRACTOR SHALL EXERCISE EXTREME CAUTION DURING EXCAVATION AND TRENCHING OPERATIONS. IT SHALL BE THE CONTRACTOR'S RESPONSIBILITY TO PLACE WHAT BRACING, SHORING OR GROUND SUPPORT SYSTEM THAT IS DEEMED NECESSARY TO PREVENT A FAILURE AND PROTECT THE PERSONS WORKING NEAR THE EXCAVATION. THE PUBLIC THAT MAY BE ABOVE THE EXCAVATION, OR ANY STRUCTURE ADJACENT TO THE EXCAVATION. ALL COSTS FOR ANY PROTECTIVE MEASURES, INCLUDING THE MATERIALS AND LABOR FOR DESIGNING, DRAFTING AND CONSTRUCTING THE FACILITY, SHALL BE INCLUDED IN THE PRICE BID FOR CONTRACT ITEMS.
6. UTILITY LINES OR SERVICE LINES ENCOUNTERED DURING CONSTRUCTION, WHETHER SHOWN ON THE DRAWINGS OR NOT, SHALL BE PROTECTED BY THE CONTRACTOR AND REPAIRS NECESSARY DUE TO DAMAGE TO SOME BY THE CONTRACTOR SHALL BE AT NO ADDITIONAL COST TO THE OWNER.
7. UTILITY LINES OR SERVICE LINES ENCOUNTERED DURING CONSTRUCTION, WHETHER SHOWN ON THE DRAWINGS OR NOT, SHALL BE PROTECTED BY THE CONTRACTOR AND REPAIRS NECESSARY DUE TO DAMAGE TO SOME BY THE CONTRACTOR SHALL BE AT NO ADDITIONAL COST TO THE OWNER.
8. THE CONTRACTOR SHALL FERTILIZE, SEED AND MULCH AREAS WHERE THE EXISTING VEGETATION WAS REMOVED OR DISTURBED DURING CONSTRUCTION. ESTABLISHMENT OF VEGETATION FOR AREAS DISTURBED OUTSIDE OF CONSTRUCTION INDICATED ON THE PROJECT PLANS SHALL BE PAID FOR BY THE CONTRACTOR.
9. SURVEY CONTROL POINT PROVIDED ONSITE AS INDICATED ON EXISTING CONDITIONS/DEMOLITION PLAN SHEET (SHEET 3 OF PLAN ASSEMBLY). DETAILED CONSTRUCTION STAKING WILL BE BY CONTRACTOR AND SHALL BE AN ABSORBED COST ITEM.
10. THE CONTRACTOR SHALL MAINTAIN THROUGH TRAFFIC ALONG EXISTING ROADS FOR THE LENGTH OF THE CONTRACT PERIOD. ALL TRAFFIC CONTROL SHALL BE IN ACCORDANCE WITH THE REQUIREMENTS OF THE MANUAL OF UNIFORM TRAFFIC CONTROL DEVICES, LATEST EDITION(S).

EROSION CONTROL NOTES:

1. PRIOR TO CONSTRUCTION, EROSION AND SEDIMENT CONTROL MEASURES SHALL BE IN PLACE. CLEARING AND GRUBBING OPERATIONS WILL BE ENGAGED IN ONLY AS NECESSARY TO ALLOW THE PLACEMENT OF EROSION AND SEDIMENT CONTROL MEASURES AS SHOWN UNTIL ALL MEASURES ARE IN PLACE.
2. EROSION CONTROL MEASURES SHOWN ARE THE MINIMUM REQUIRED. CONTRACTOR RESPONSIBLE FOR INSTALLING AND MAINTAINING ADDITIONAL EROSION CONTROL MEASURES AS REQUIRED TO PREVENT SITE EROSION AND SEDIMENT TRANSPORT.
3. SILT FENCES SHALL BE CLEANED OR REPLACED WHEN SILT BUILDS UP TO 1' FROM THE BOTTOM OF THE FENCE.
4. ALL GRADED (AND DISTURBED) AREAS SHALL BE STABILIZED WITH PERMANENT VEGETATION UPON COMPLETION OF GRADING OPERATIONS. COMPLETION OF GRADING OPERATIONS DOES NOT MEAN AT THE END OF THE PROJECT. AS SOON AS FINAL GRADES ARE ESTABLISHED IN AN UNPAVED AREA, THE CONTRACTOR SHALL STABILIZE WITH PERMANENT VEGETATION. IF A TEMPORARY GRASS IS APPLIED, IT WILL BE THE CONTRACTOR'S RESPONSIBILITY TO ESTABLISH PERMANENT VEGETATION AS REQUIRED PER CONTRACT.
5. FILL SLOPES SHOULD BE PLANTED AS SOON AS AN AREA OF THE SITE IS BROUGHT TO FINAL GRADE. SURFACE RUNOFF SHALL BE INTERCEPTED AT THE TOP OF TEMPORARY AND PERMANENT SLOPES DURING CONSTRUCTION SO THAT WATER IS NOT ALLOWED TO FLOW OVER THE SLOPE FACE.
6. CONTRACTOR RESPONSIBLE FOR WATERING OPERATIONS REQUIRED TO ESTABLISH TEMPORARY AND PERMANENT VEGETATION.
7. CONTRACTOR SHALL REVIEW THEIR PROPOSED GRADING/CONSTRUCTION SEQUENCE TO ENSURE THAT THE LEAST AMOUNT OF LAND POSSIBLE AT ANY ONE TIME IS DISTURBED WITHOUT PERMANENT STABILIZATION.
8. LAND DISTURBING ACTIVITIES WILL BE KEPT TO A MINIMUM AND WILL NOT EXTEND BEYOND THE LIMITS SHOWN.
9. FOLLOWING COMPLETION OF GRADING/CONSTRUCTION ACTIVITIES AND PERMANENT SITE STABILIZATION, CONTRACTOR SHALL REMOVE AND PROPERLY DISPOSE OF ACCUMULATED SEDIMENTS IN DITCHES AND SUBSURFACE DRAINAGE PIPES AND RE-ESTABLISH PROPOSED GRADES IN ROADSIDE DITCHES.
10. EROSION CONTROL MEASURES SHOWN ARE TEMPORARY MEASURES AND SHALL BE REMOVED PRIOR TO COMPLETION OF CONSTRUCTION AND FOLLOWING PERMANENT SITE STABILIZATION.
11. CONTRACTOR SHALL PREVENT TRACKING OF MUD AND/OR SEDIMENT ONTO PUBLIC ROADWAYS AND SHALL REMOVE ANY ACCUMULATED MUD AND/OR SEDIMENT ON A DAILY BASIS AT NO ADDITIONAL COST TO OWNER.
12. CONTRACTOR RESPONSIBLE FOR MAINTAINING COPY OF LARGE CONSTRUCTION NOTICE OF INTENT (LCONI) ONSITE THROUGHOUT LIFE OF CONTRACT.
13. CONTRACTOR SHALL COMPLY WITH THE MISSISSIPPI DEPARTMENT OF ENVIRONMENTAL QUALITY (MDEQ) STORMWATER REQUIREMENTS & WITH ALL FEDERAL, STATE & LOCAL EROSION CONTROL LAWS.

LEGEND

EXISTING RIGHT-OF-WAY	
EXISTING WATER LINE	
EXISTING GRAVITY SEWER	
EXISTING SEWER FORCE MAIN	
EXISTING OVERHEAD POWER LINE	
EXISTING UNDERGROUND TELECOM	
EXISTING GAS LINE	
EXISTING FENCE	
EXISTING PARCEL BOUNDARY	
EXISTING EDGE OF PAVEMENT	
EXISTING GRAVEL DRIVE	
EXISTING TREELINE	
EXISTING STREAM	
EXISTING EMERGENT WETLAND	
EXISTING POWER POLE	
EXISTING SEWER MANHOLE	
EXISTING WATER VALVE	
EXISTING FIRE HYDRANT	
EXISTING GUY	
EXISTING SEWER CLEANOUT	
PROPOSED RIGHT-OF-WAY	
PROPOSED GRAVITY SEWER	
PROPOSED SEWER FORCE MAIN	
PROPOSED WATER (BY OTHERS)	
PROPOSED HDPE DIRECTIONAL BORE	
PROPOSED STEEL CASING	
PROPOSED SEWER MANHOLE/STRUCTURE	
PROPOSED CRUSHED STONE SURFACE	



REVISION	BY	DATE
1	WLC	5/17/23
0		



CLIENT	CLARK BEVERAGE GROUP, INC.
PROJECT	PROJECT JOY SALES CENTER
DRAWING TITLE	CANTON, MS

PROJECT NO. 2300639
ISSUED: 5-17-2023
SCALE: AS NOTED
DRAWN BY: WLC
DRAWING NO.

C0.1

[C0.2

PROJECT JOY SALES CENTER
CANTON, MS



DRAWING
TITLE

[illegible]

Design Group

DG ARCHITECTURAL AND ENGINEERING FACILITY SOLUTIONS, PLLC
 1075 WINDWARD RIDGE PKWY, STE 100, ALPHARETTA, GA 30005
 PHONE: (770) 667-6250 FAX: (770) 667-6251



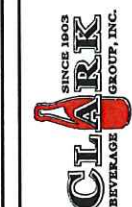
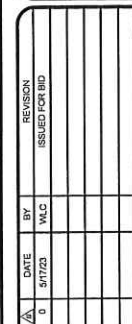


CLIENT	CLARK BEVERAGE GROUP, INC. OAKLAND, KY
PROJECT	PROJECT JOY SALES CENTER CANTON, MS
PROGRAMING	

PROJECT NO. 2300638
ISSUED: 5-17-2023
SCALE: AS NOTED
DRAWN BY: WLC
DRAWING NO.

C2.0



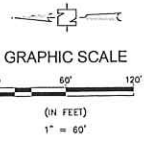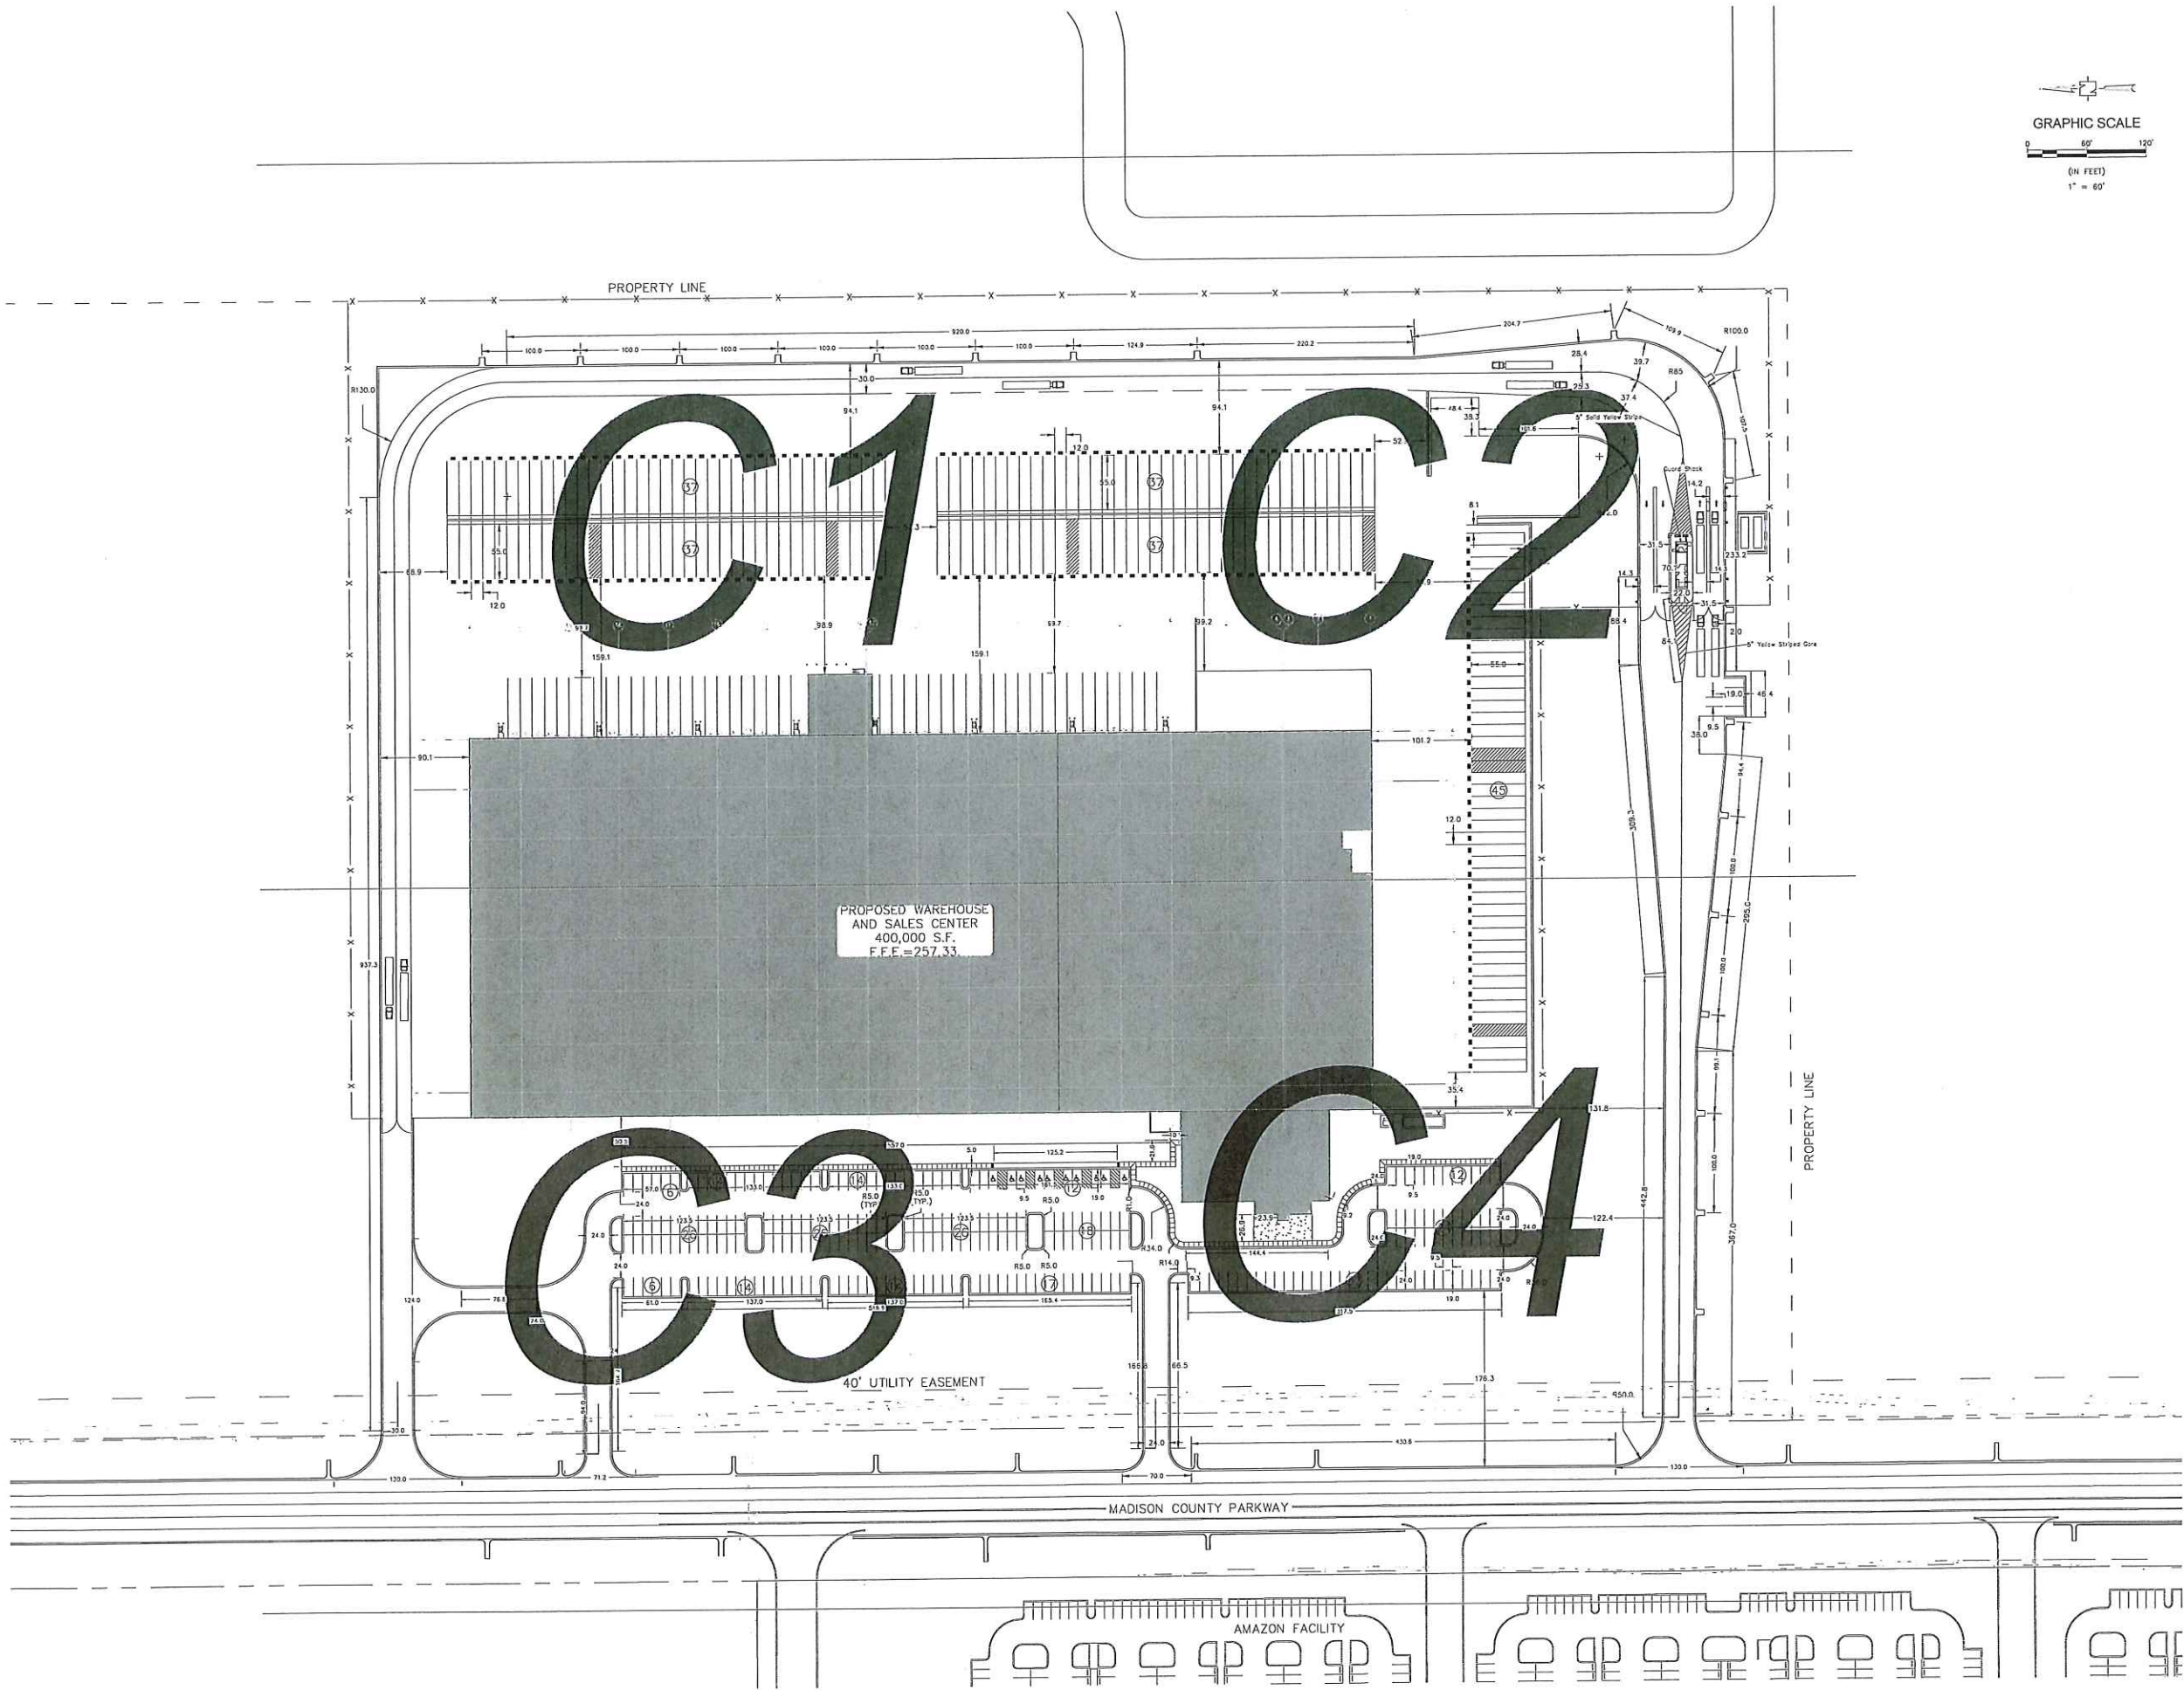

Design Group

DC ARCHITECTURAL AND ENGINEERING FACILITY SOLUTIONS, PLLC
105 VISIONARY RIDGE PKWY, STE 100, ALPHARETTA, GA 30005
PHONE (770) 867-5252 FAX (770) 867-5251

REVISION	DATE	BY	REVISION
ISSUED FOR BID	5/17/23	WLC	



CLIENT	CLARK BEVERAGE GROUP, INC.
PROJECT	PROJECT JOY SALES CENTER CANTON, MS
DRAWING TITLE	SITE PLAN LAYOUT

PROJECT NO. 2300838
ISSUED: 5-17-2023
SCALE: AS NOTED
DRAWN BY: WLC
DRAWING NO.
C2.1

GRAPHIC SCALE

0 30' 60'

(IN FEET)

1" = 30'





C1	C2
C3	C4

GRID MAP

[illegible]

CLIENT	CLARK BEVERAGE GROUP, INC. OAKLAND, KY
PROJECT	PROJECT JOY SALES CENTER CANTON, MS
OWNER	

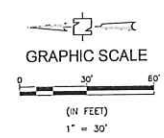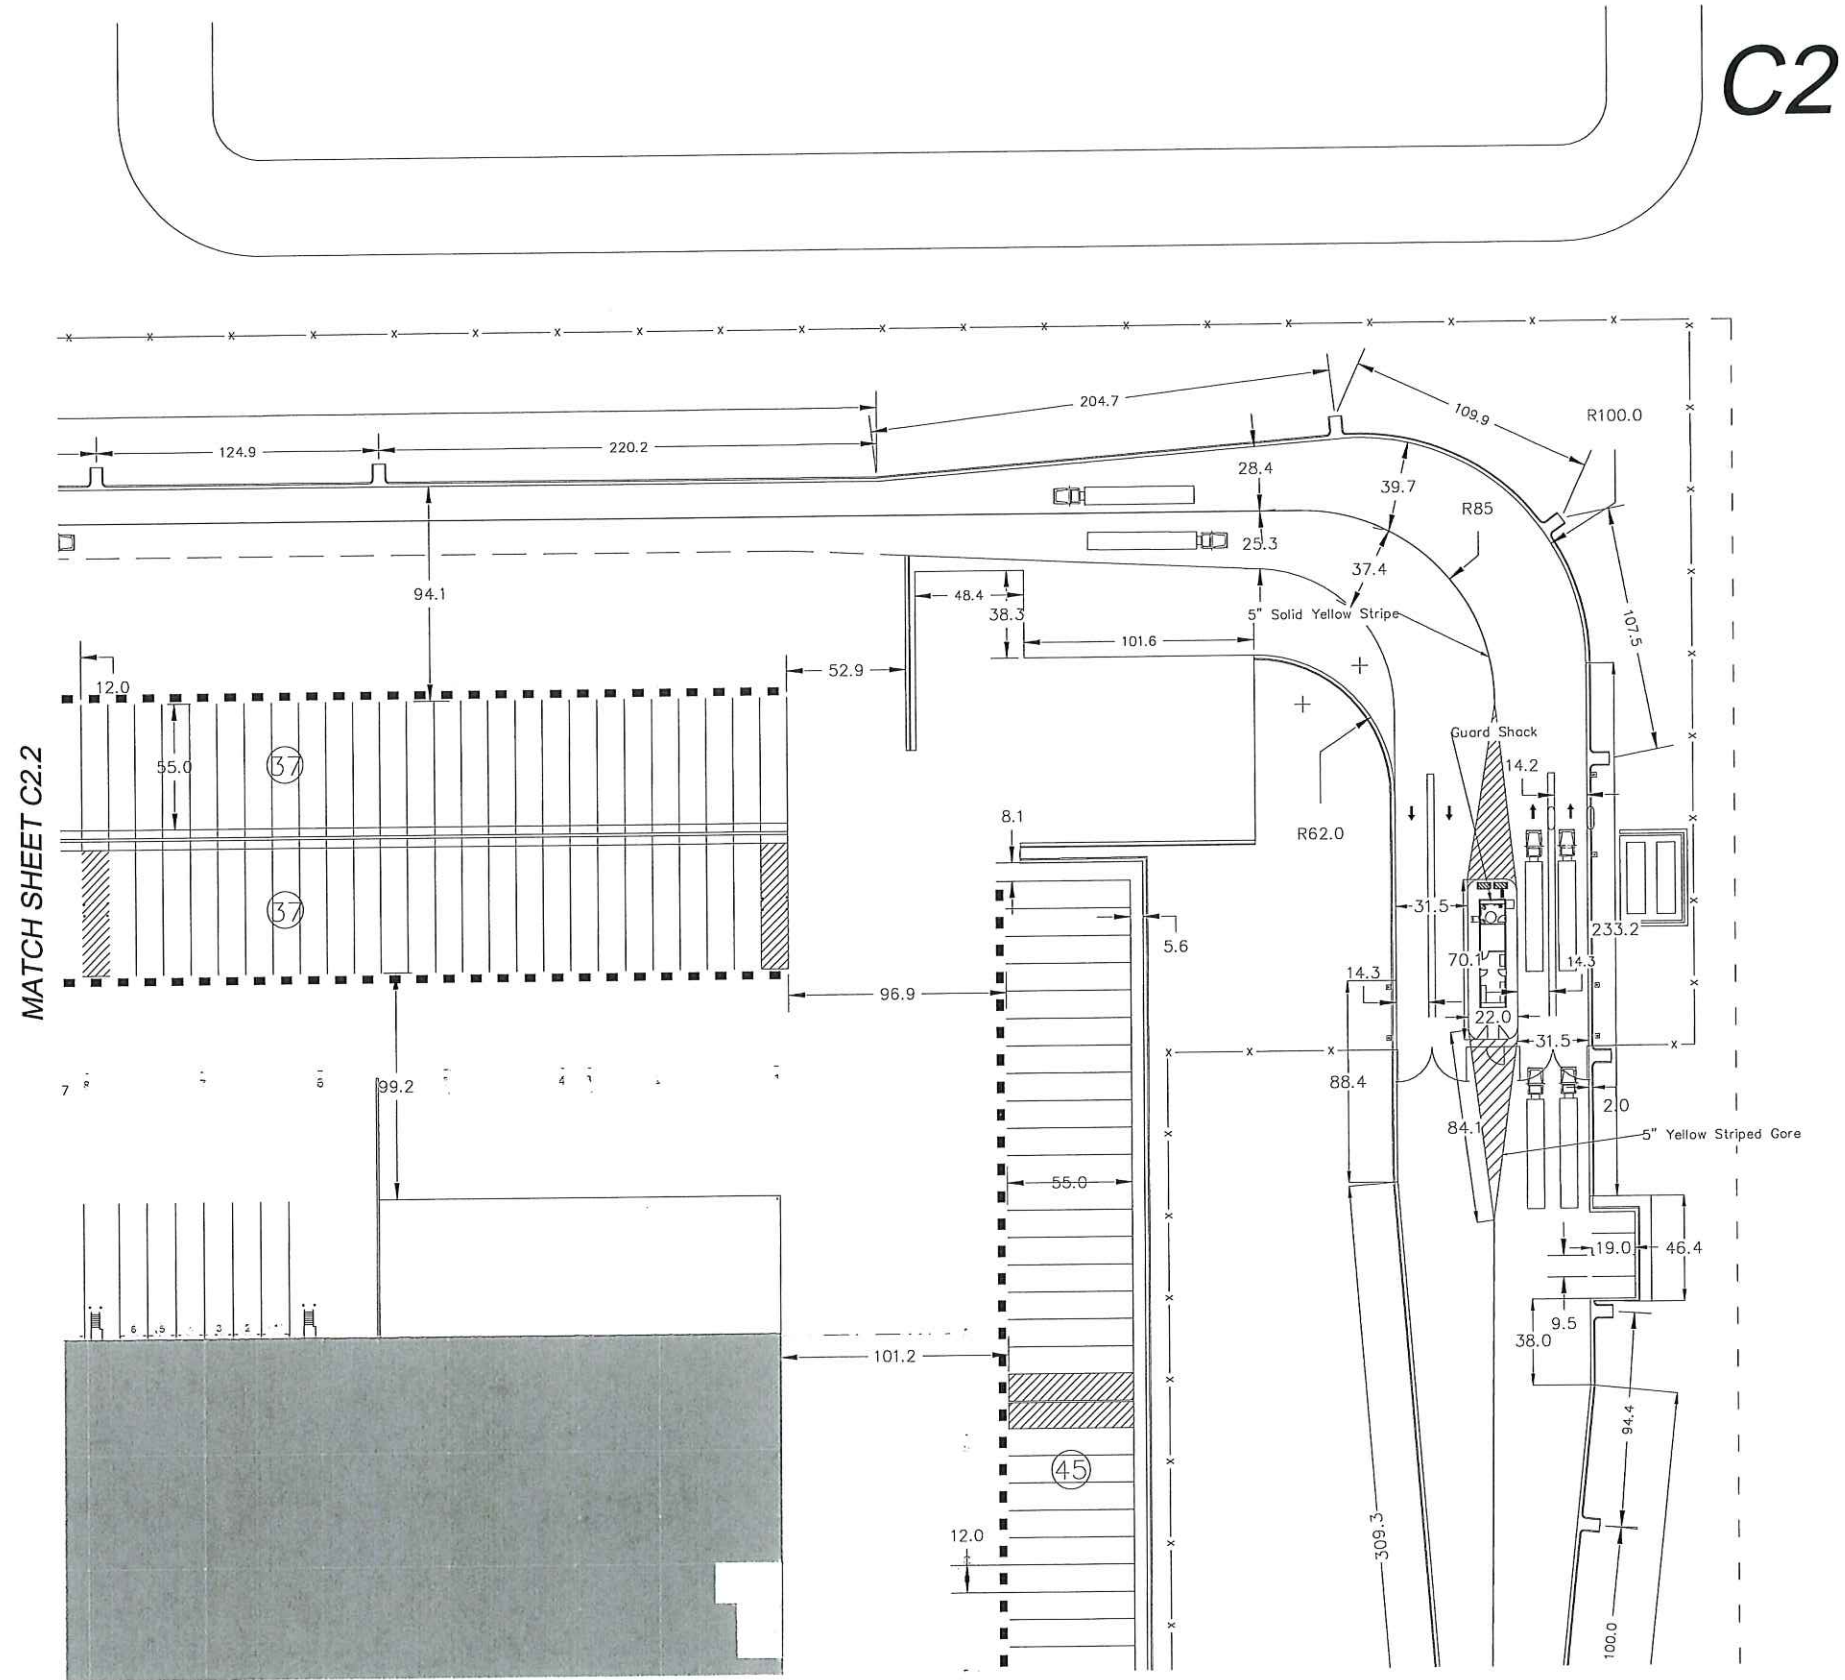

C1C2
C3C4
GRID MAP



Design Group
DG ARCHITECTURAL AND ENGINEERING FACILITY SOLUTIONS, PLLC
3075 WINDWARD RIDGE DRIVE, SUITE 100, CANTON, MS 39005
PHONE: (769) 687-5254 FAX: (769) 687-5251



REVISION	BY	DATE
ISSUED FOR BID	WLC	9/17/23



CLIENT	CLARK BEVERAGE GROUP, INC. CANTON, KY
PROJECT	PROJECT JOY SALES CENTER CANTON, MS
DRAWING TITLE	SITE PLAN LAYOUT

PROJECT NO.	2300638
ISSUED	5-17-2023
SCALE	AS NOTED
DRAWN BY	WLC
DRAWING NO.	C2.3

MATCH SHEET C2.2

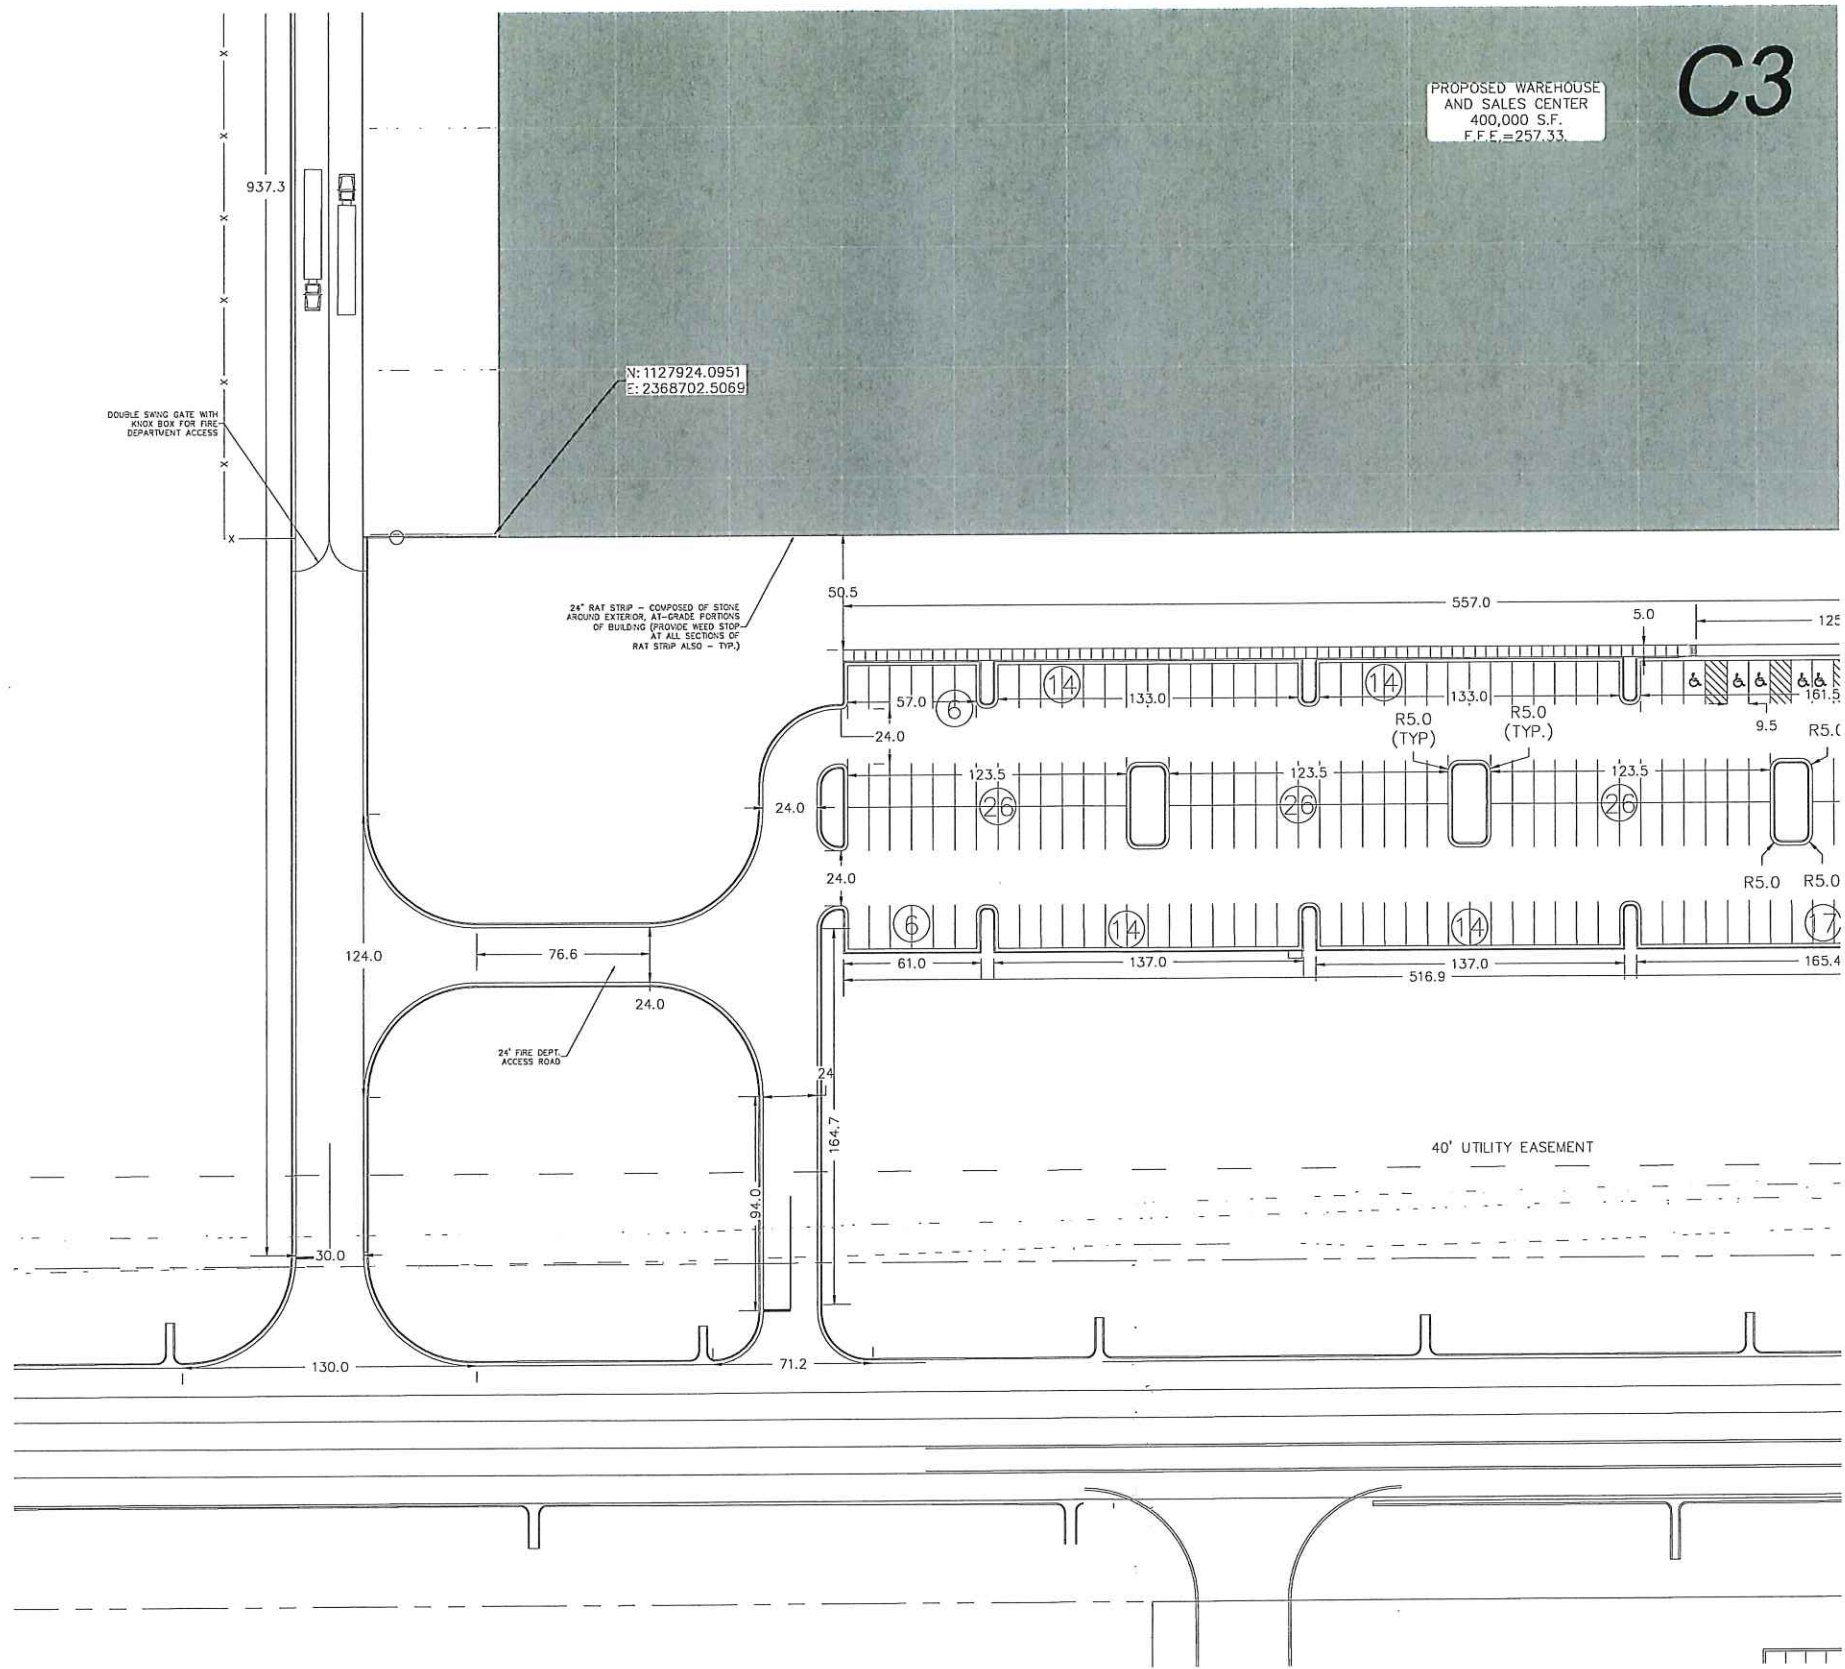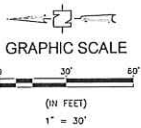


PROPOSED WAREHOUSE
AND SALES CENTER
400,000 S.F.
F.F.E. = 257.33

C3

N: 1127924.0951
E: 2368702.5069

 MATCH SHEET C2.5



Design Group



DC ARCHITECTURAL AND ENGINEERING FACILITY SOLUTIONS, PLLC
1075 WINDWARD RIDGE PKWY, STE 100, ALPHARETTA, GA 30005
PHONE: (770) 567-5200 FAX: (770) 567-0251

REVISION	BY	DATE
ISSUED FOR BID	WLC	5/17/23



CLIENT	CLARK BEVERAGE GROUP, INC. OAKLAND, KY
PROJECT	PROJECT JOY SALES CENTER CANTON, MS
DRAWING TITLE	SITE PLAN LAYOUT

PROJECT NO.	23000638
ISSUED:	5-17-2023
SCALE:	AS NOTED
DRAWN BY:	WLC
DRAWING NO.	C2.4

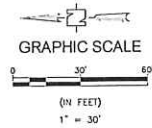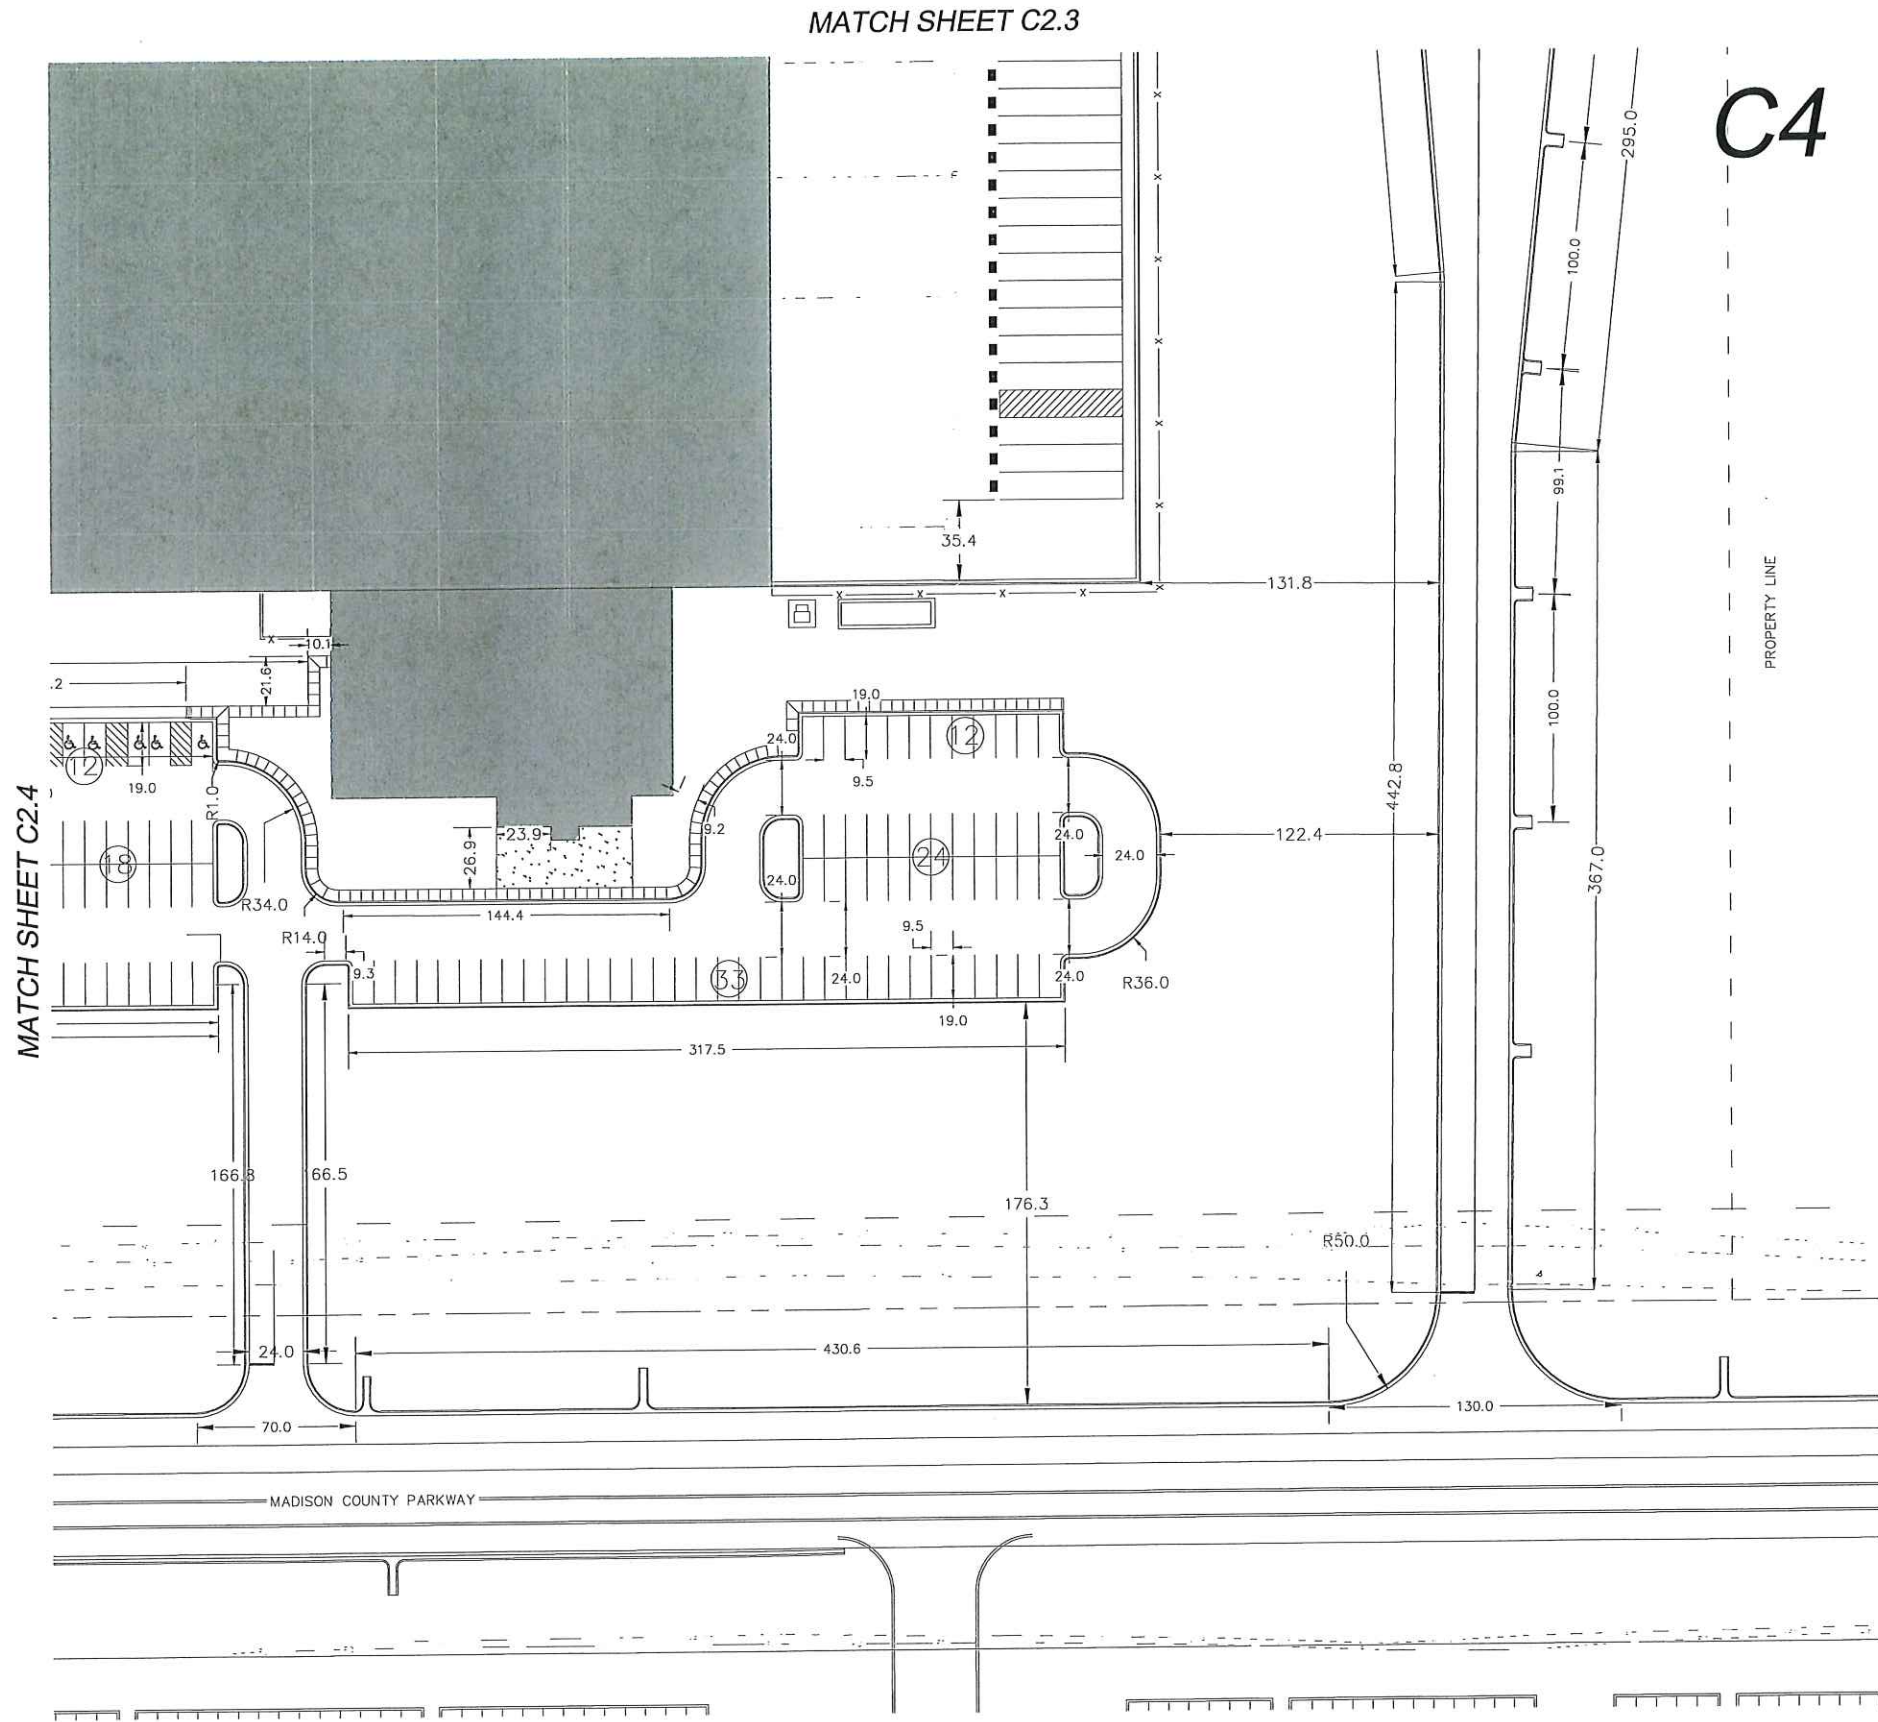

C1C2
C3C4
GRID MAP



Design Group
DC ARCHITECTURAL AND ENGINEERING FACILITY SOLUTIONS, PLLC
1075 WINDWARD RIDGE PARK, STE 100, ALPHARETTA, GA 30005
PHONE: (770) 667-6258 FAX: (770) 667-6251


REVISION	DATE	BY	ISSUED FOR BID
1	5/17/23	WLC	



CLIENT: CLARK BEVERAGE GROUP, INC.
OAKLAND, KY
PROJECT: PROJECT JOY SALES CENTER
CANTON, MS
DRAWING TITLE: SITE PLAN LAYOUT

PROJECT NO. 2300638
ISSUED: 5-17-2023
SCALE: AS NOTED
DRAWN BY: WLC
DRAWING NO.

C2.5

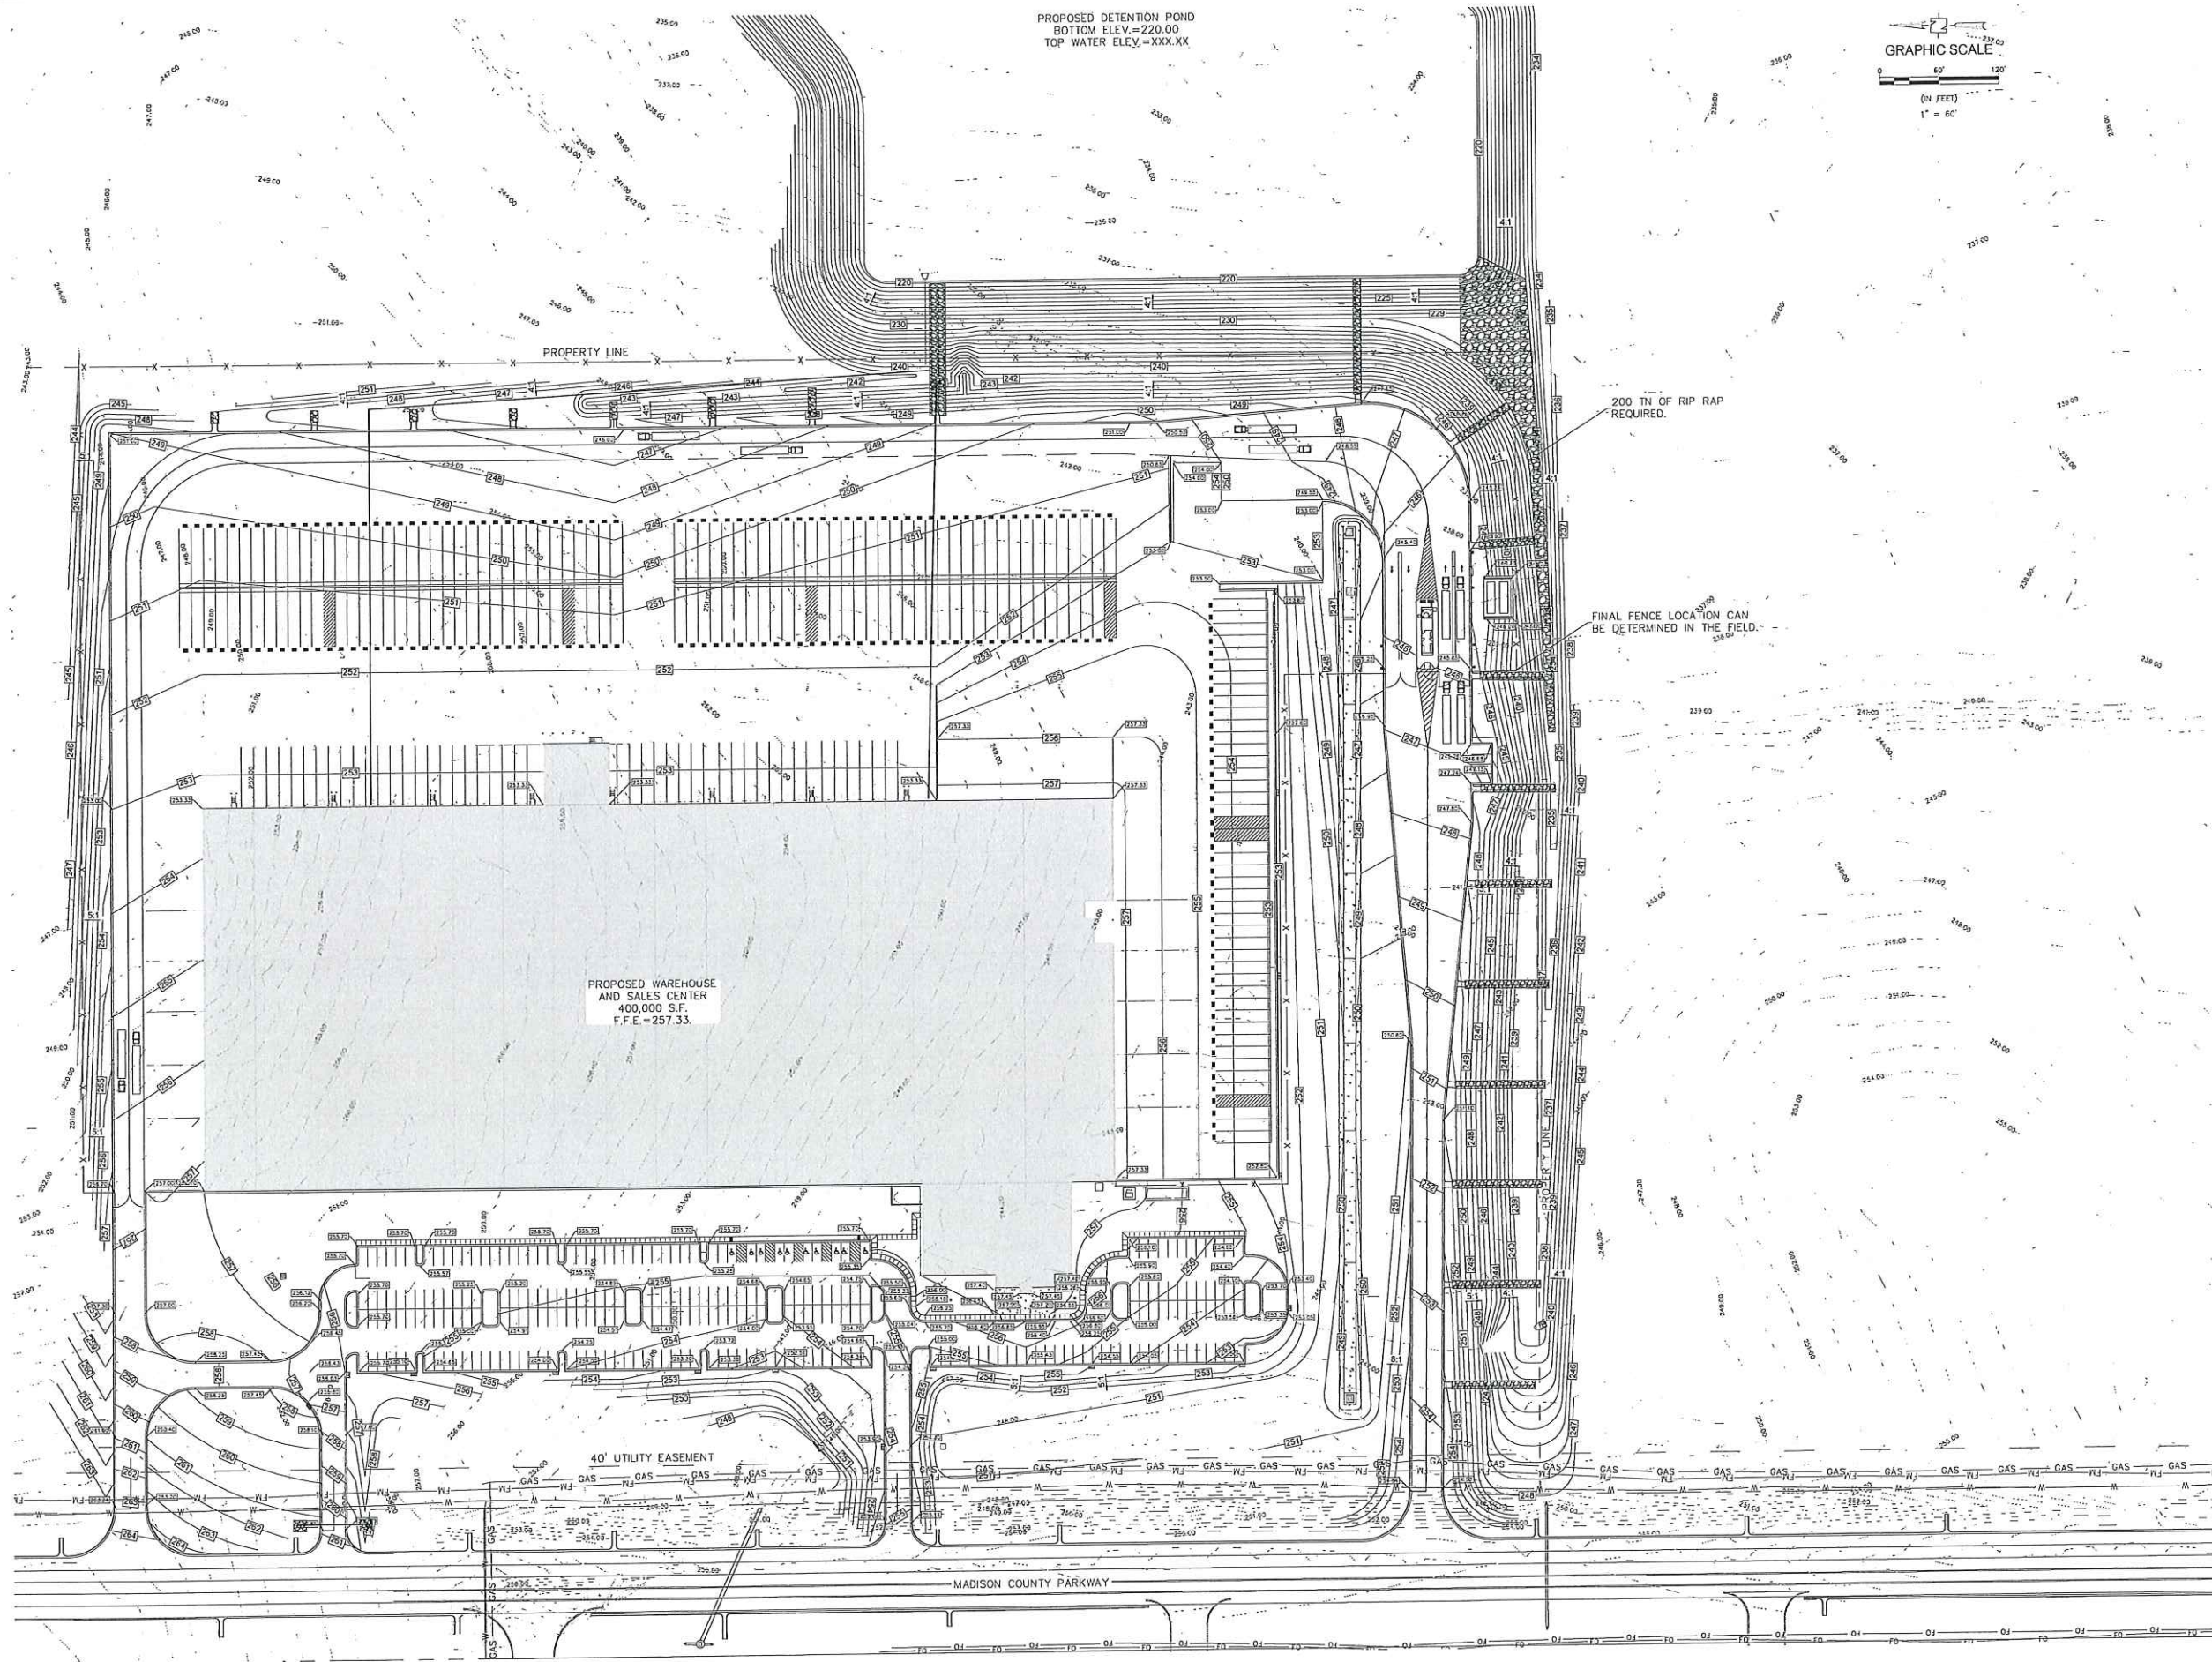

Design Group
DG ARCHITECTURAL AND ENGINEERING FACILITY SOLUTIONS, PLLC
1075 WINDWARD RIDGE HWY, STE 100, ALPHARETTA, GA 30005
PHONE: (770) 667-6289 FAX: (770) 667-6251

DATE	BY	REVISION
5/17/23	WLC	ISSUED FOR BID - EARTHWORK




CLIENT: CLARK BEVERAGE GROUP, INC.
OAKLAND, KY
PROJECT: PROJECT JOY SALES CENTER
CANTON, MS
DRAWING TITLE: SITE GRADING & DRAINAGE



PROJECT NO: 2300638
ISSUED: 5-17-2023
SCALE: AS NOTED
DRAWN BY: WLC
DRAWING NO:

C3.0

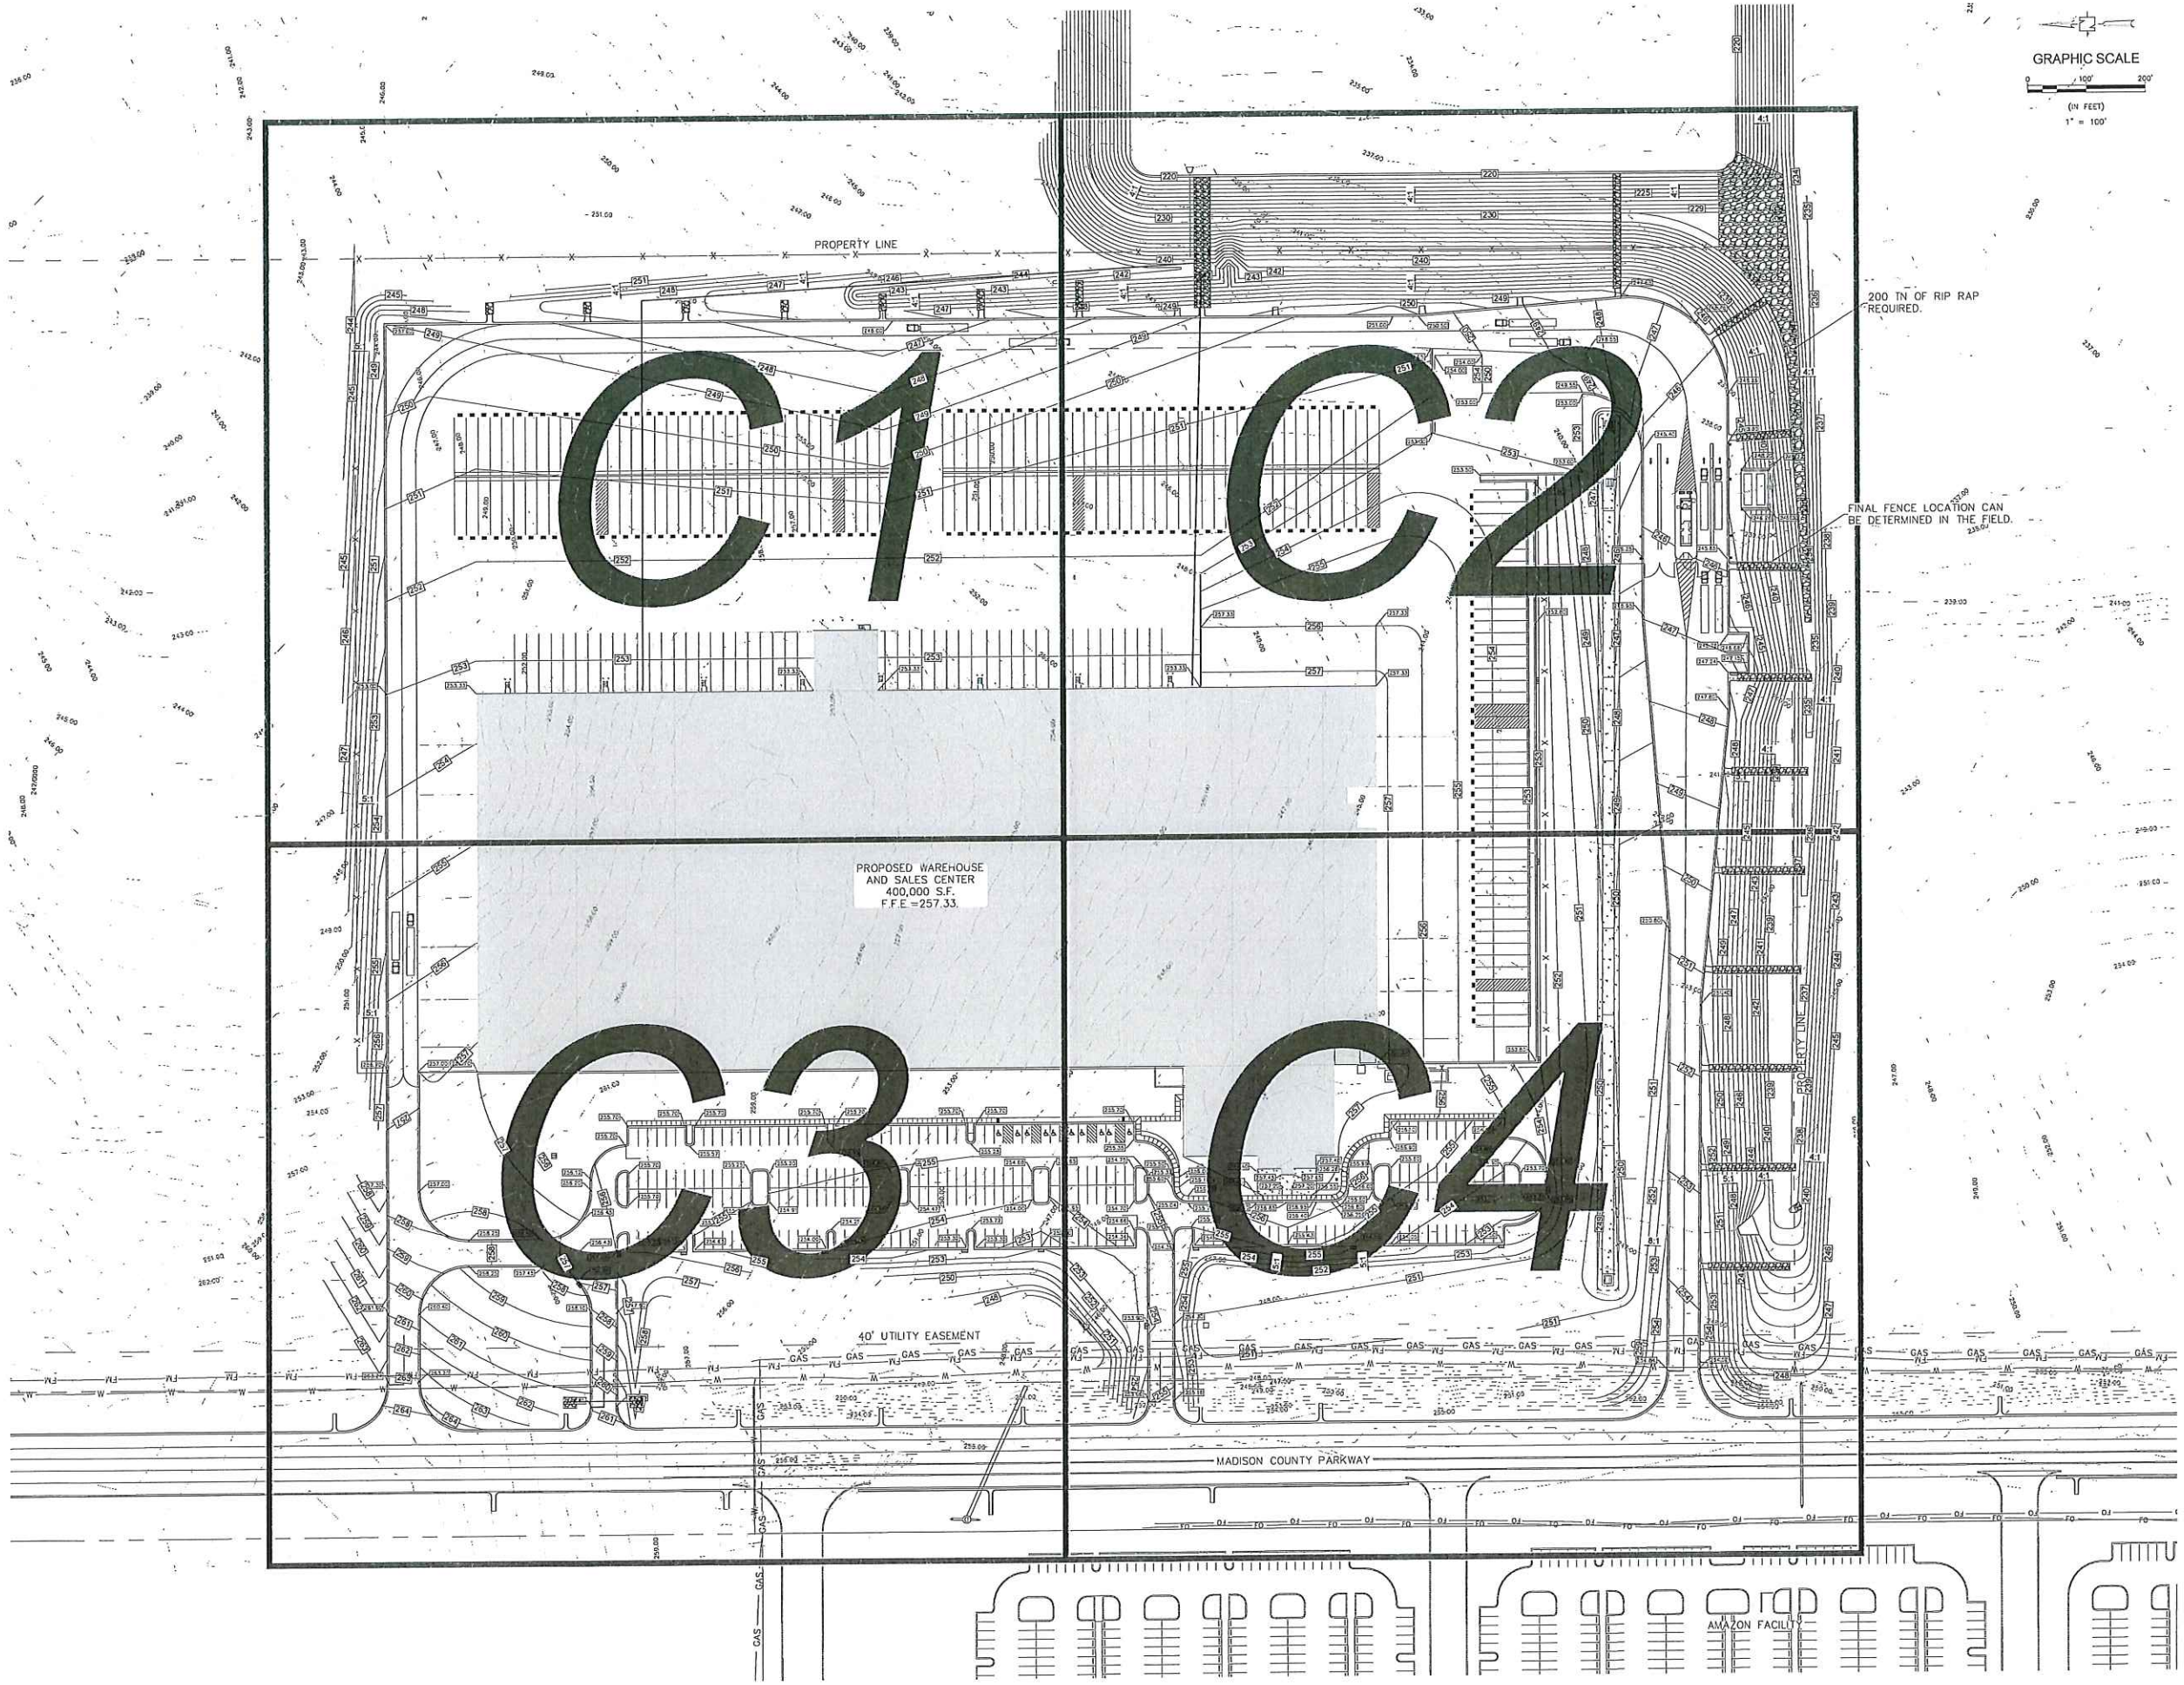

Design Group

DC ARCHITECTURAL AND ENGINEERING FACILITY SOLUTIONS, PLLC
 1075 VISIONARY RIDGE PKWY, STE 100, ALPHARETTA, GA 30005
 PHONE (770) 667-6285 FAX (770) 667-6281

DATE	BY	REVISION
5/17/23	WLC	ISSUED FOR BID - EARTHWORK



CLARK BEVERAGE GROUP, INC.
 OAKLAND, KY



PROJECT JOY SALES CENTER
 CANTON, MS

SITE GRADING & DRAINAGE



PROJECT NO. 2300618
 ISSUED 5-17-2023
 SCALE: AS NOTED
 DRAWN BY: WLC
 DRAWING NO.

C3.1

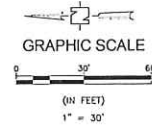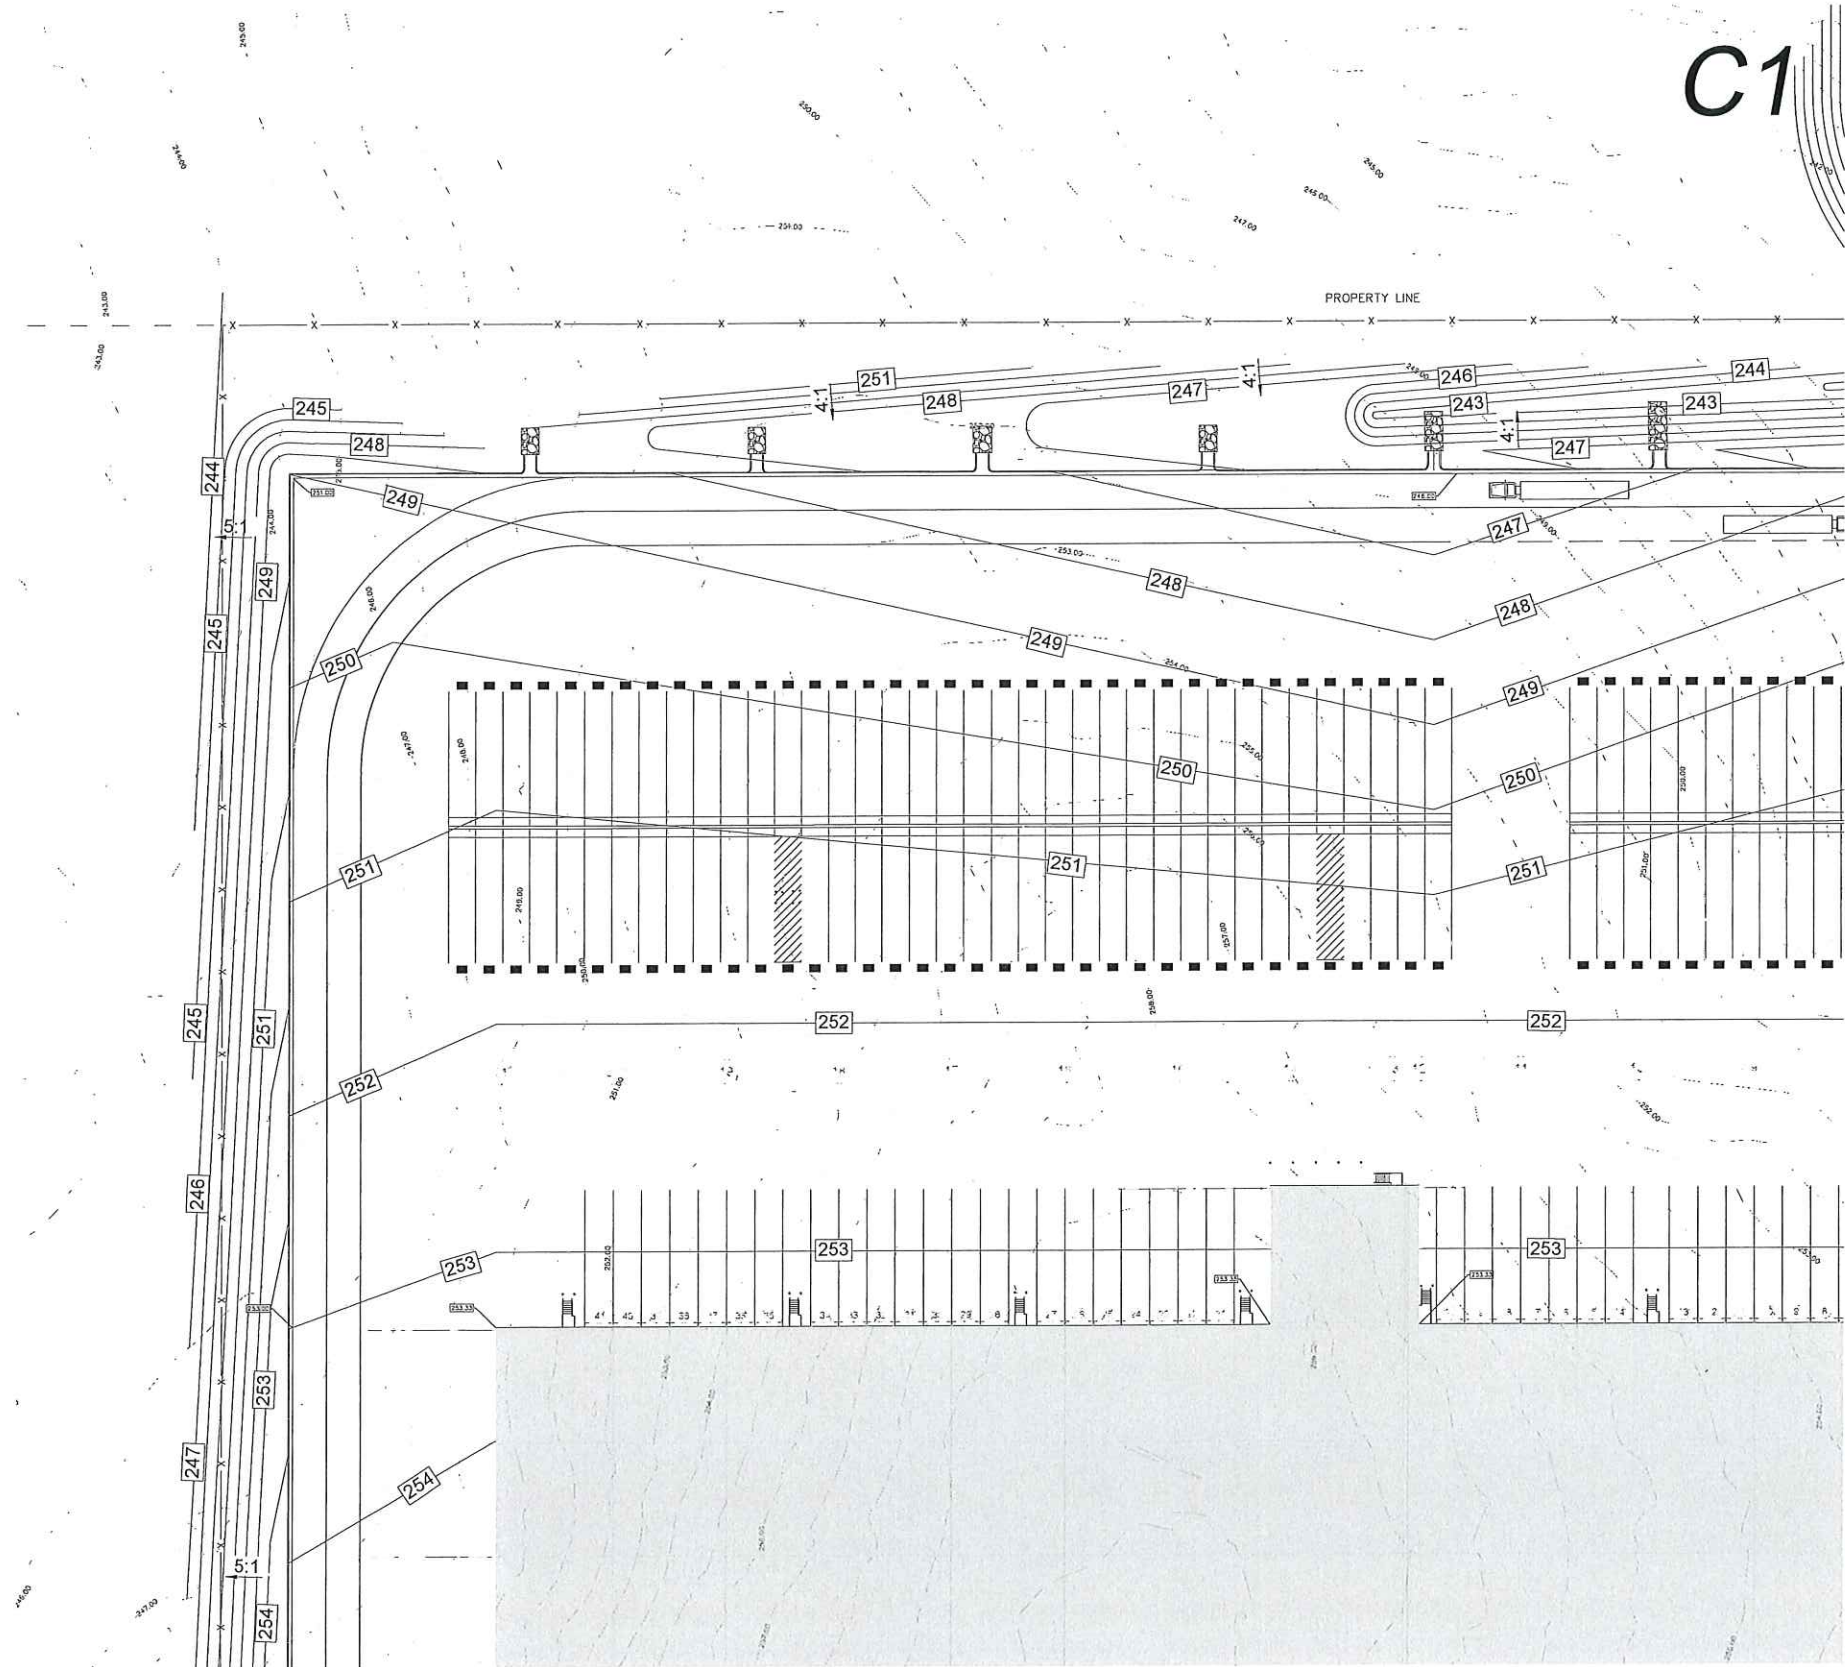

C1

MATCH SHEET C3.3

MATCH SHEET C3.4

C1C2
C3C4
GRID MAP



Design Group
DG ARCHITECTURAL AND ENGINEERING FACILITY SOLUTIONS, PLLC
1075 WINDWARD RIDGE PKWY, STE 100, ALPHARETTA, GA 30005
PHONE: (770) 667-6252 FAX: (770) 667-6251

DATE	BY	REVISION
5/17/23	WLC	ISSUED FOR BID - EARTHWORK



CLIENT CLARK BEVERAGE GROUP, INC.
OAKLAND, KY
PROJECT PROJECT JOY SALES CENTER
CANTON, MS
DRAWING TITLE SITE GRADING & DRAINAGE



PROJECT NO. 2000638
ISSUED: 5-17-2023
SCALE: AS NOTED
DRAWN BY: WLC
DRAWING NO.

C3.2



GRAPHIC SCALE

0 30' 60'

(IN FEET)

1" = 30'

MATCH SHEET C3.2

MATCH SHEET C3.5

200 TN OF RIP RAP
REQUIRED.

FINAL FENCE LOCATION CAN
BE DETERMINED IN THE FIELD.

C1	C2
C3	C4

GRID MAP



A	DATE	BY	REVISION
0	5/17/23	W.C	ISSUED FOR BID - EARTHWORK





CLIENT	CLARK BEVERAGE GROUP, INC. OAKLAND, KY
PROJECT	PROJECT JOY SALES CENTER CANTON, MS
DRAWING TITLE	SITE GRADING & DRAINAGE



PROJECT NO. 2300538
ISSUED: 5-17-2023
SCALE: AS NOTED
DRAWN BY: WLC
DRAWING NO.

C3.3

MATCH SHEET C3.2

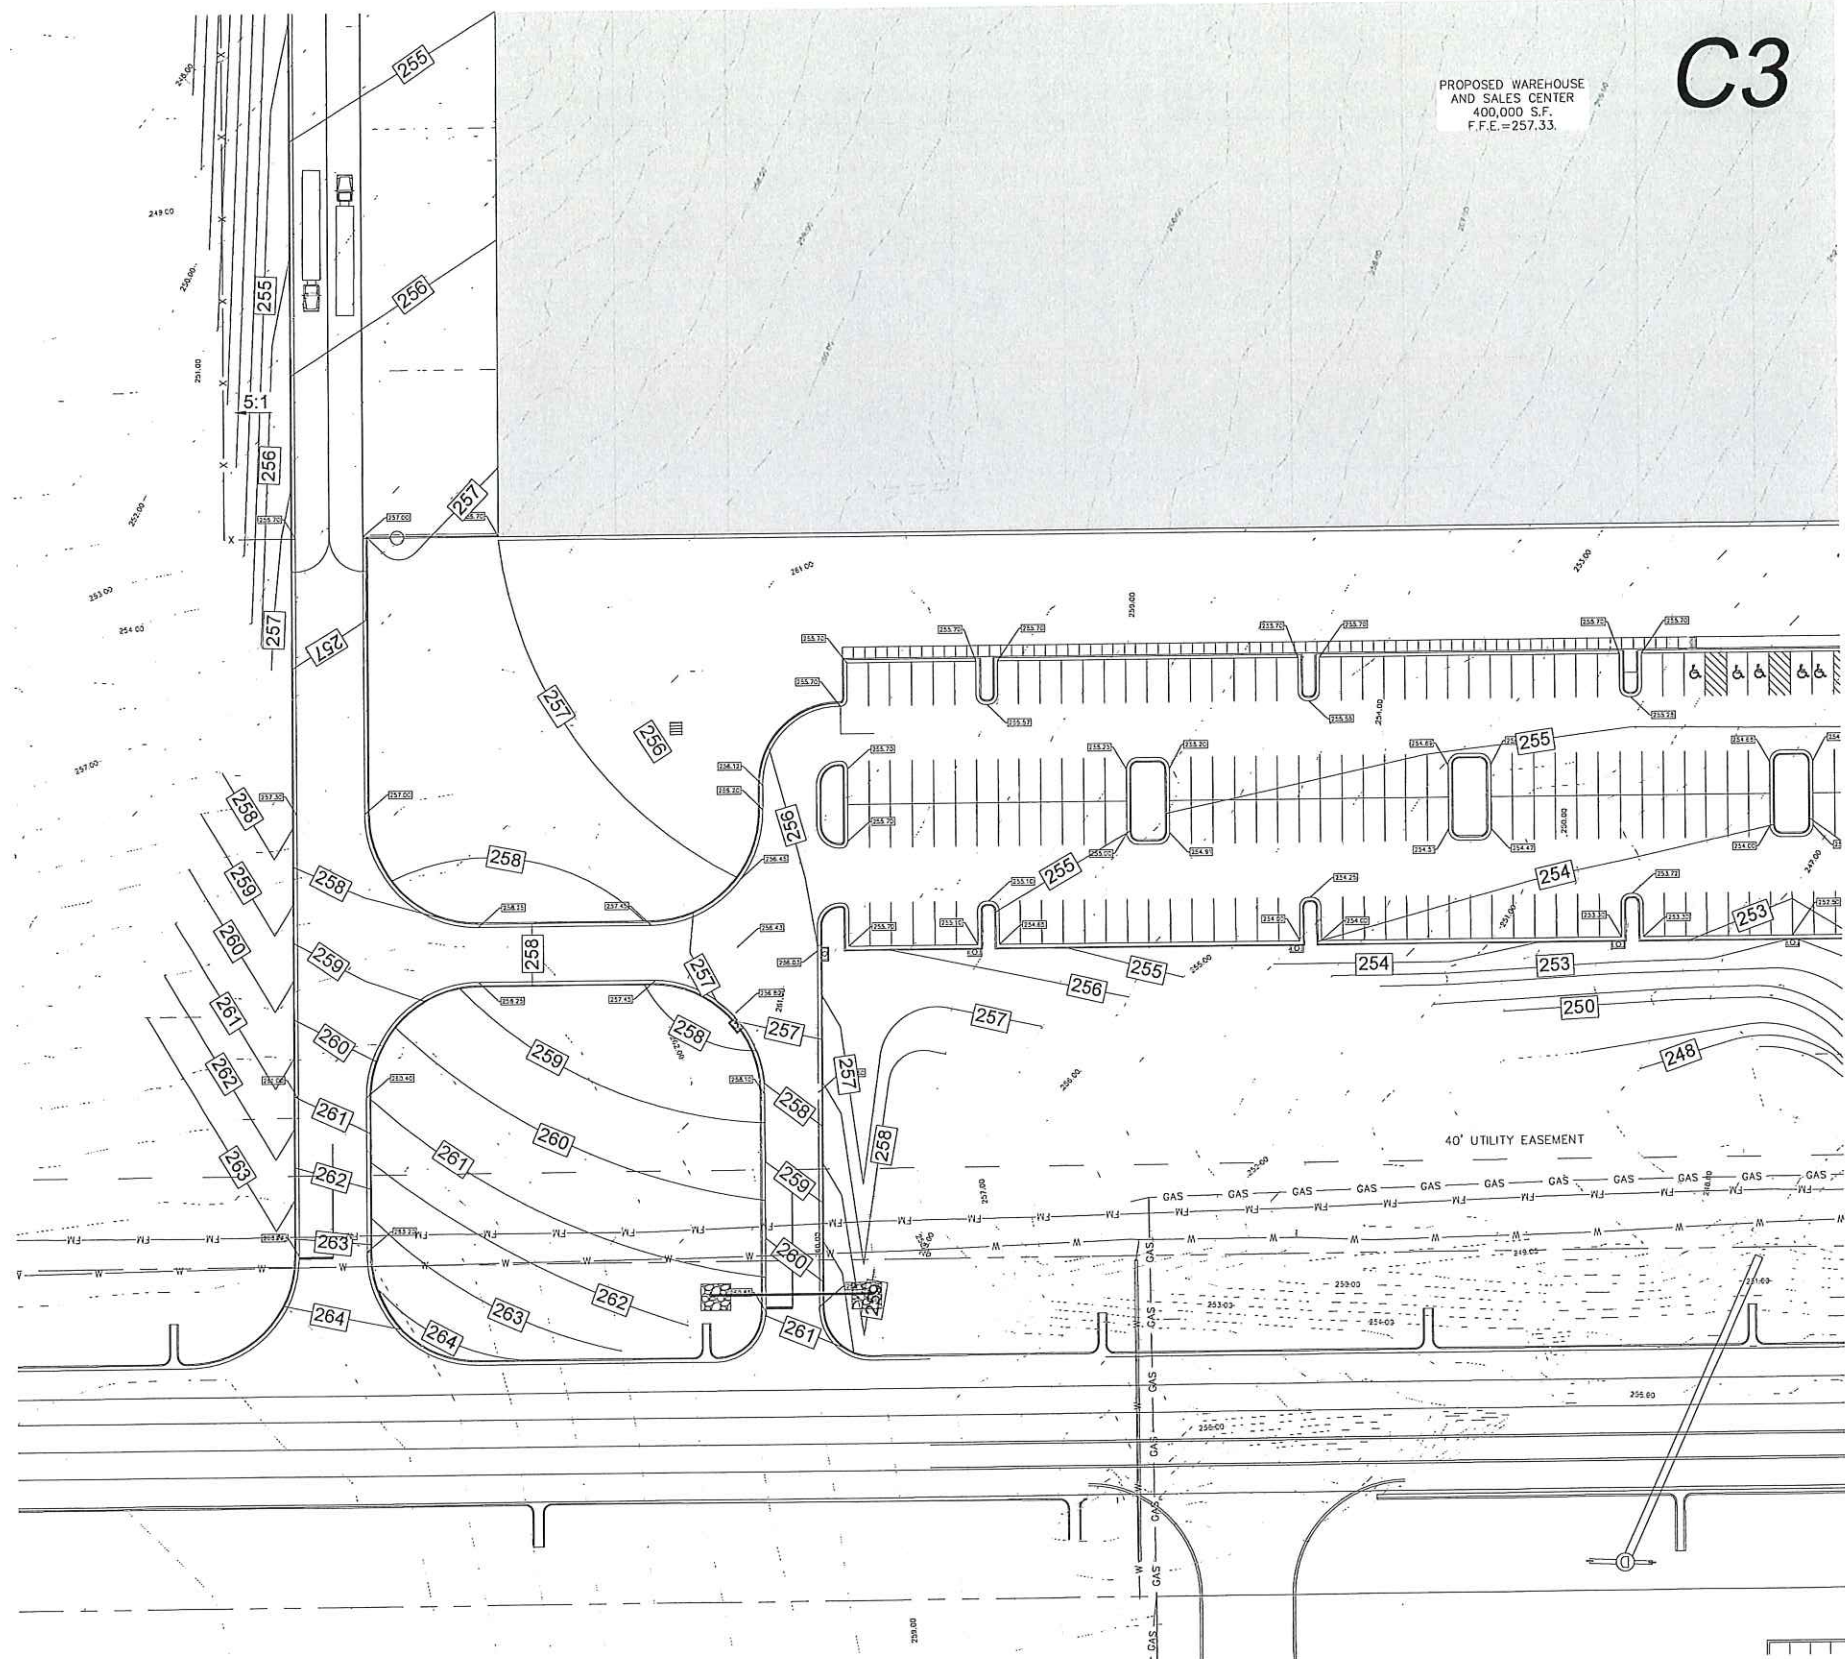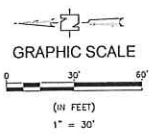


MATCH SHEET C3.5

C1C2
C3C4
GRID MAP



Design Group
DG ARCHITECTURAL AND ENGINEERING FACILITY SOLUTIONS, PLLC
3075 WINDWARD RIDGE PKWY, STE 100, ASPENHETTA, GA 30825
PHONE: (770) 687-6322 FAX: (770) 687-6321

REVISION	DATE	BY	DESCRIPTION
1	5/17/23	VLC	ISSUED FOR BID - EARTHWORK

 


CLIENT: CLARK BEVERAGE GROUP, INC.
OAKLAND, KY
PROJECT: PROJECT JOY SALES CENTER
CANTON, MS
DRAWING TITLE: SITE GRADING & DRAINAGE



PROJECT NO. 2300638
ISSUED: 5-17-2023
SCALE: AS NOTED
DRAWN BY: VLC
DRAWING NO.


C3.4

MATCH SHEET C3.4

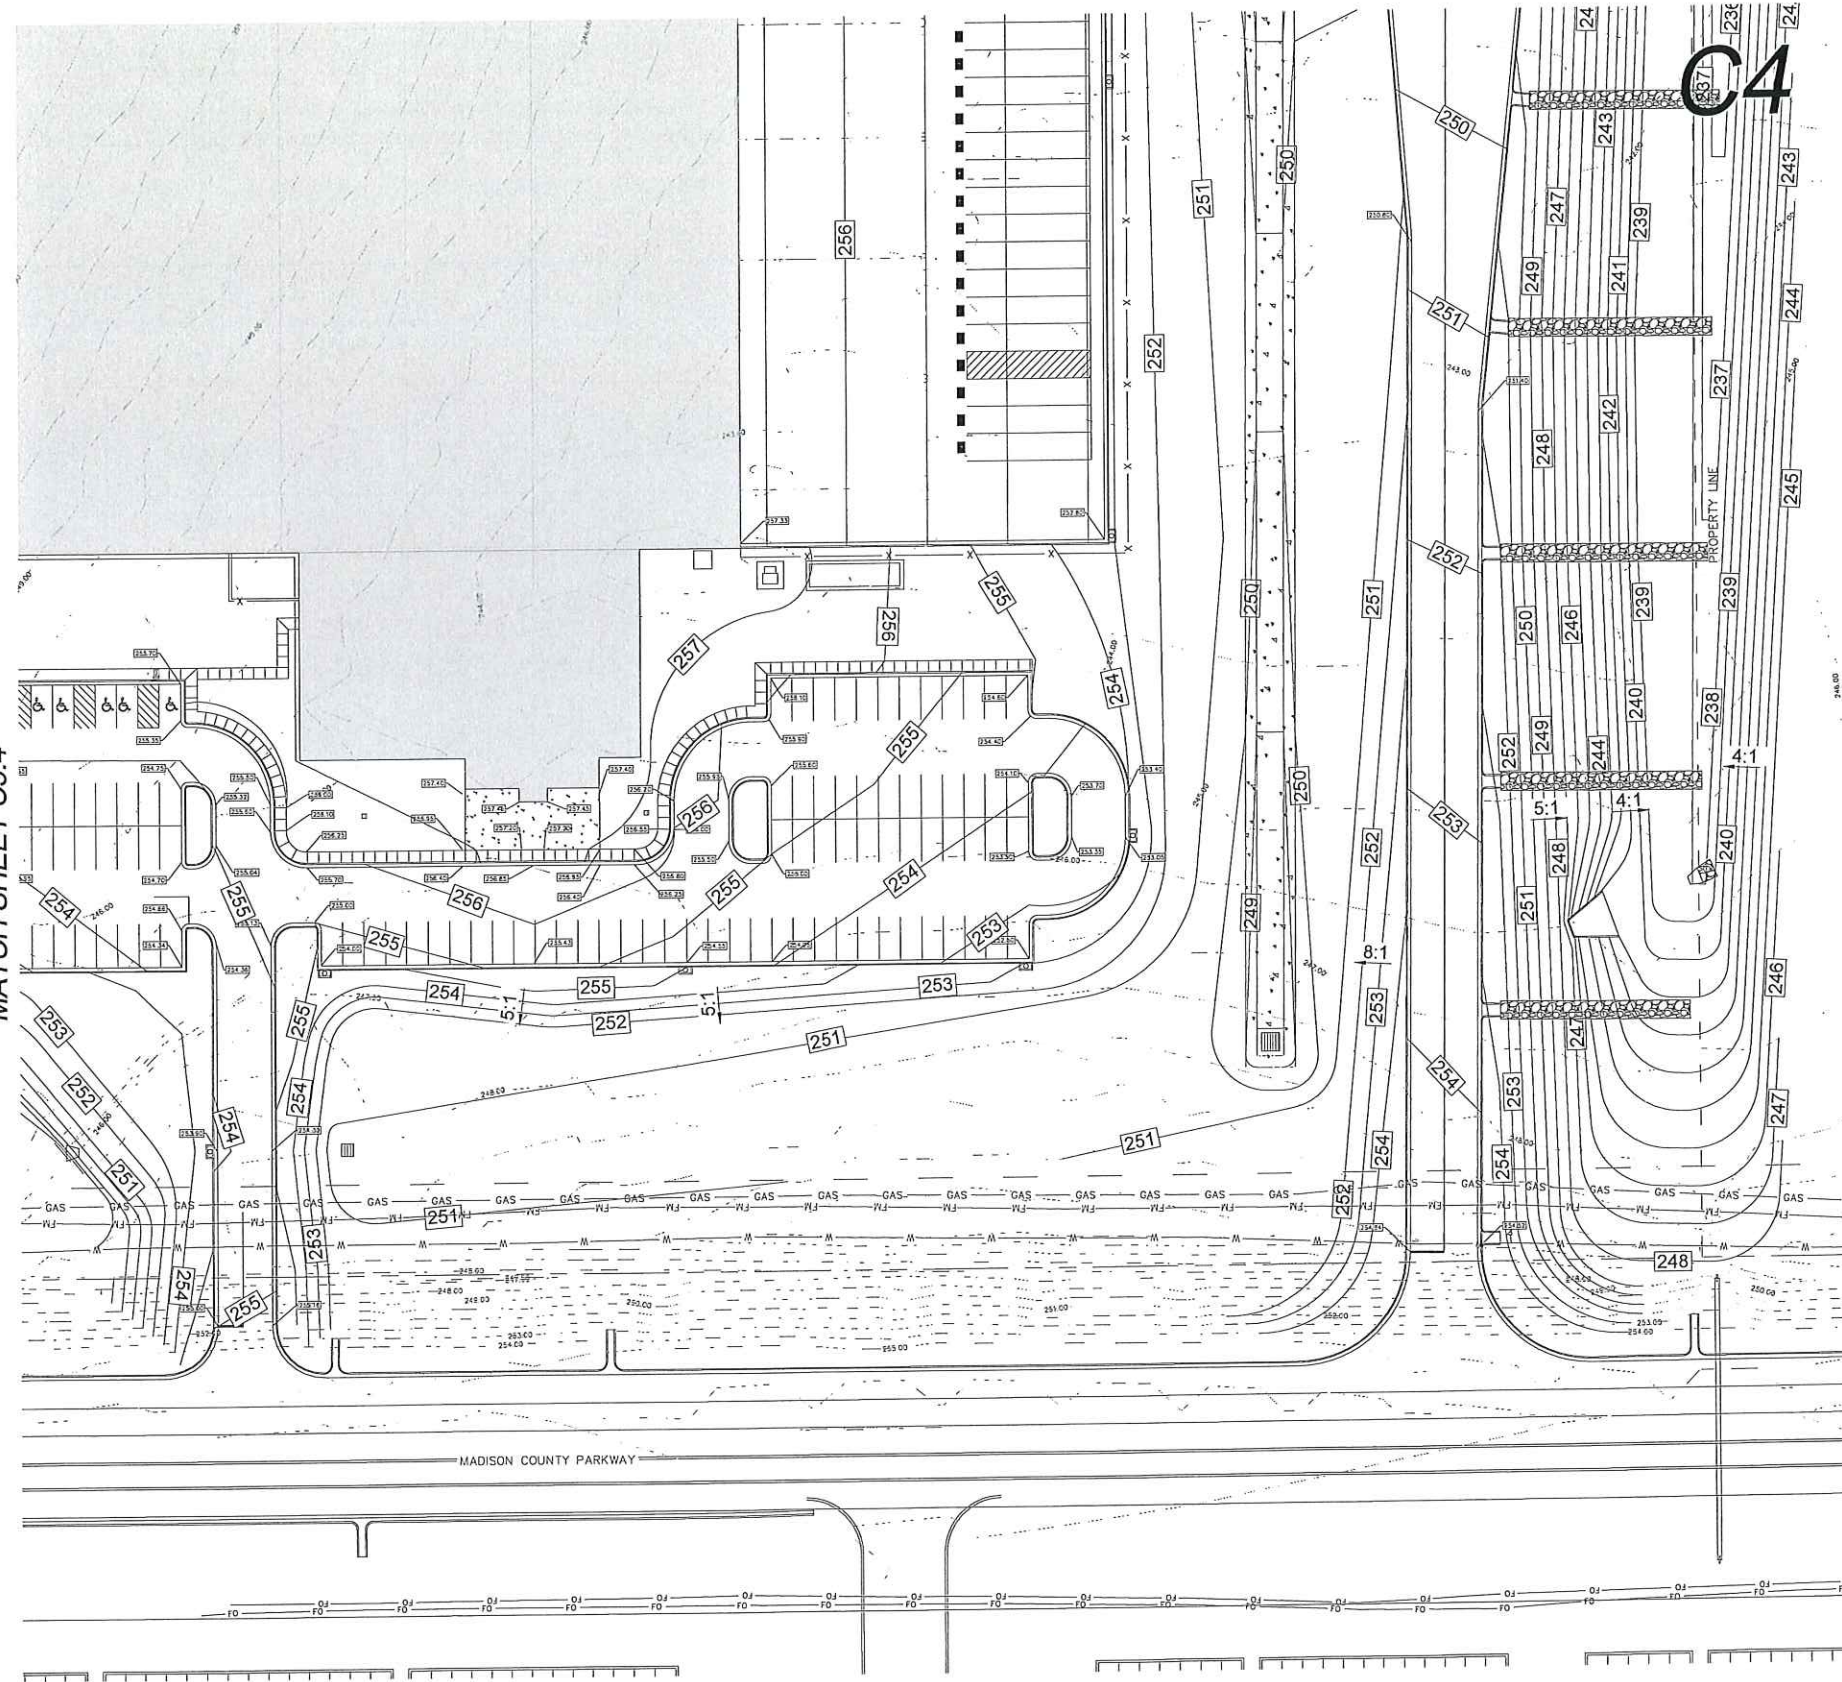

C1	C2
C3	C4

GRID MAP

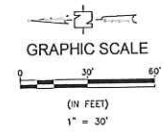

CLARK
BEVERAGE GROUP, INC.
SINCE 1903

CLIENT	CLARK BEVERAGE GROUP, INC. OAKLAND, KY
PROJECT	PROJECT JOY SALES CENTER CANTON, MS
DRAWING TITLE	SITE GRADING & DRAINAGE


PROJECT NO. 2300638
ISSUED: 5-17-2023
SCALE: AS NOTED
DRAWN BY: WLC
DRAWING NO.

DRAWING NO.
C3.5



Design Group
 DG ARCHITECTURAL AND ENGINEERING FACILITY SOLUTIONS, PLLC
 1075 WINDWARD RIDGE PKWY, STE 100, ALPHARETTA, GA 30005



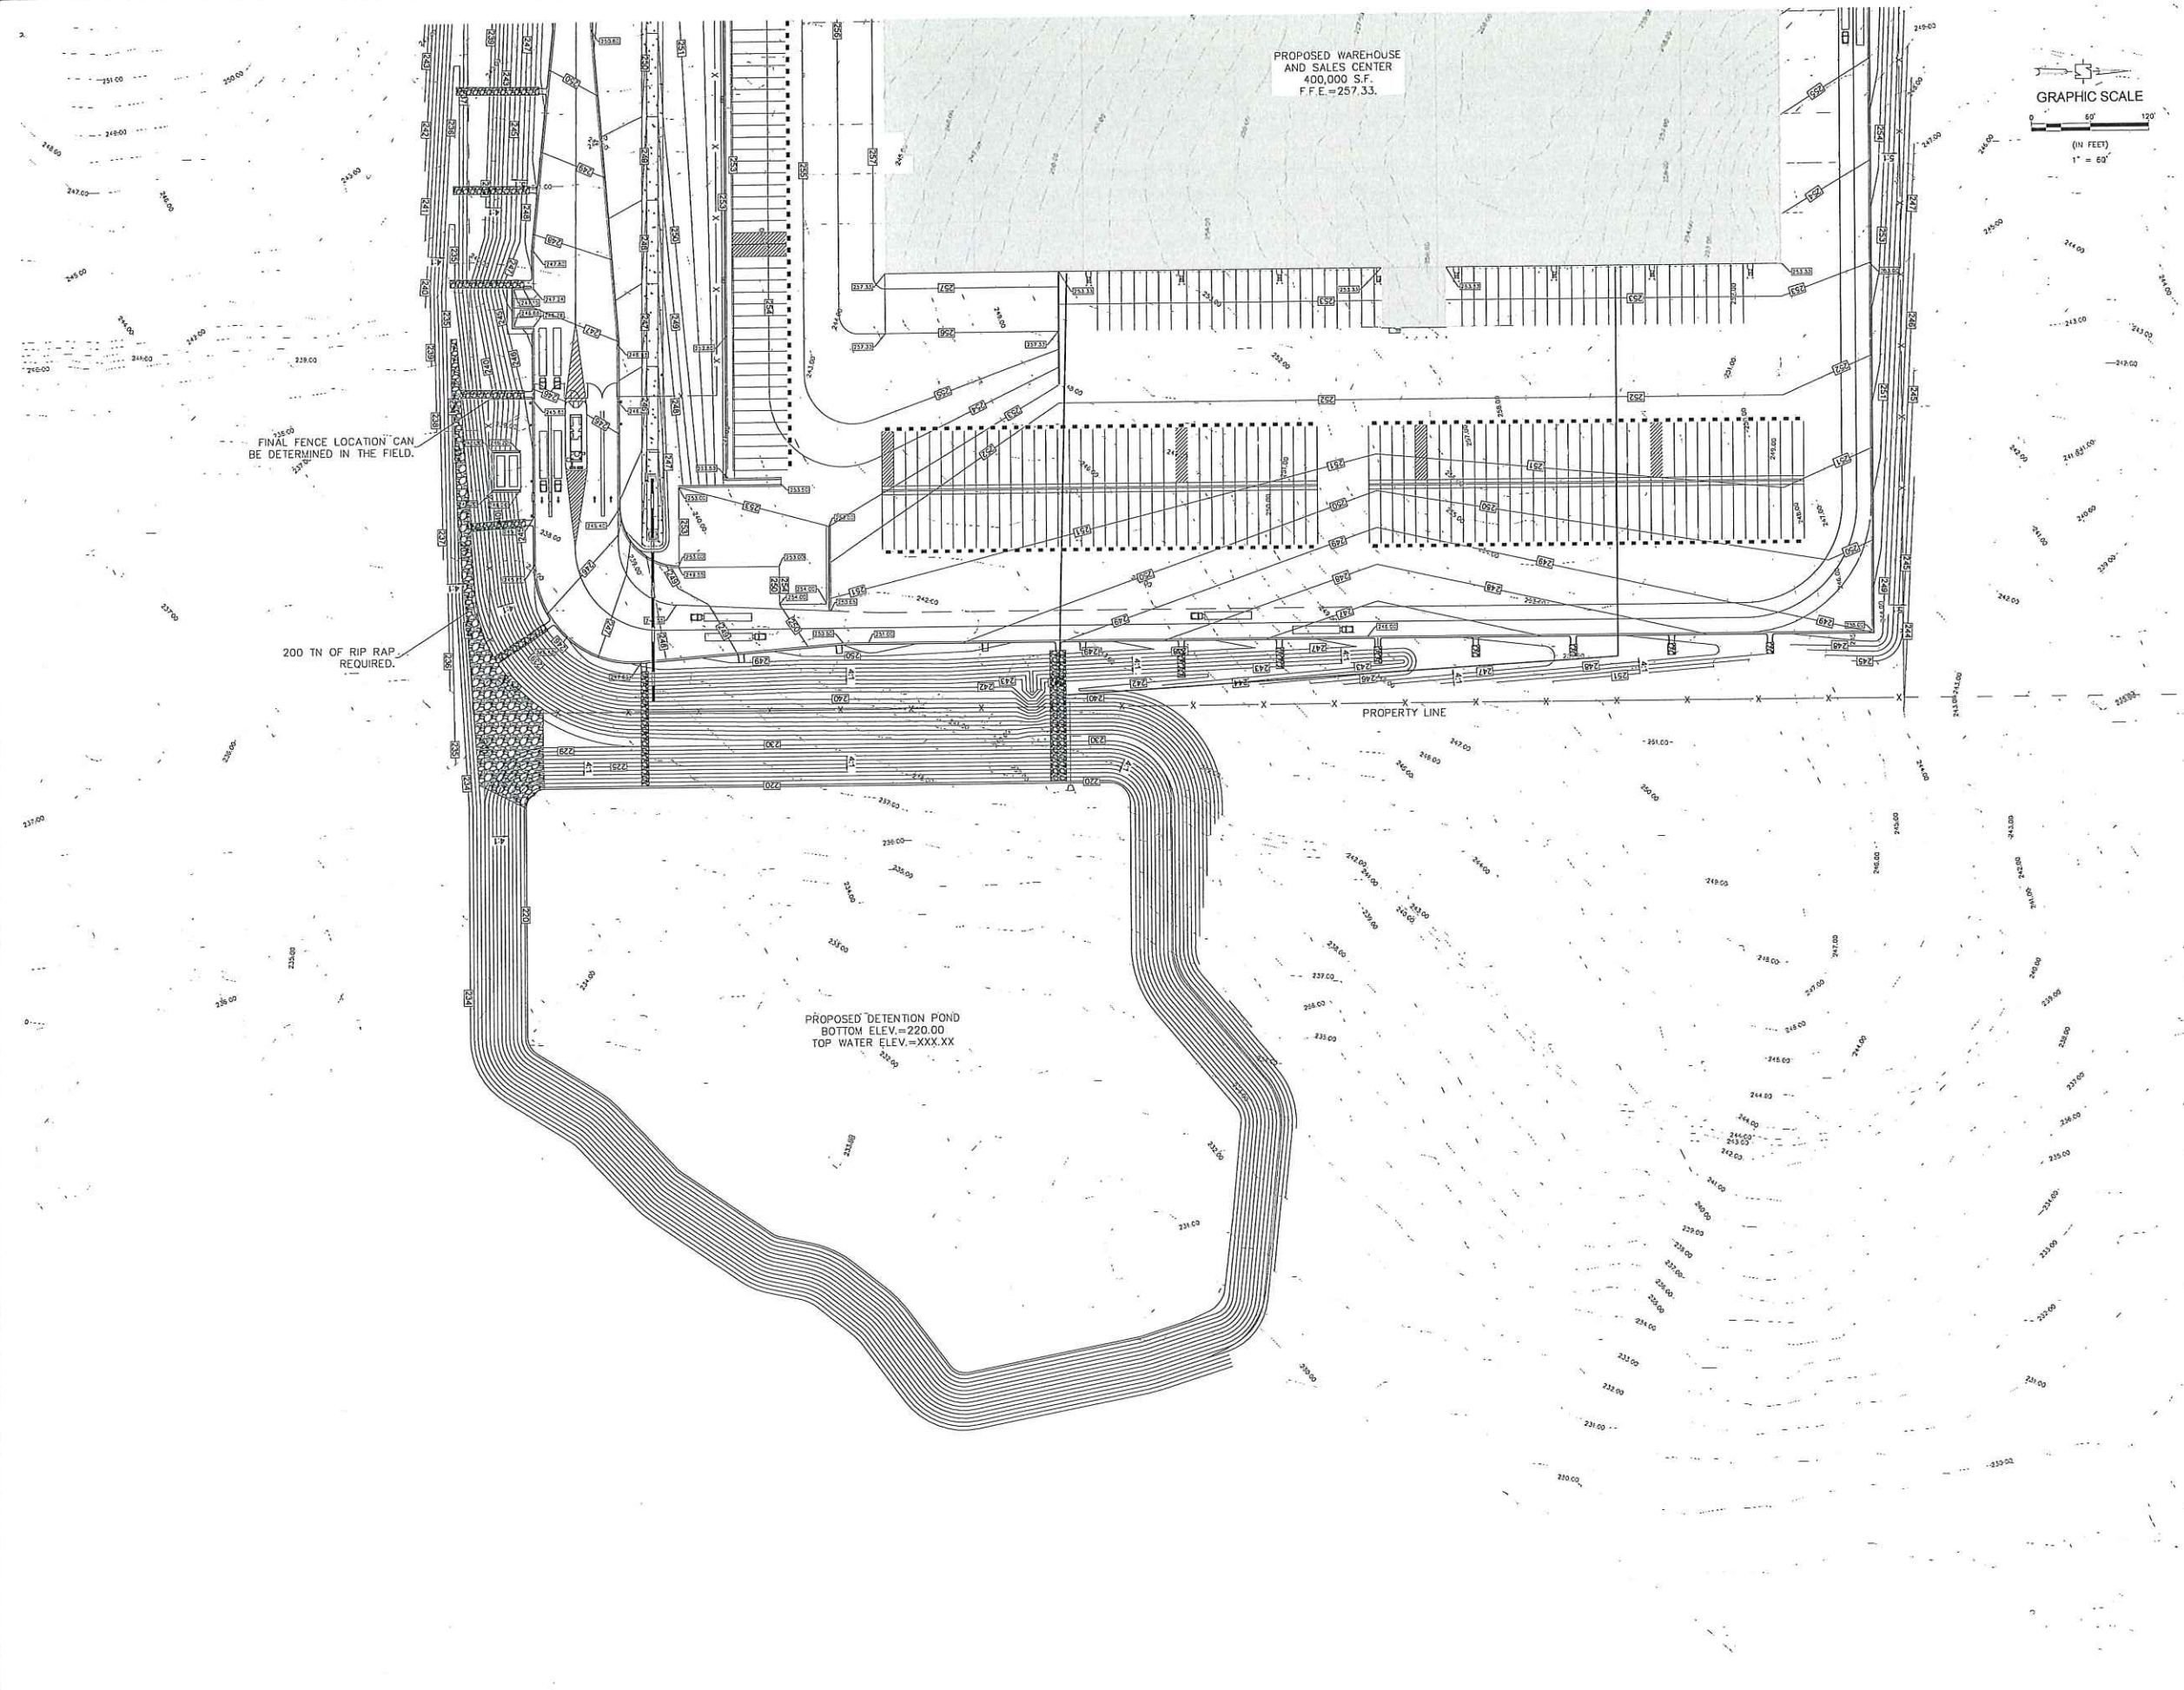

Design Group
DG ARCHITECTURAL AND ENGINEERING FACILITY SOLUTIONS, PLLC
3075 WINDWARD RIDGE PKWY, STE 100, ALPHARETTA, GA 30005
PHONE: (770) 667-4334 FAX: (770) 667-4331


REVISION	DATE	BY	ISSUED FOR BID
1	5/17/23	WLC	



CLARK BEVERAGE GROUP, INC.
OAKLAND, KY
PROJECT JOY SALES CENTER
CANTON, MS
DRAWING TITLE
SITE GRADING & DRAINAGE


PROJECT NO. 2300638
ISSUED: 5-17-2023
SCALE: AS NOTED
DRAWN BY: WLC
DRAWING NO.
C3.6

16' A

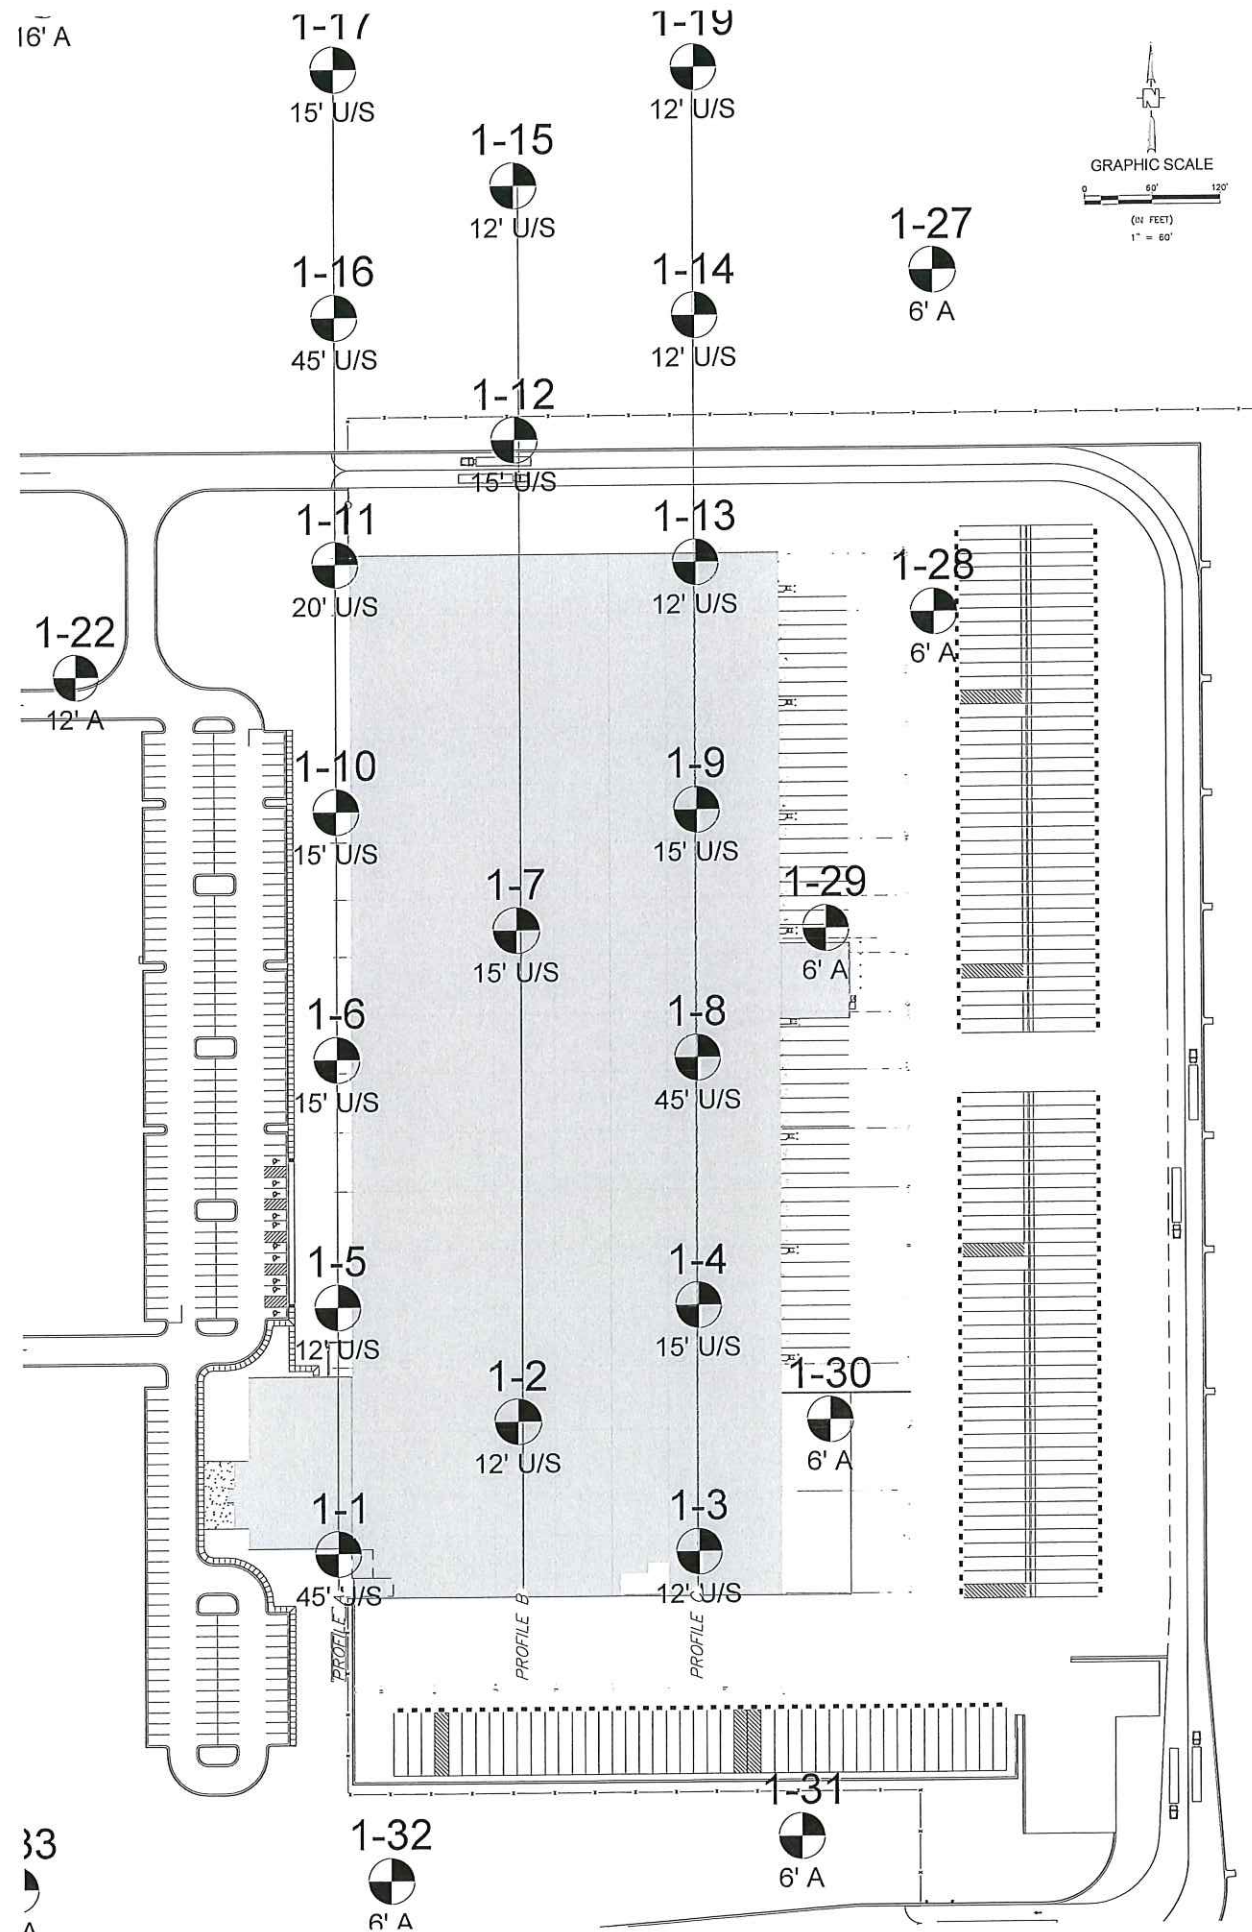


NOTE: ALL MATERIAL AFTER STRIPPING OF TOPSOIL AND ABOVE THE CH (YAZOO CLAY) MAY NOT BE USED IN THE CONSTRUCTION OF THE BUILDING PAD AND OR PARKING PADS AND ACCESS DRIVES. ALL UNDERCUT (CH) MUST BE REMOVED FROM THE BUILDING PAD WITHIN THE 10 FT REQUIRED CL BUFFER ZONE. CH MAY BE DISPOSED OF WITHIN THE LIMITS OF THE DETENTION BASIN SPREAD IN THIN LIFTS AND OR AS APPROVED BY THE CM AND ENGINEER


PROFILE A-NTS

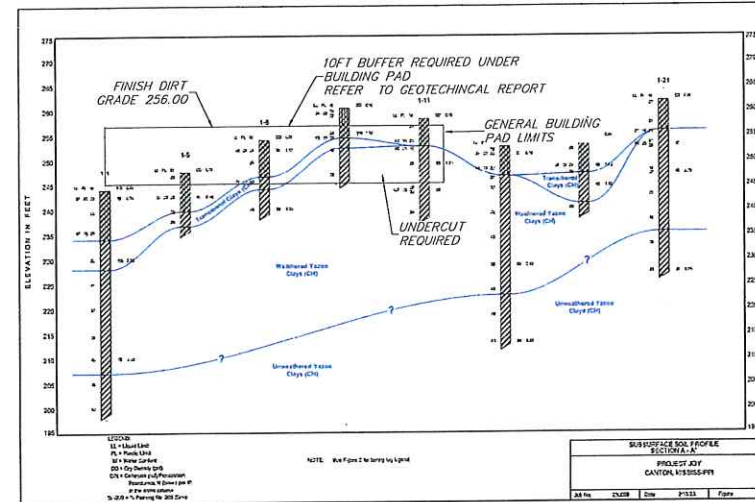

PROFILE B-NTS

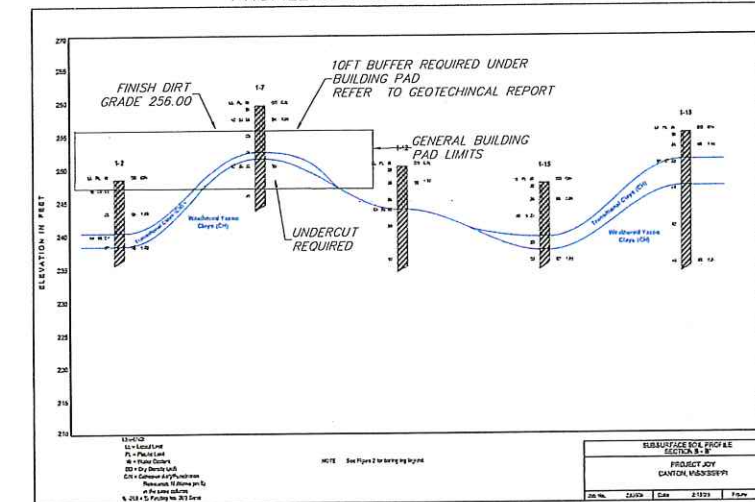

PROFILE C-NTS

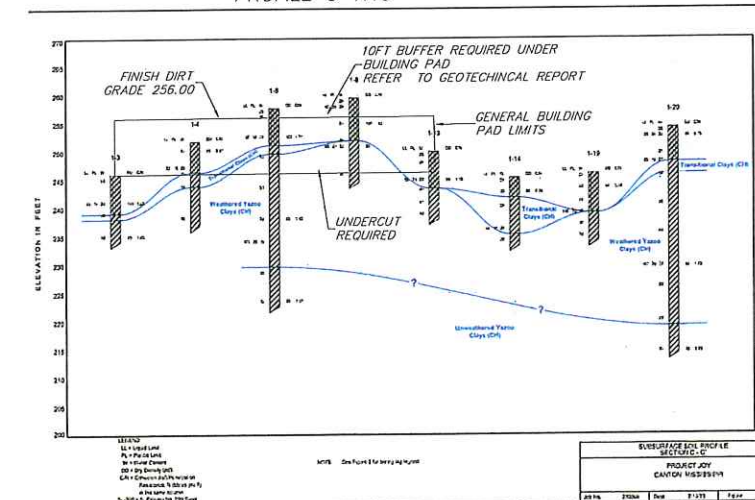

Civil Link
Connecting Resources

Design Group
DG ARCHITECTURAL AND ENGINEERING FACILITY SOLUTIONS, PLLC
105 WOODWARD ROAD, SUITE 200, ALPHARETTA, GA 30005
PHONE: (770) 460-4200 FAX: (770) 460-4252

REVISION	DATE	BY	WLC
1	01/17/23		

CLARK BEVERAGE GROUP, INC.
SINCE 1903
BEVERAGE GROUP, INC.



CLIENT: CLARK BEVERAGE GROUP, INC.
PROJECT: PROJECT JOY SALES CENTER
CANTON, MS
DRAWING TITLE: SITE GRADING & DRAINAGE



PROJECT NO. 2300658
ISSUED: 5-17-2023
SCALE: AS NOTED
DRAWN BY: WLC
DRAWING NO.

C3.7

33

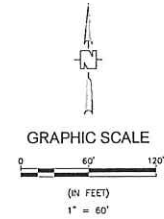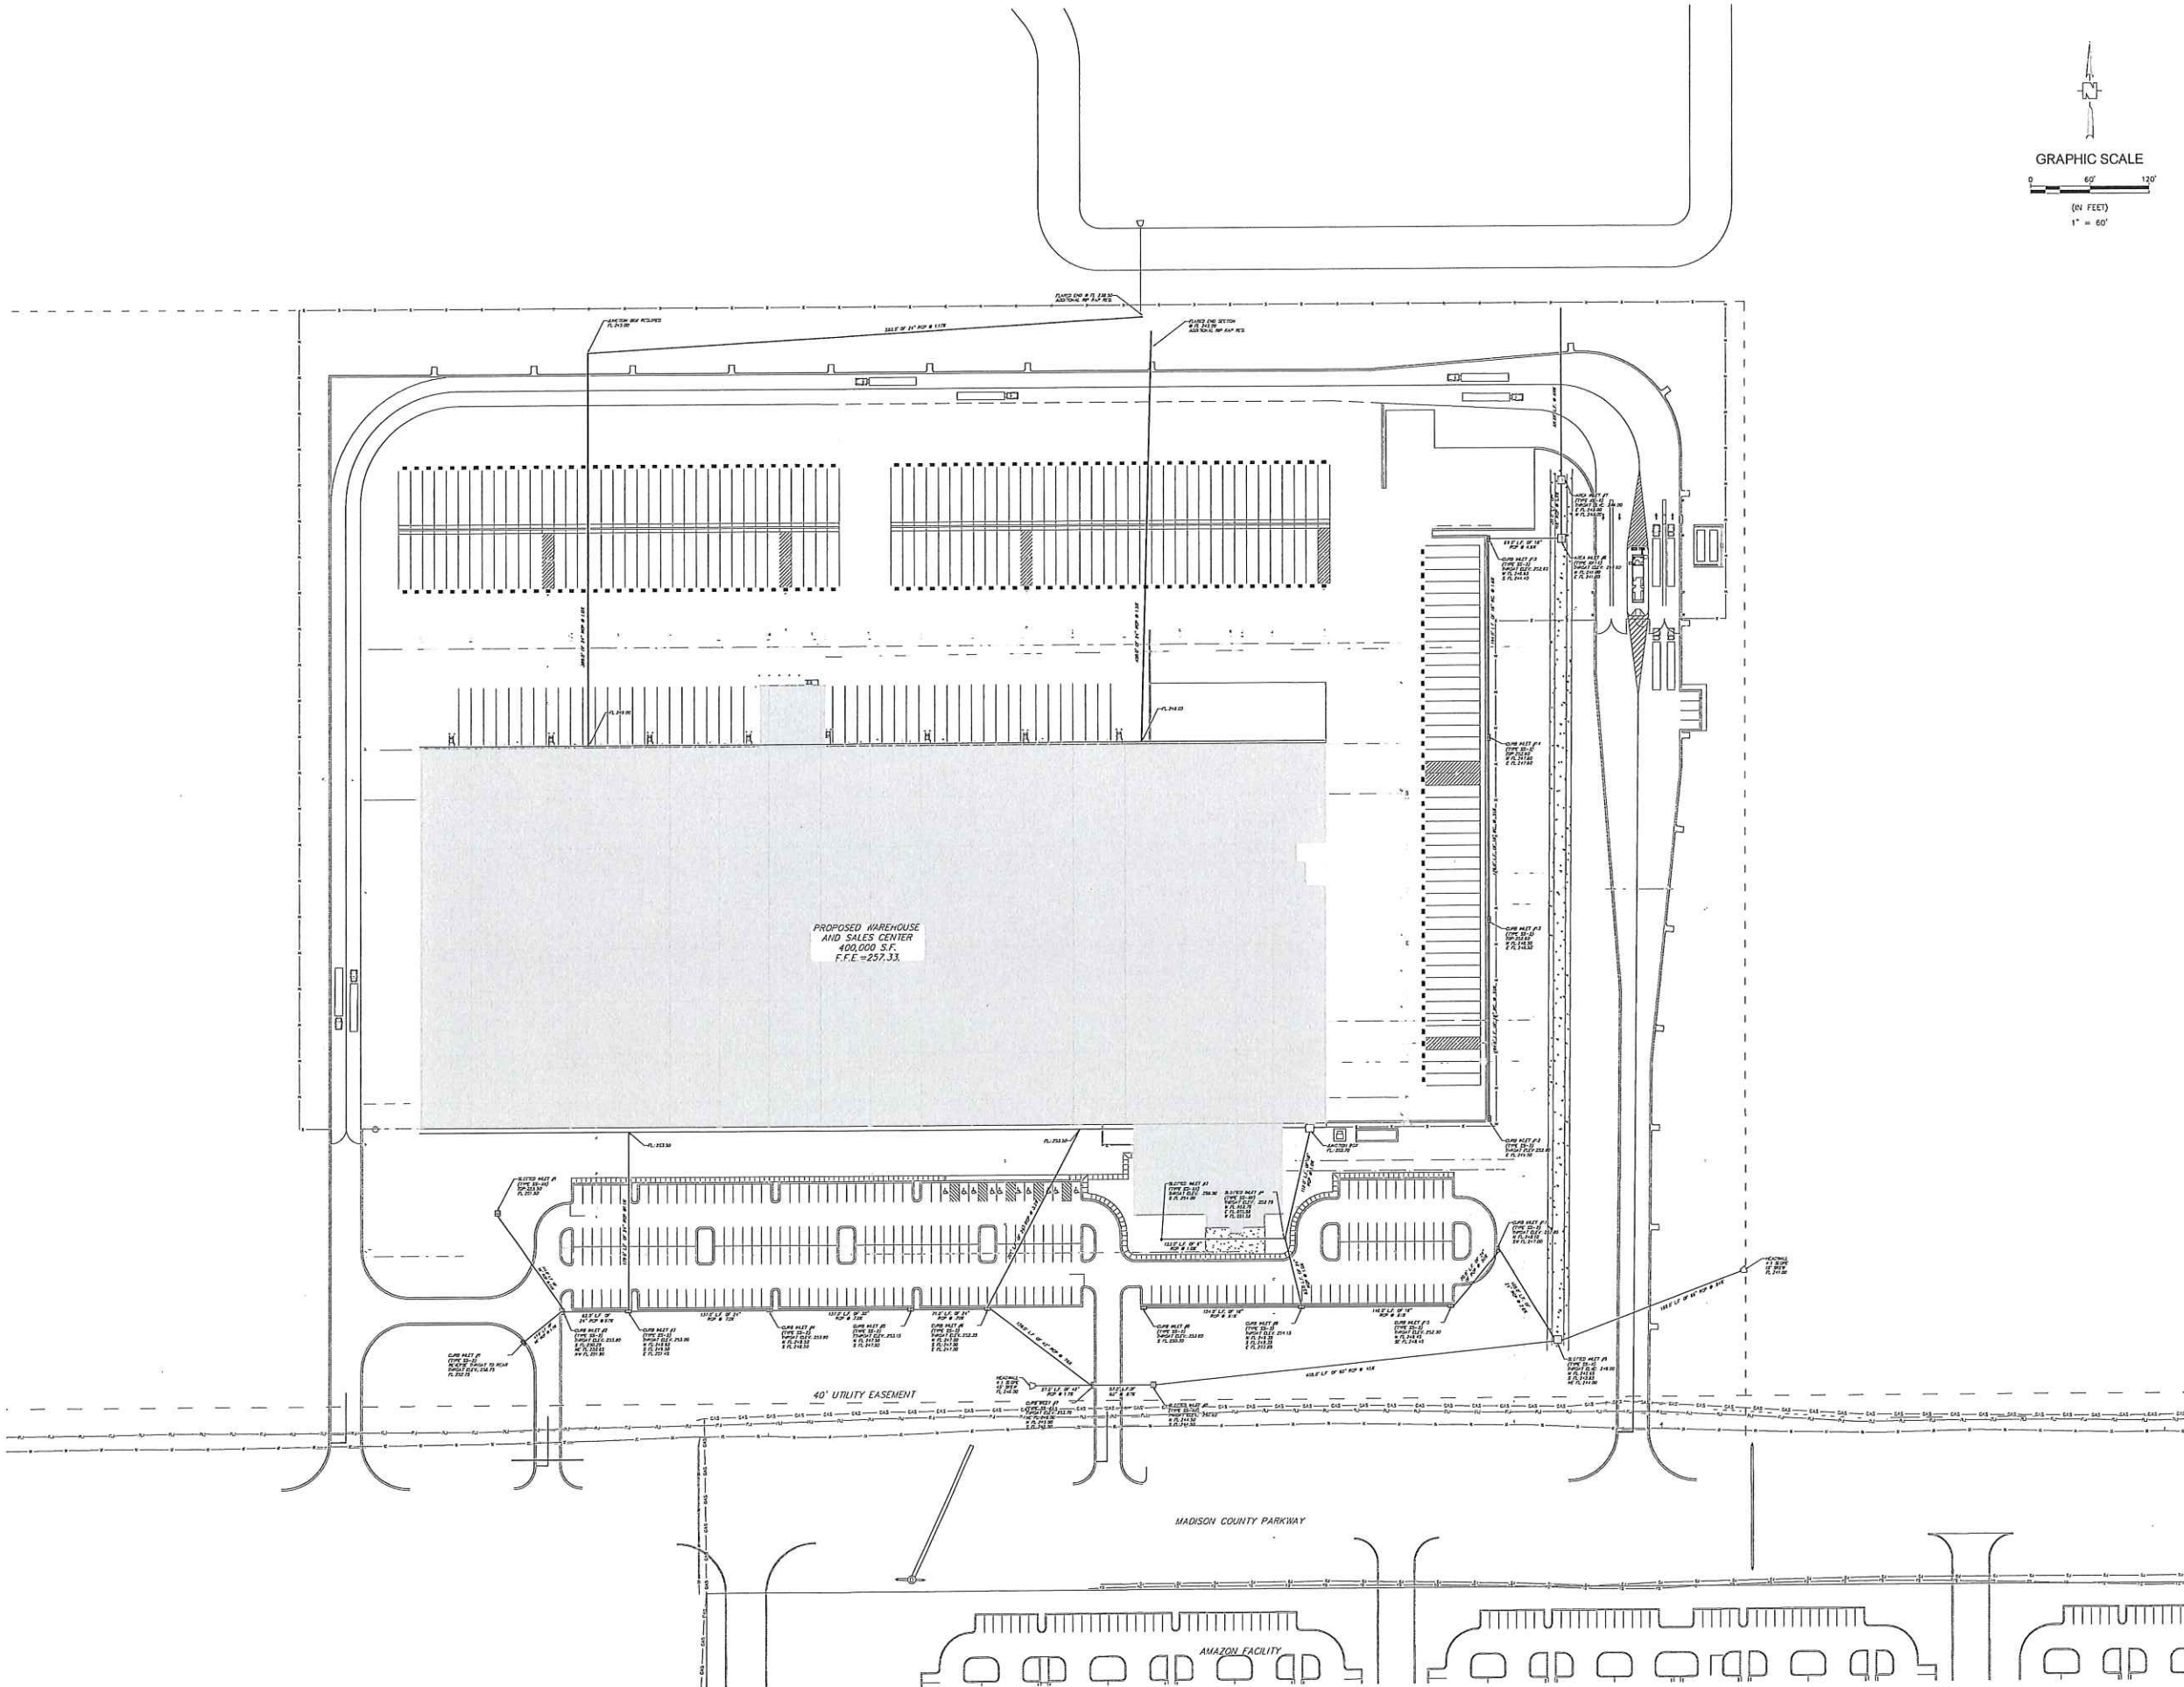

Design Group
DG ARCHITECTURAL AND ENGINEERING FACILITY SOLUTIONS, PLLC
105 WINDWARD RIDGE PARK, STE 100, ASPEN, CO 80520
PHONE: (770) 667-6200 FAX: (770) 667-6201


REVISION	DATE	BY	ISSUED FOR BID
0	5/17/23	WLC	




CLIENT: CLARK BEVERAGE GROUP, INC.
PROJECT: PROJECT JOY SALES CENTER
DRAWING TITLE: GRADING AND DRAINAGE LAYOUT

PROJECT NO: 2300638
ISSUED: 5-17-2023
SCALE: AS NOTED
DRAWN BY: WLC
DRAWING NO: **C3.8**


Alignment - (9) PROFILE

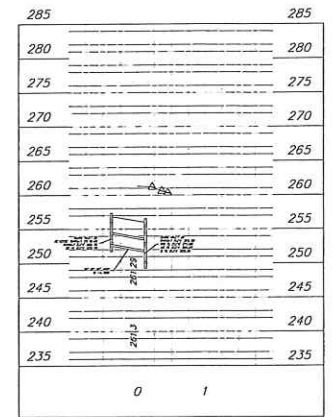



ALIGNMENT- PARKING LOT FRONT PROFILE

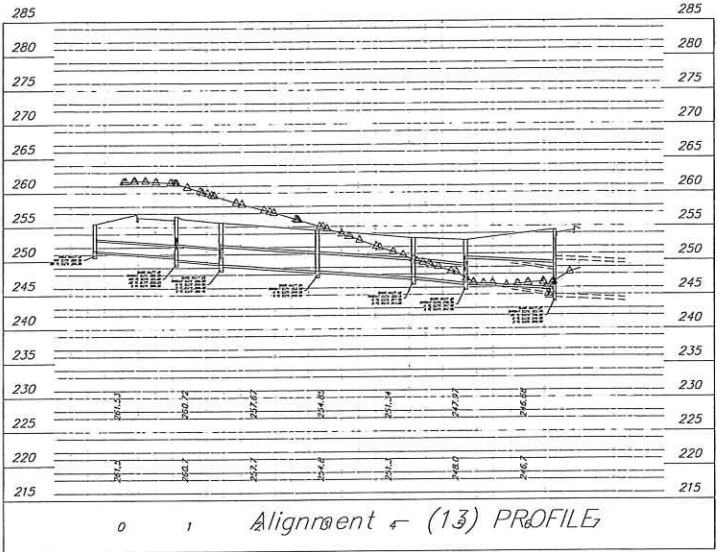


Alignment - ADJACENT TO STREET PROFILE

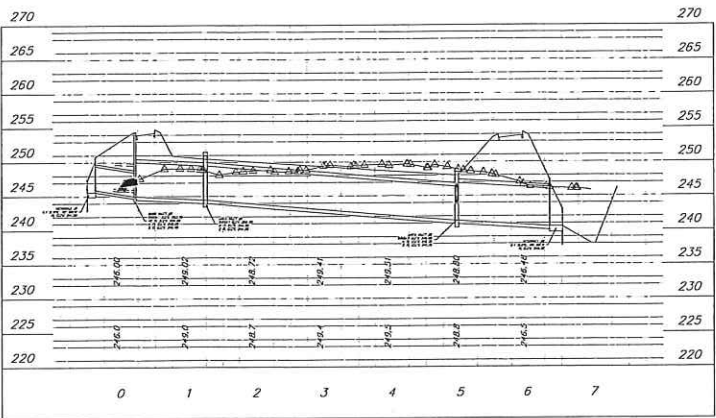


t- ADJACENT TO PARKING LOT ON SOUTH SIDE PROFILE

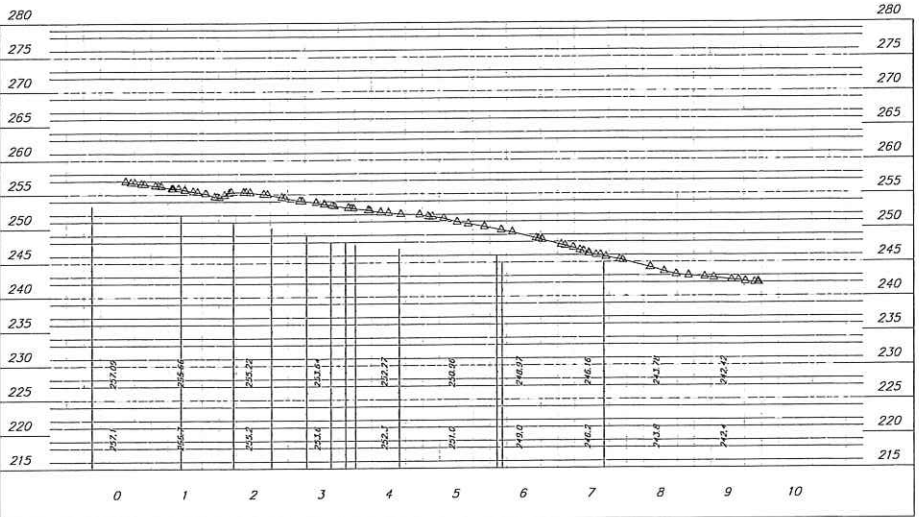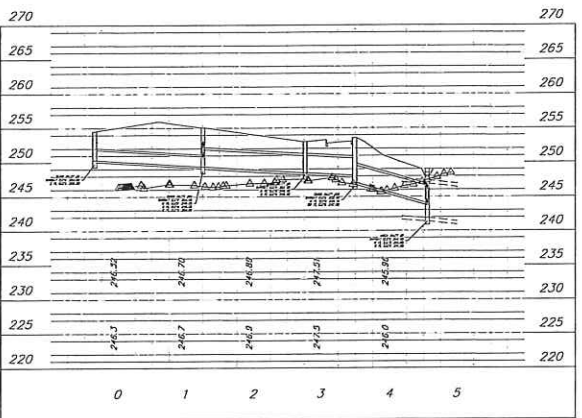


Alignment - (14) PROFILE

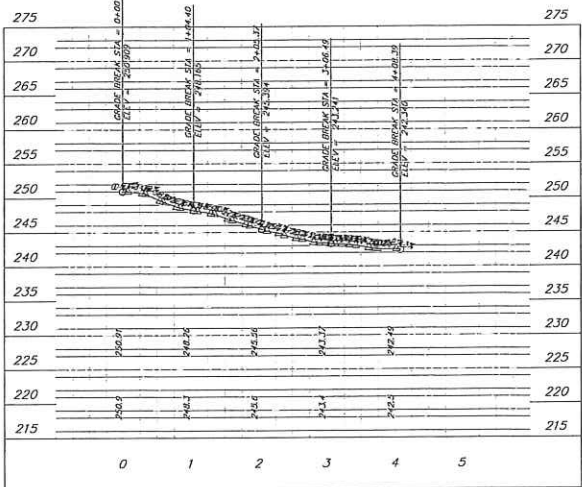


Alignment -ADJACENT TO TRUCKING ENTRANCE PROFILE

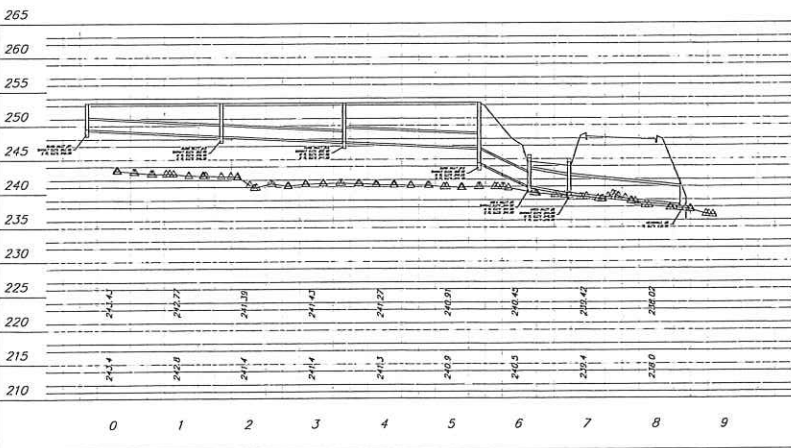


Alignment - (15) PROFILE

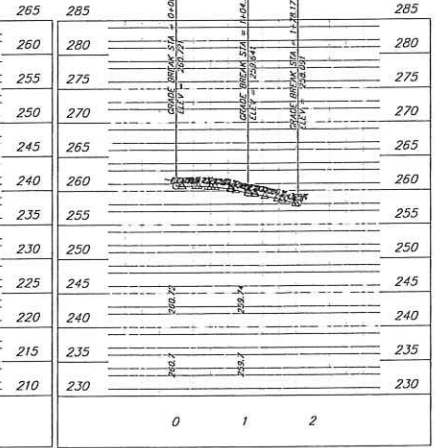



Alignment - (16) PROFILE

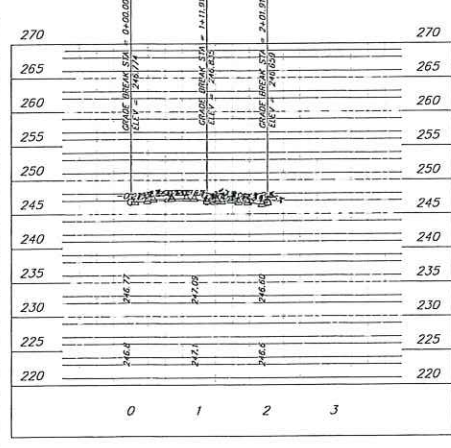

Alignment - (10) PROFILE

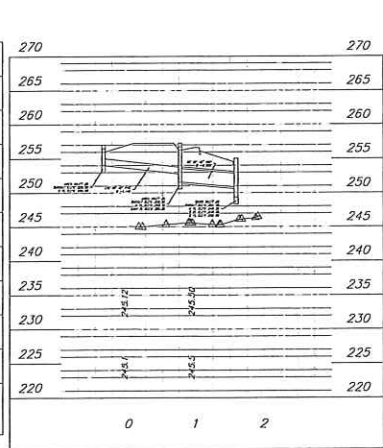

Alignment - (11) PROFILE

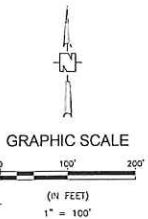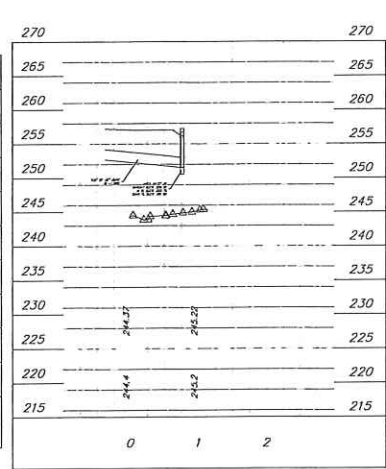




REVISION	DATE	BY	W.C.
0	5/17/23		




CLIENT	CLARK BEVERAGE GROUP, INC.
PROJECT	PROJECT JOY SALES CENTER
DRAWING NO.	CANTON, MS
TITLE	SITE GRADING & DRAINAGE

PROJECT NO. 2300538
ISSUED 5-17-2023
SCALE AS NOTED
DRAWN BY: WLC
CHECKED BY: WLC
DATE PLOTTED: 5/18/2023 8:38:35 PM


C3.9

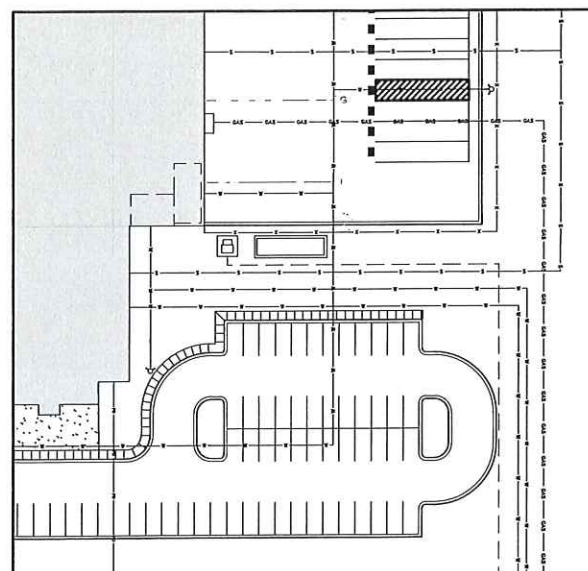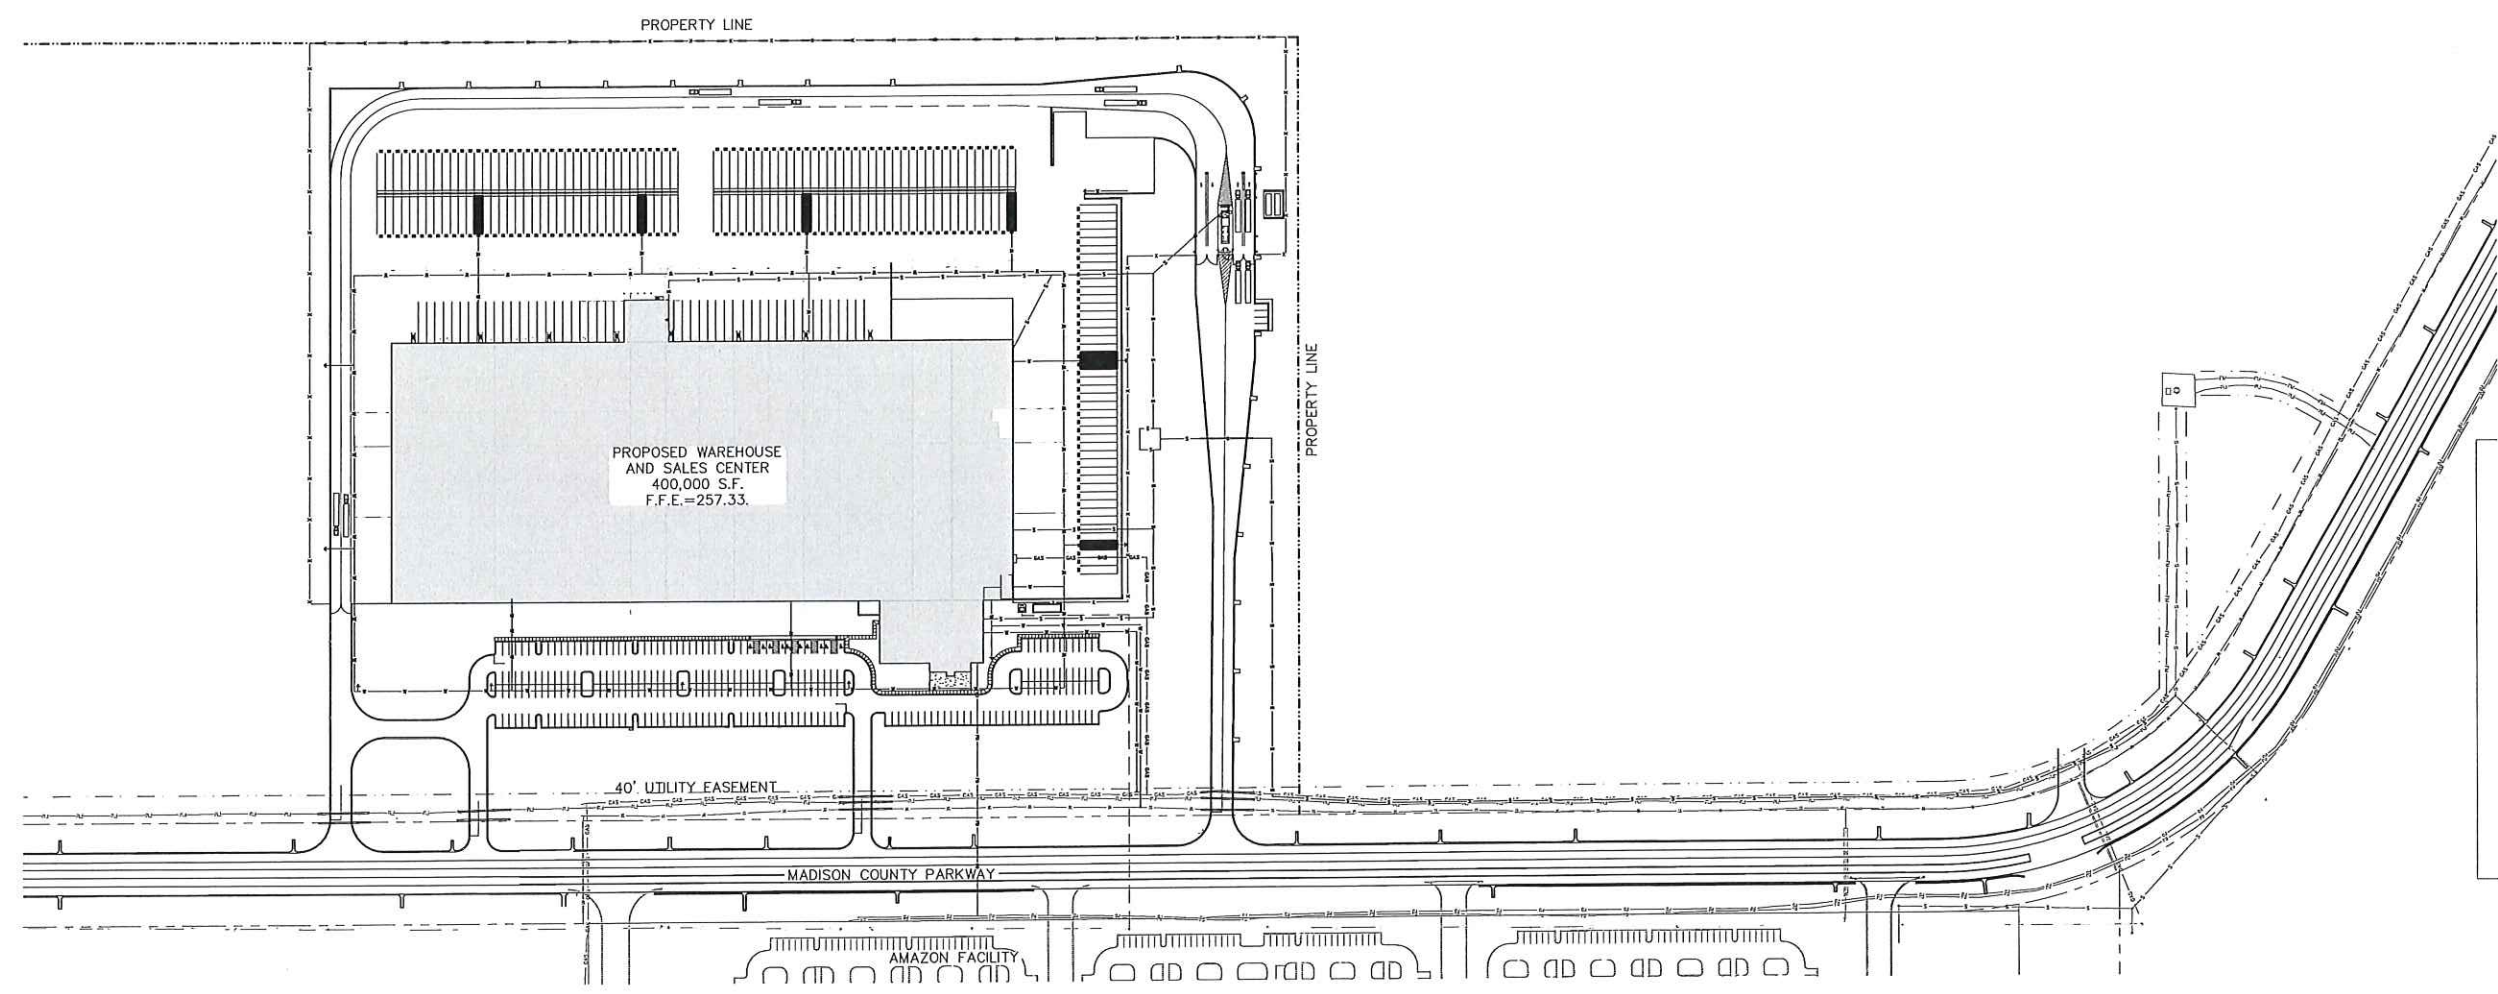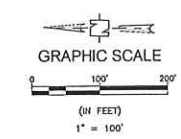

SCALE= 1"=40'

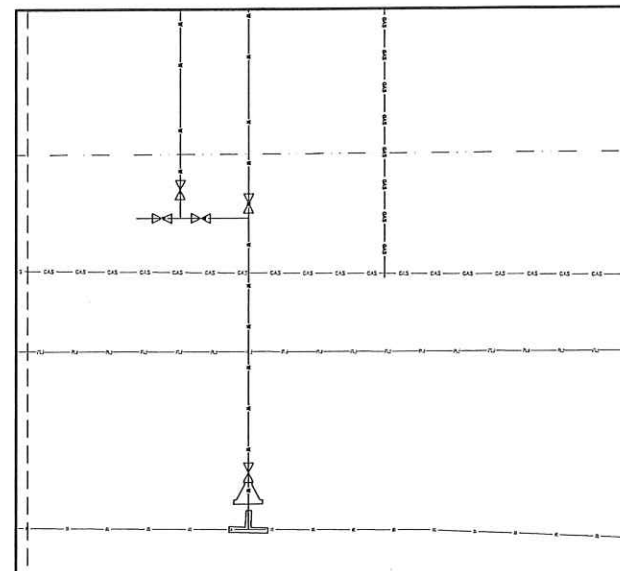

SCALE= 1"=5'

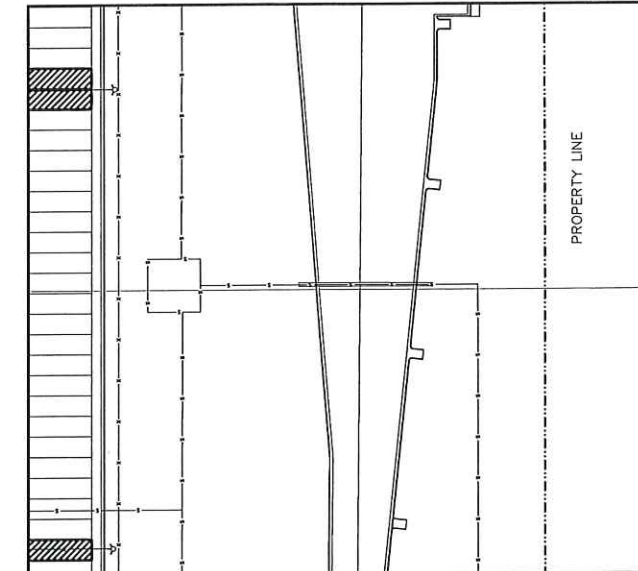

SCALE= 1"=40'





Design Group
DG ARCHITECTURAL AND ENGINEERING FACILITY SOLUTIONS, PLLC
1075 WINDWARD RIDGE HWY., STE 100, ASPEN, CO 80520
PH: (970) 926-5241 FAX: (970) 926-5241




CLIENT: CLARK BEVERAGE GROUP, INC.
OAKLAND, KY
PROJECT: PROJECT JOY SALES CENTER
CANTON, MS
DRAWING TITLE: UTILITY PLAN LAYOUT

PROJECT NO. 2300638
ISSUED: 5-17-2023
SCALE: AS NOTED
DRAWN BY: WLC
DRAWING NO.
C4.0

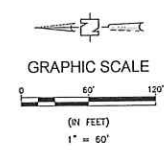
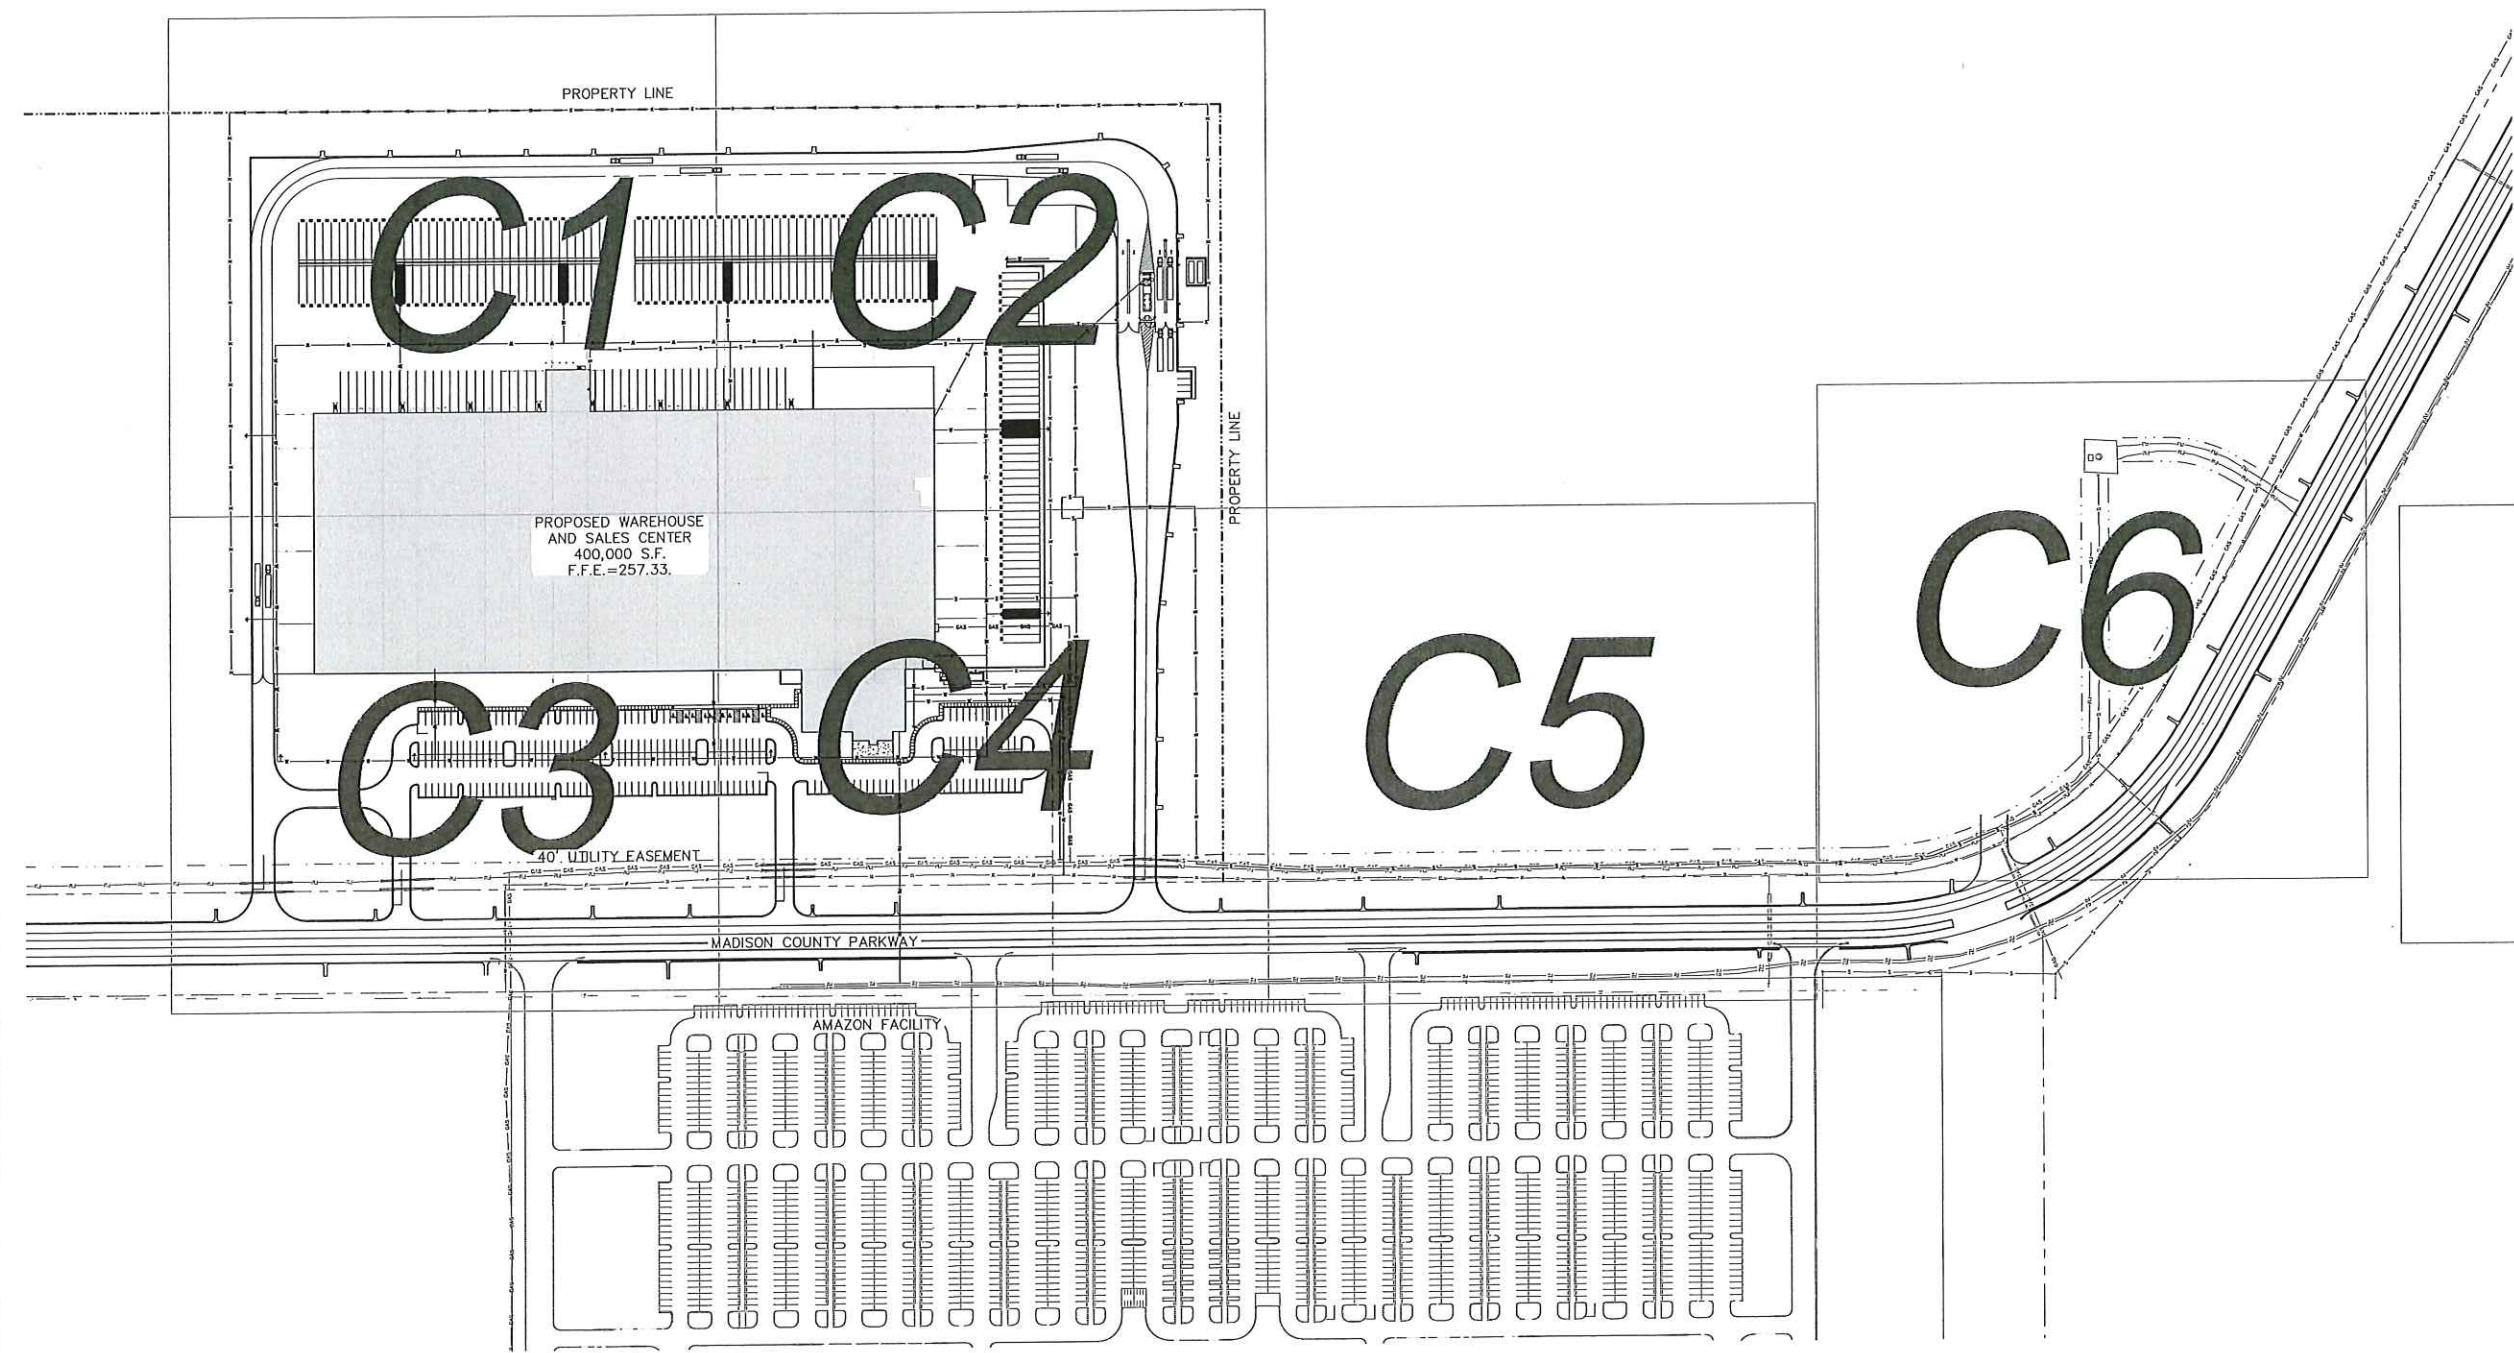


REVISION	DATE	BY	ISSUED FOR BID

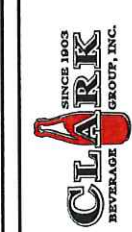

CLIENT	CLARK BEVERAGE GROUP, INC. OAKLAND, KY
PROJECT	PROJECT JOY SALES CENTER CANTON, MS
DRAWING TITLE	UTILITY PLAN LAYOUT

PROJECT NO. 2300634
ISSUED: 5-17-2023
SCALE: AS NOTED
DRAWN BY: WLC
DRAWING NO.
C4.1

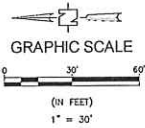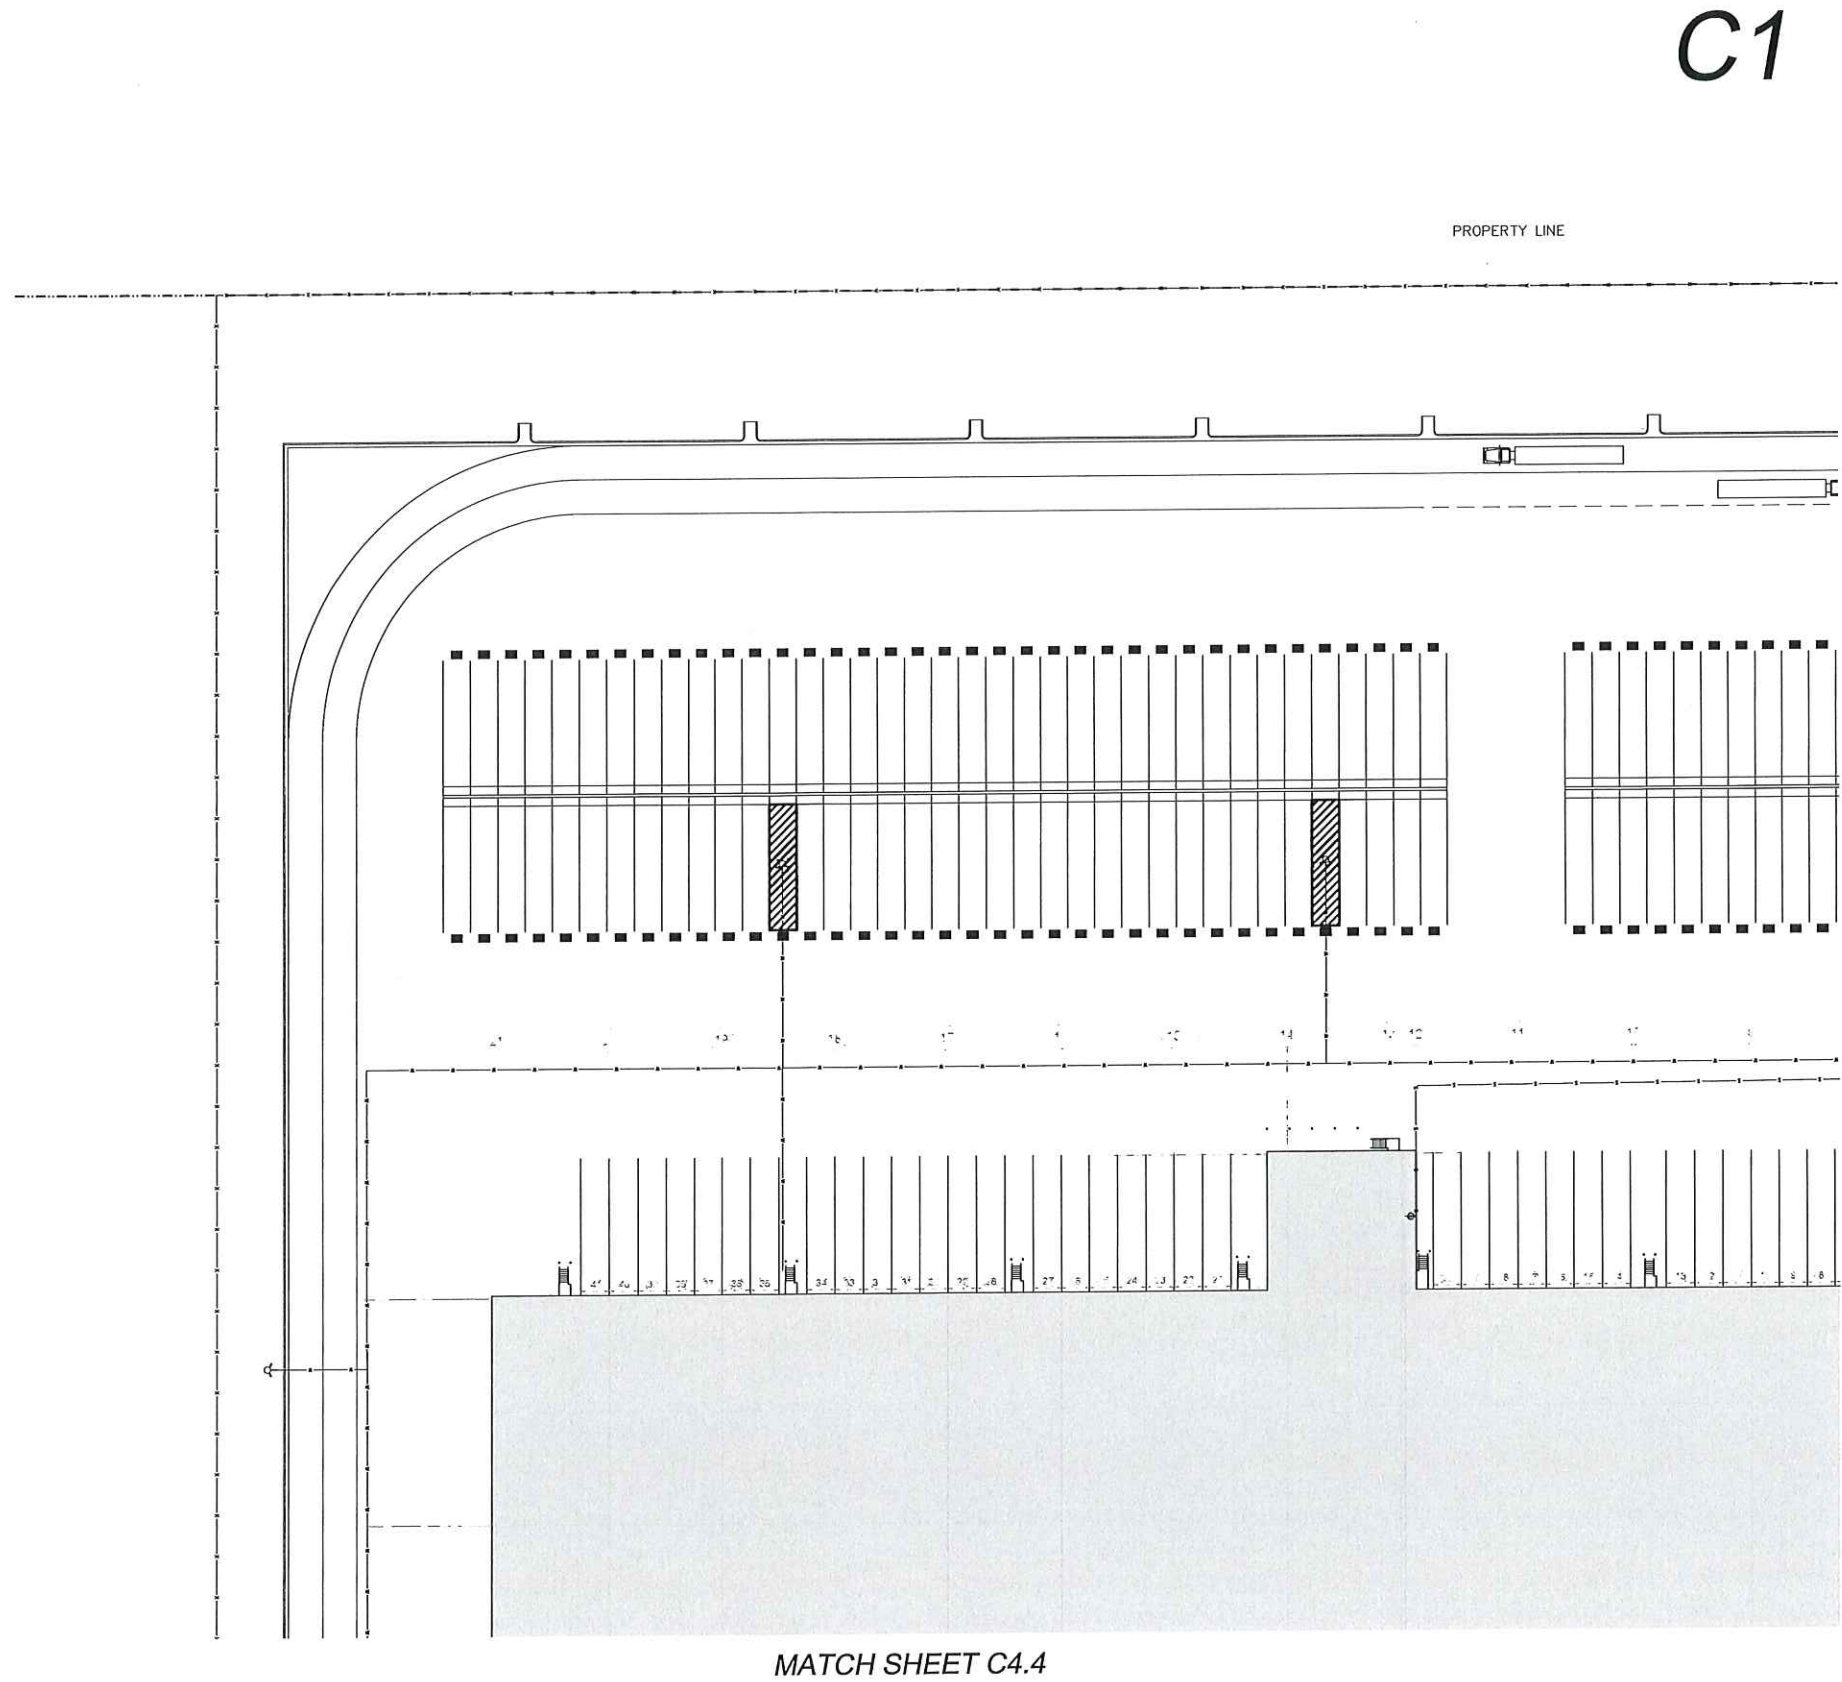

C1 C2
C3 C4
C5 C6
GRID MAP




CLIENT CLARK BEVERAGE GROUP, INC.
OAKLAND, KY
PROJECT PROJECT JOY SALES CENTER
CANTON, MS
DRAWING TITLE UTILITY PLAN LAYOUT

PROJECT NO. 2300638
ISSUED: 5-17-2023
SCALE: AS NOTED
DRAWN BY: VLC
DRAWING NO.

C4.2


MATCH SHEET C4.2

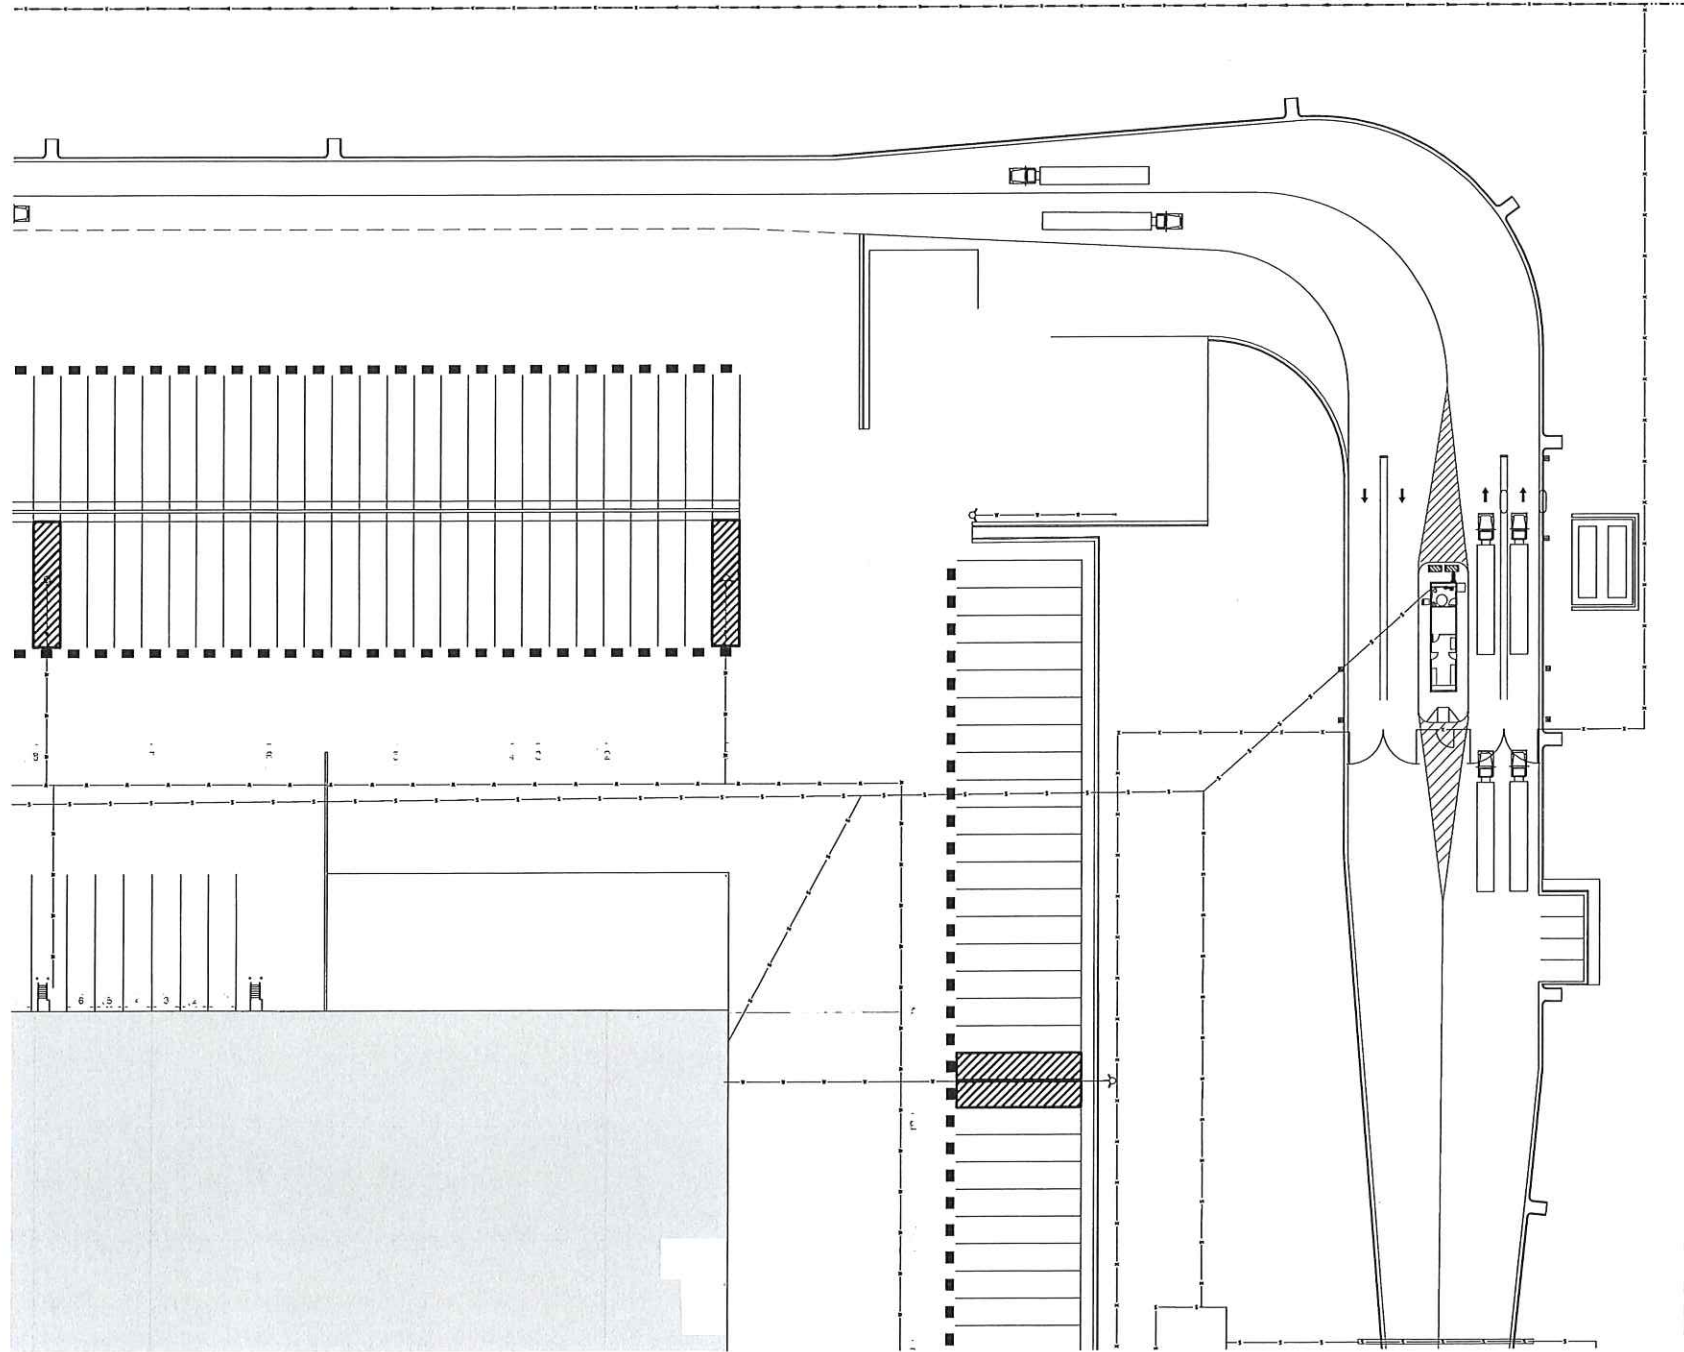

C2

C1C2
C3C4
C5C6

GRID MAP

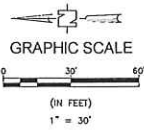

PROJECT NO. 2300638
ISSUED: 5-17-2023
SCALE: AS NOTED
DRAWN BY: V.L.C.
DRAWING NO.

C4.3


CLIENT CLARK BEVERAGE GROUP, INC.
OAKLAND, KY
PROJECT PROJECT JOY SALES CENTER
CANTON, MS
DRAWING TITLE UTILITY PLAN LAYOUT



Design Group
DG ARCHITECTURAL AND ENGINEERING FACILITY SOLUTIONS, PLLC
3075 WINDWARD RIDGE PKWY, STE 100, ALPHARETTA, GA 30005
PHONE: (770) 667-4251 FAX: (770) 667-4251




MATCH SHEET C4.4

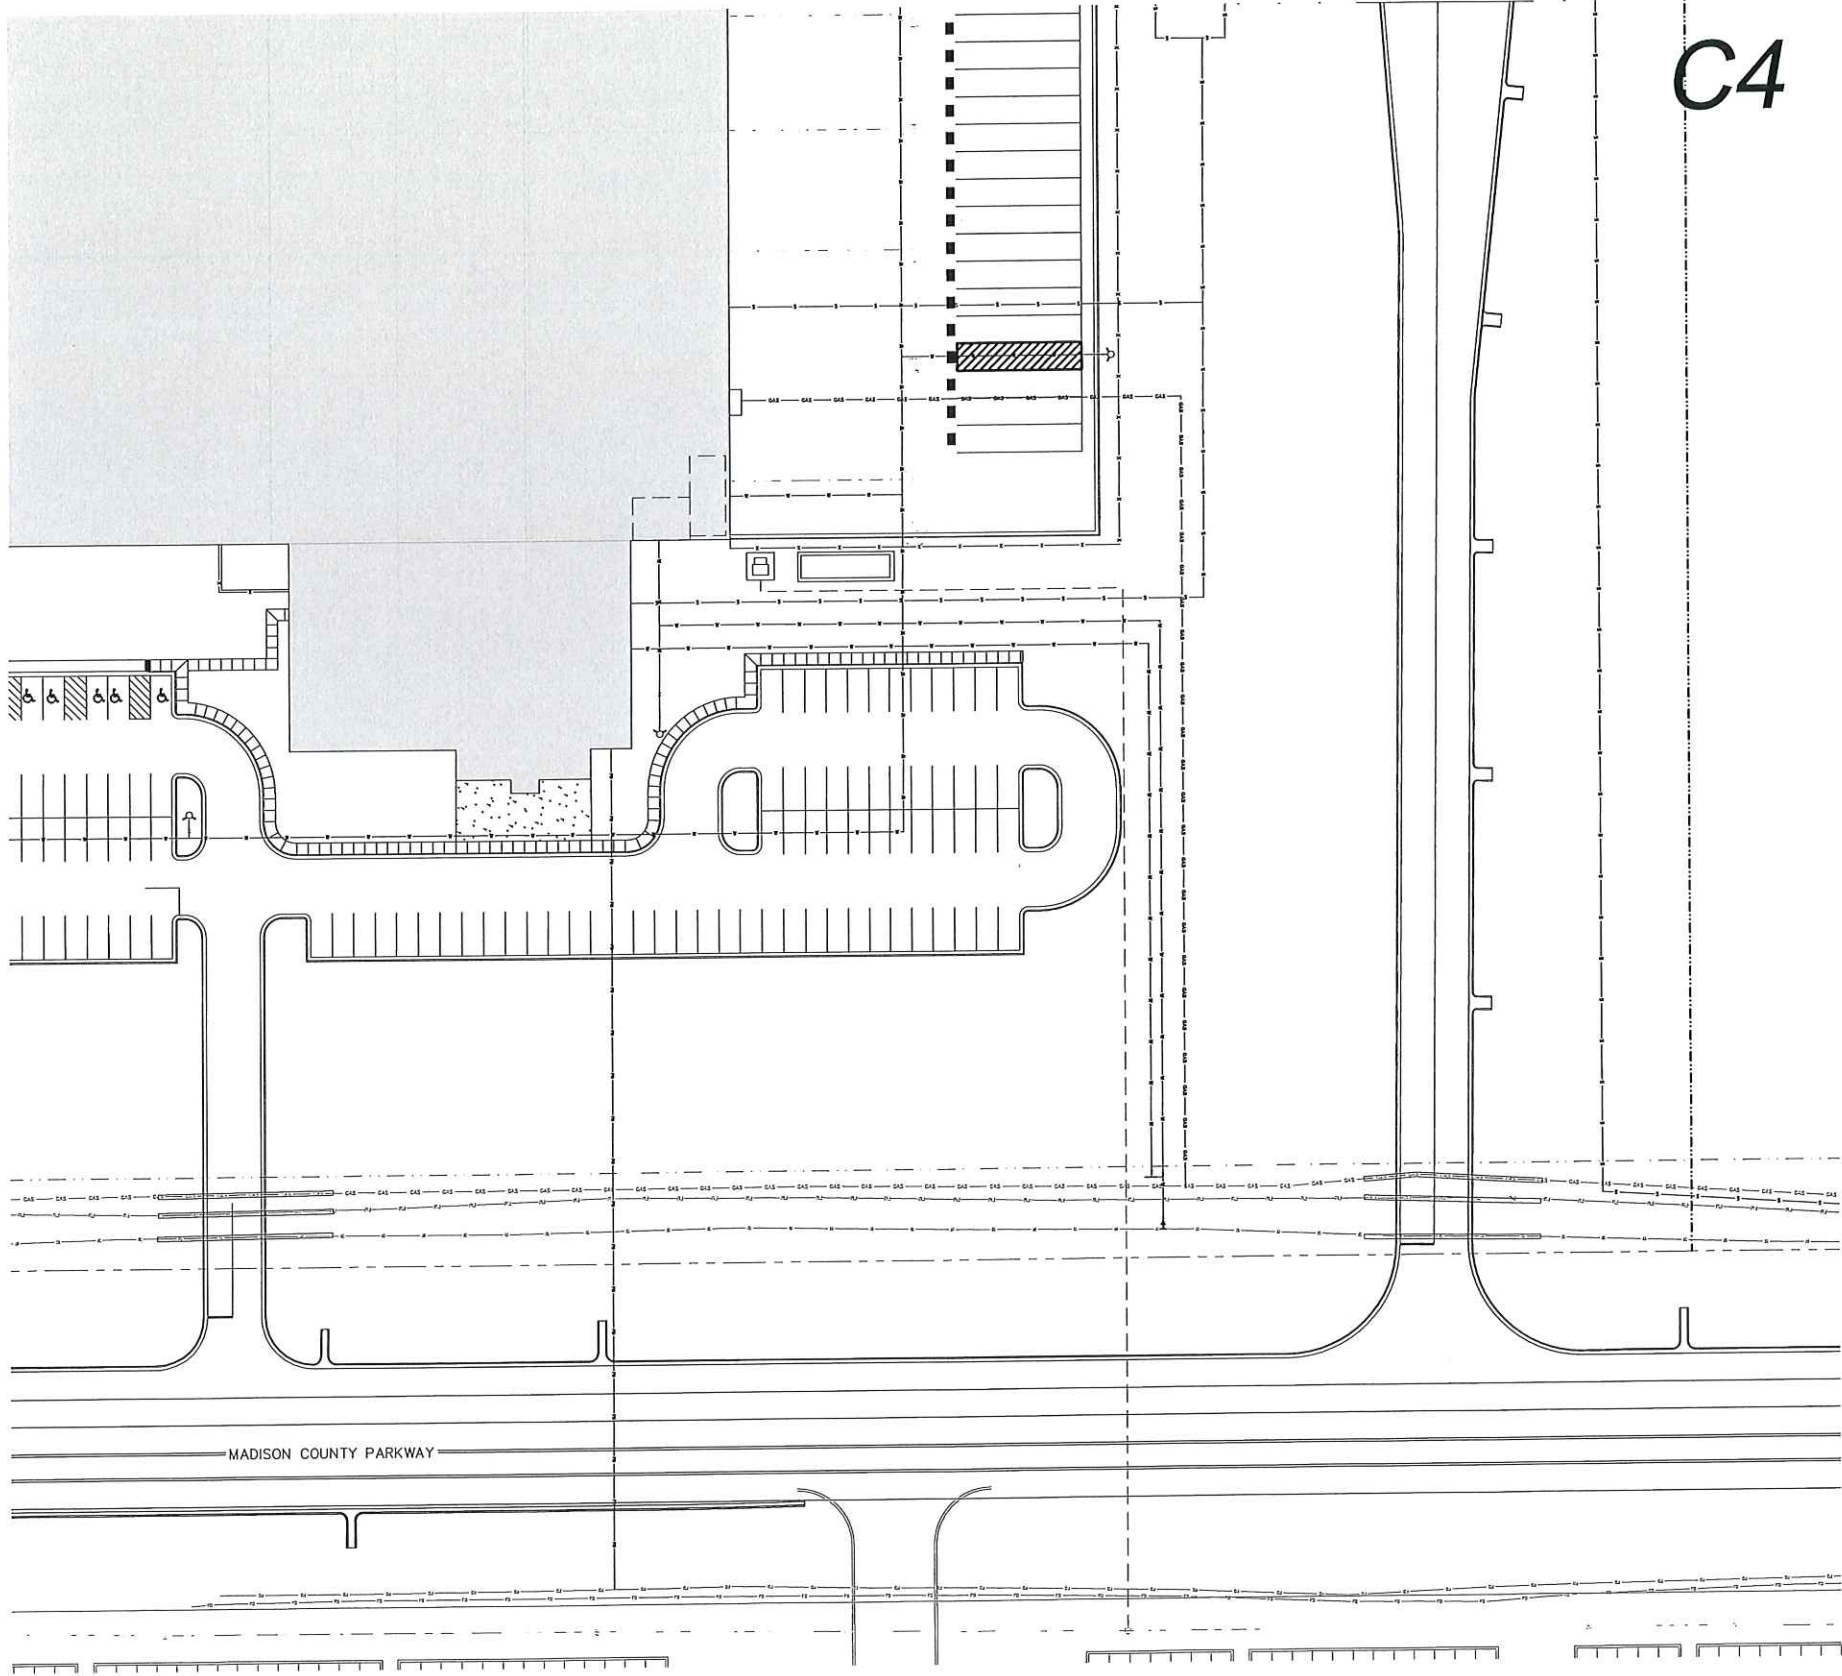

MADISON COUNTY PARKWAY

MATCH SHEET C4.3

C4

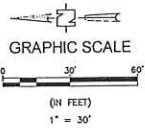

C1C2
C3C4
C5C6
GRID MAP



CLIENT CLARK BEVERAGE GROUP, INC.
OAKLAND, KY
PROJECT PROJECT JOY SALES CENTER
CANTON, MS
DRAWING TITLE UTILITY PLAN LAYOUT


PROJECT NO. 2300638
ISSUED: 5-17-2023
SCALE: AS NOTED
DRAWN BY: WLC
DRAWING NO.

C4.5



Design Group
DG ARCHITECTURAL AND ENGINEERING FACILITY SOLUTIONS, PLLC
1072 WINDWARD RIDGE PKWY, STE. 100, ALPHARETTA, GA 30005
PHONE: (770) 667-6222 FAX: (770) 667-6221














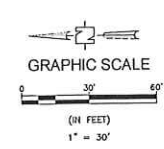


**Civil
Link**
"Connecting Resources"

[illegible]

PROJECT NO. 2300638
ISSUED: 5-17-2023
SCALE: AS NOTED
DRAWN BY: WLC
DRAWING NO.

C4.7

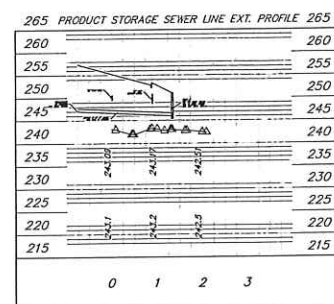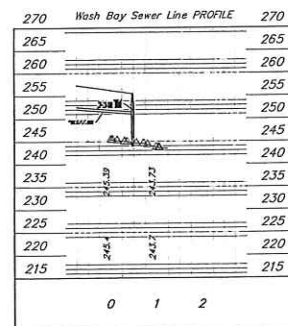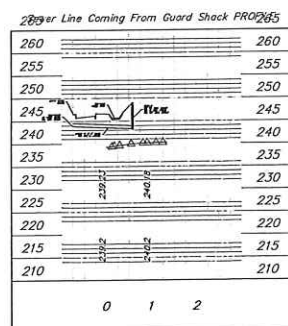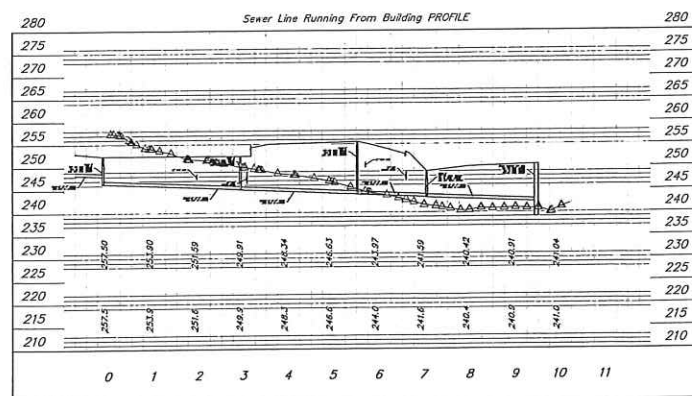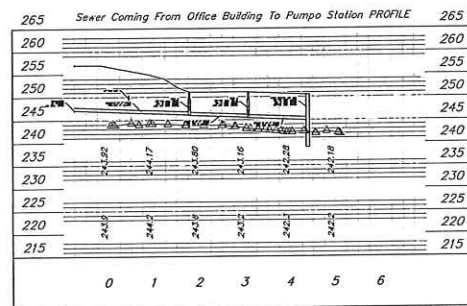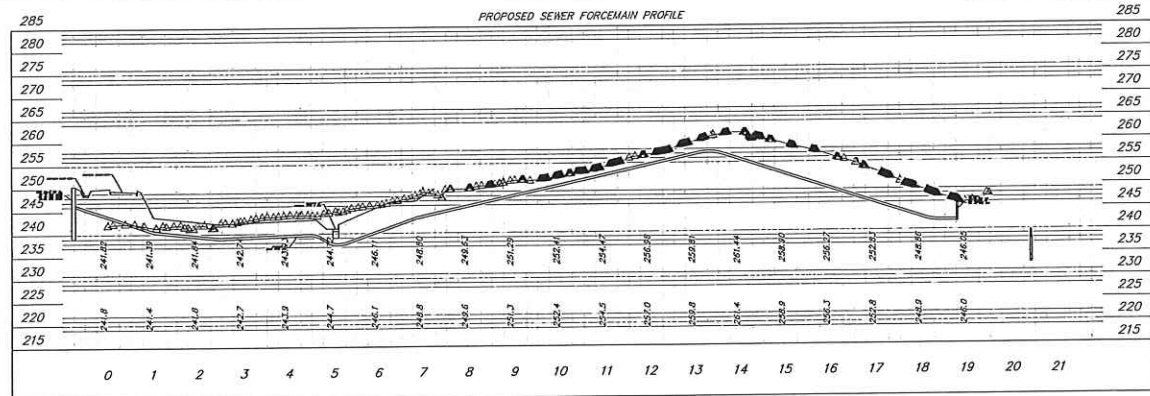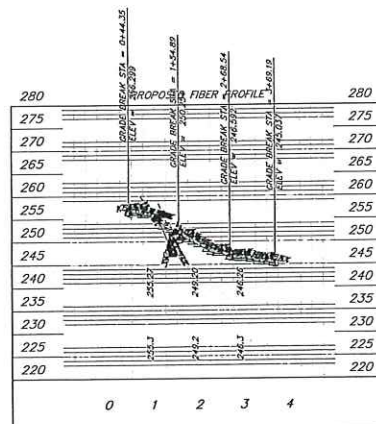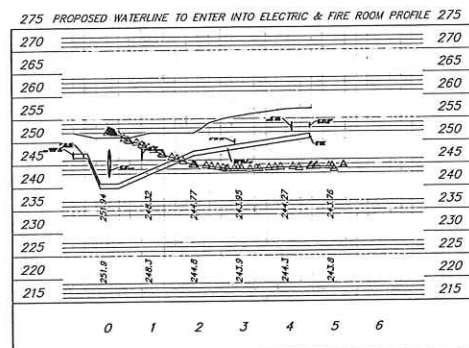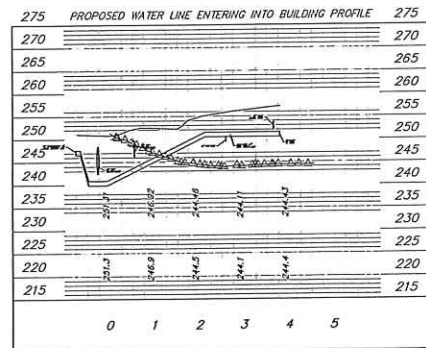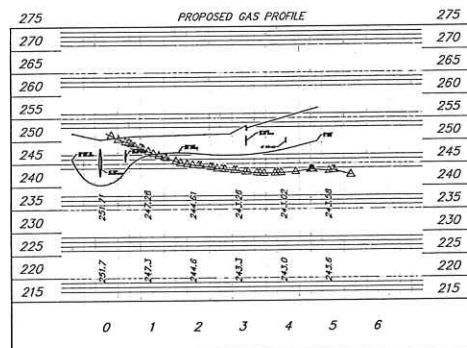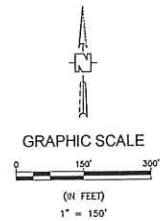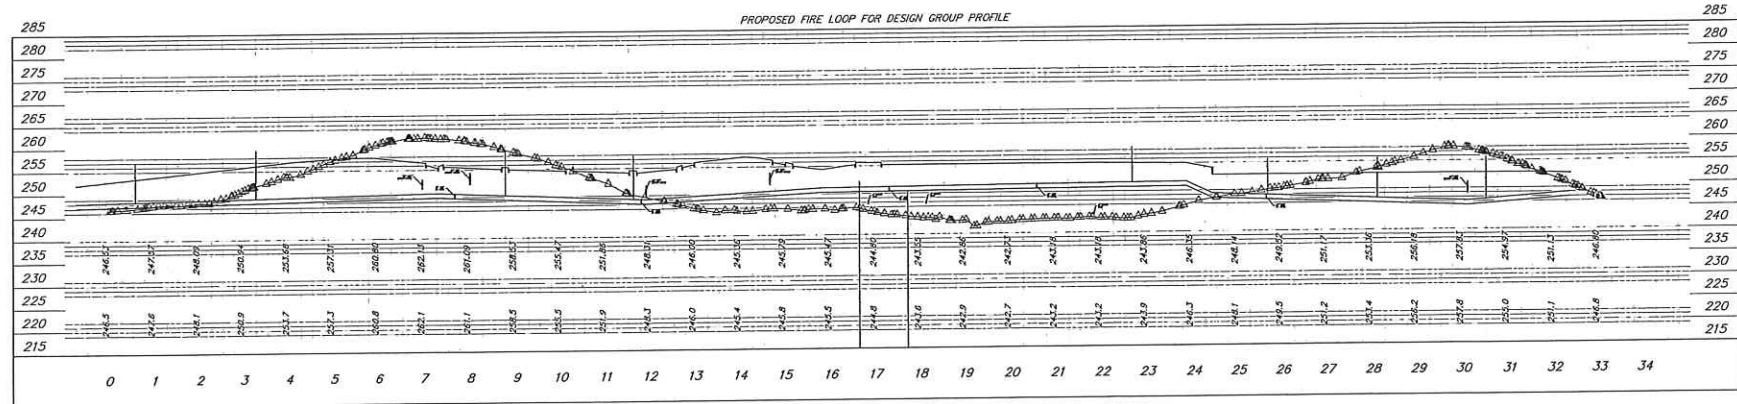

Design Group



DESIGN GROUP, INC.
1000 WASHINGTON BLVD, SUITE 100, ALPHARETTA, GA 30005
PHONE: (770) 882-0200 FAX: (770) 882-0201



CLIENT CLARK BEVERAGE GROUP, INC.
PROJECT PROJECT JOY SALES CENTER
CANTON, MS


PROJECT NO. 2300538
ISSUED: 5-17-2023
SCALE: AS NOTED
DRAWN BY: WLC
DRAWING NO. C4.8

UTILITY PLAN LAYOUT

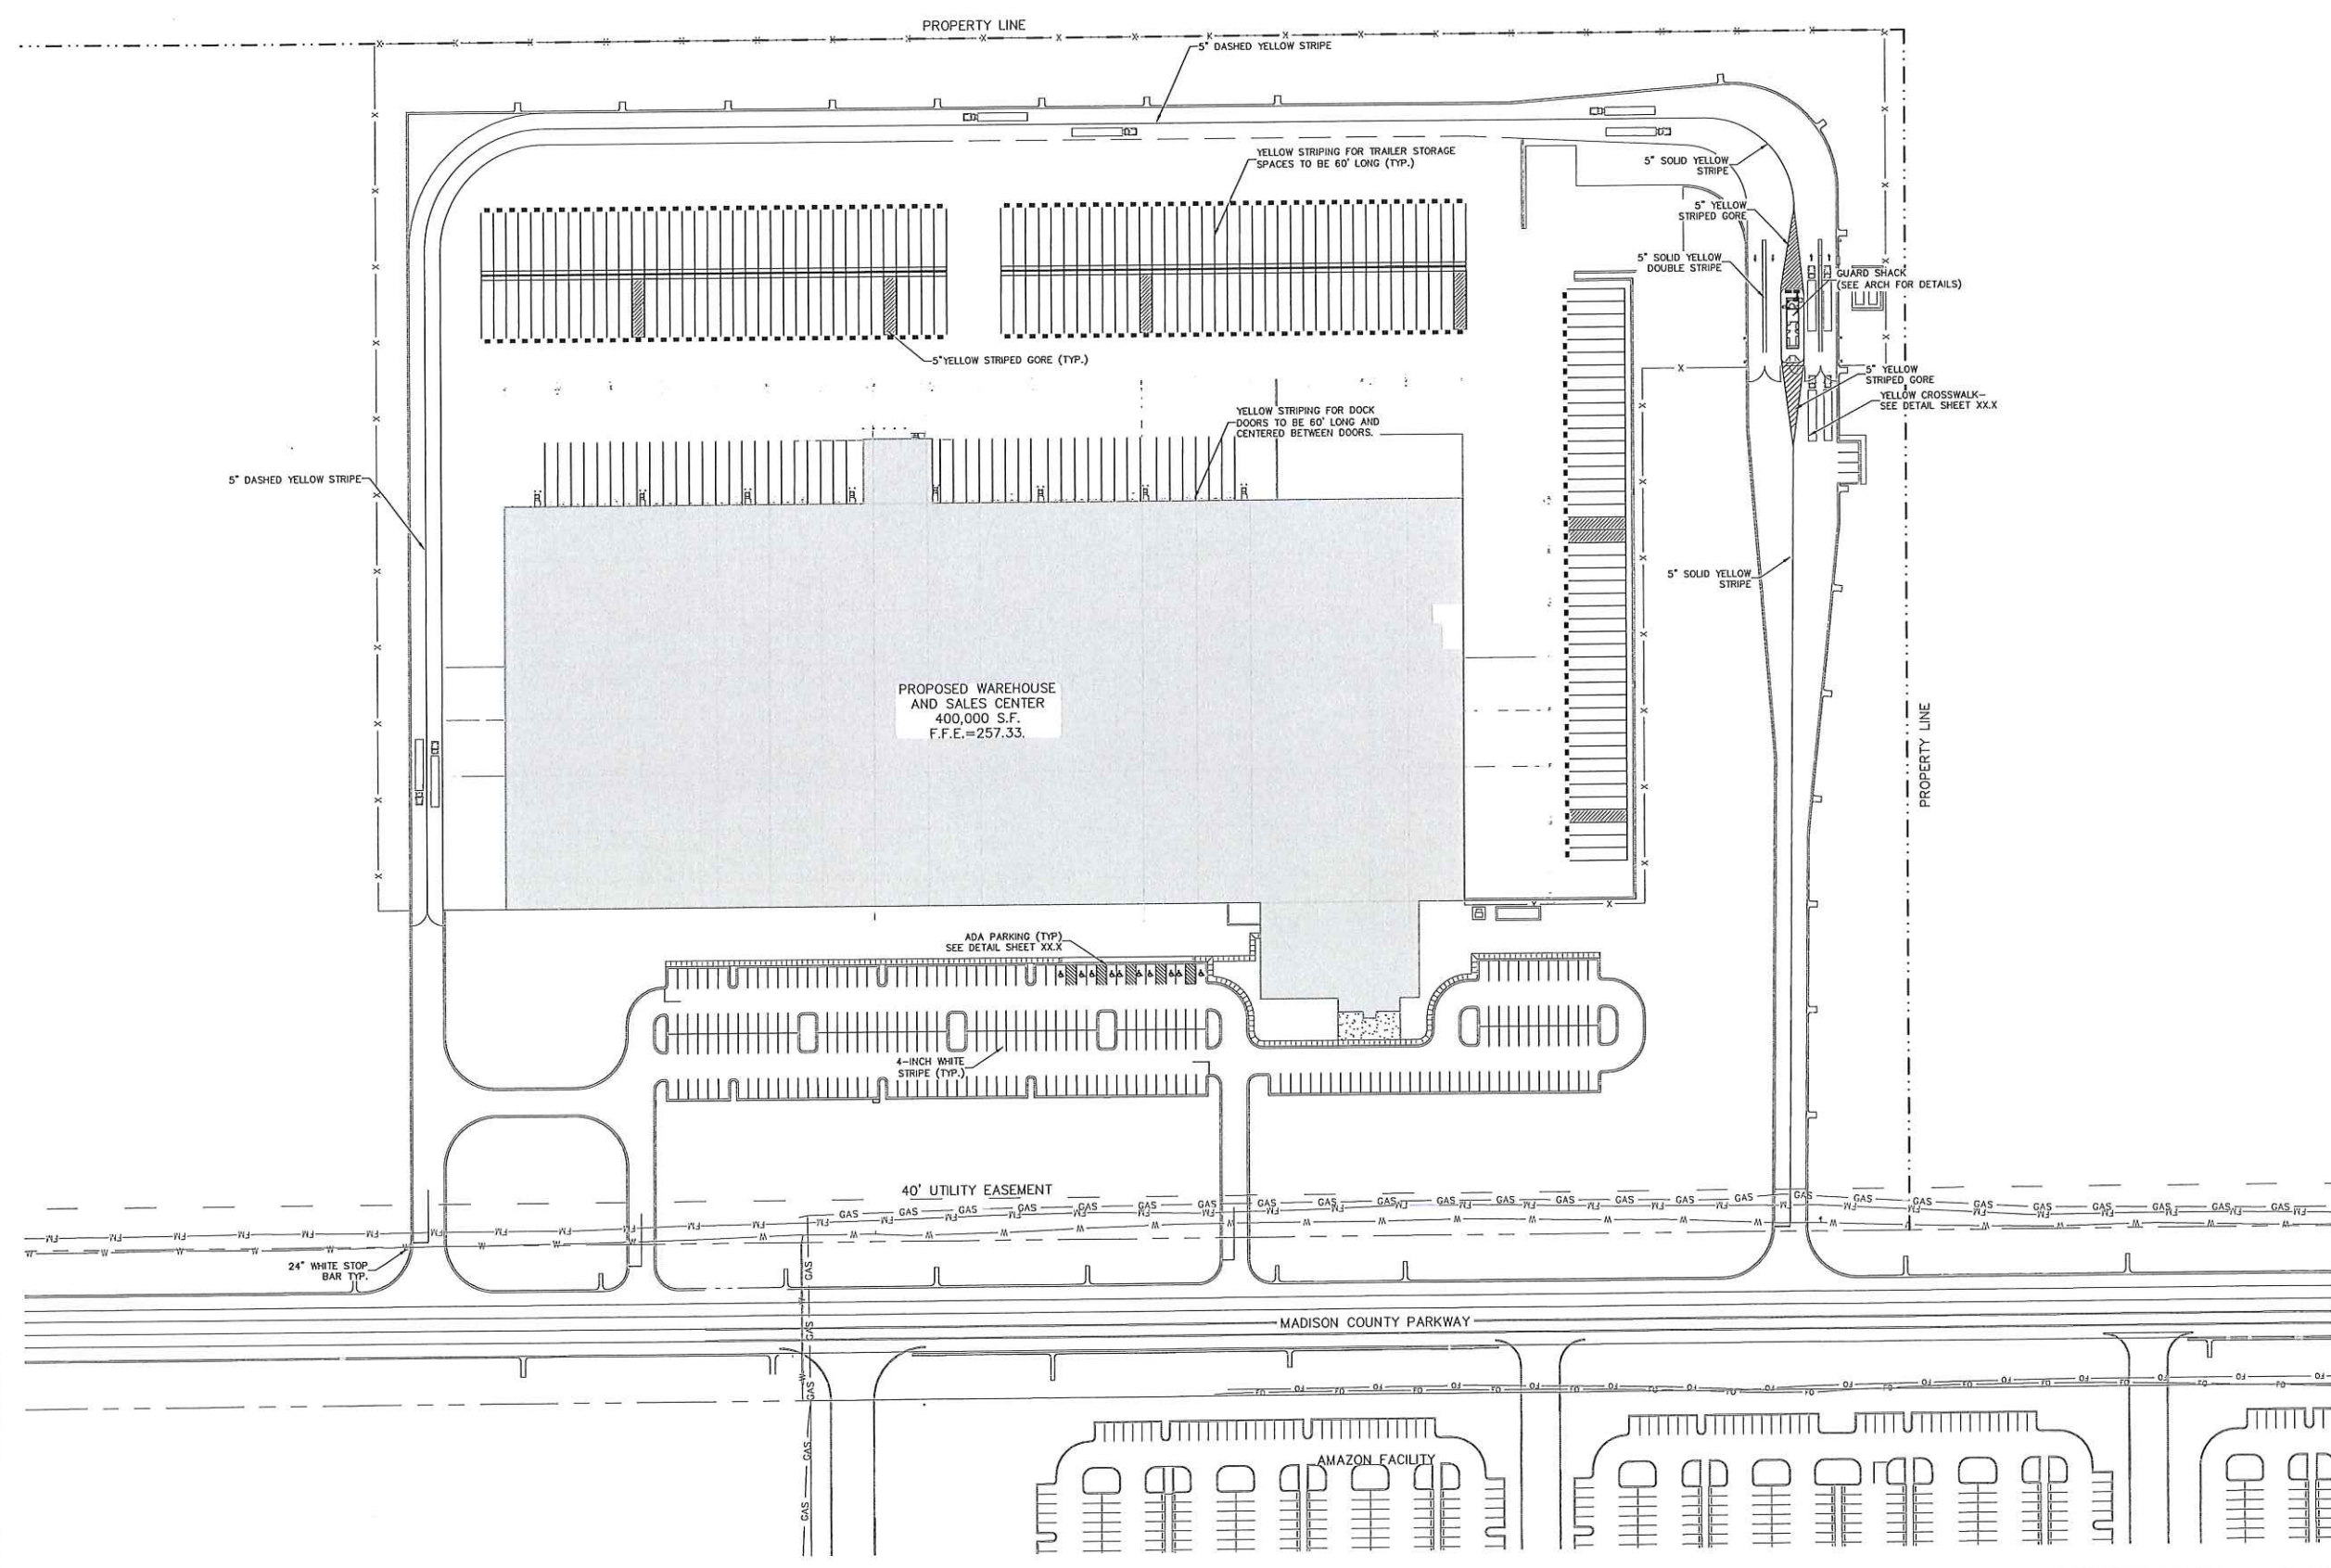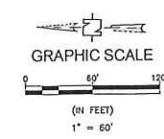



Design Group
D&G ARCHITECTURAL AND ENGINEERING FACILITY SOLUTIONS, PLLC
3035 WINDWARD ROAD, SUITE 200
FARMINGTON, CT 06030
PHONE: (781) 467-4239 FAX: (781) 467-4241



REVISION	ISSUED FOR	BY	DATE
1		WAC	5/17/23
2			
3			
4			
5			
6			
7			
8			
9			
10			

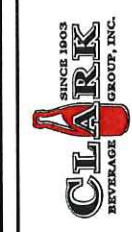

CLIENT	CLARK BEVERAGE GROUP, INC. OAKLAND, KY
PROJECT	PROJECT JOY SALES CENTER CANTON, MS
DRAWING TITLE	SITE STRIPING AND SIGNAGE LAYOUT

PROJECT NO. 2200638
ISSUED: 5-17-2023
SCALE: AS NOTED
DRAWN BY: WAC
DRAWING NO.
C5.0

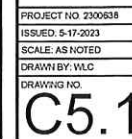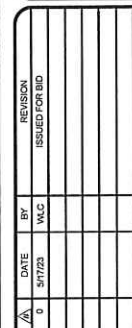

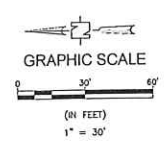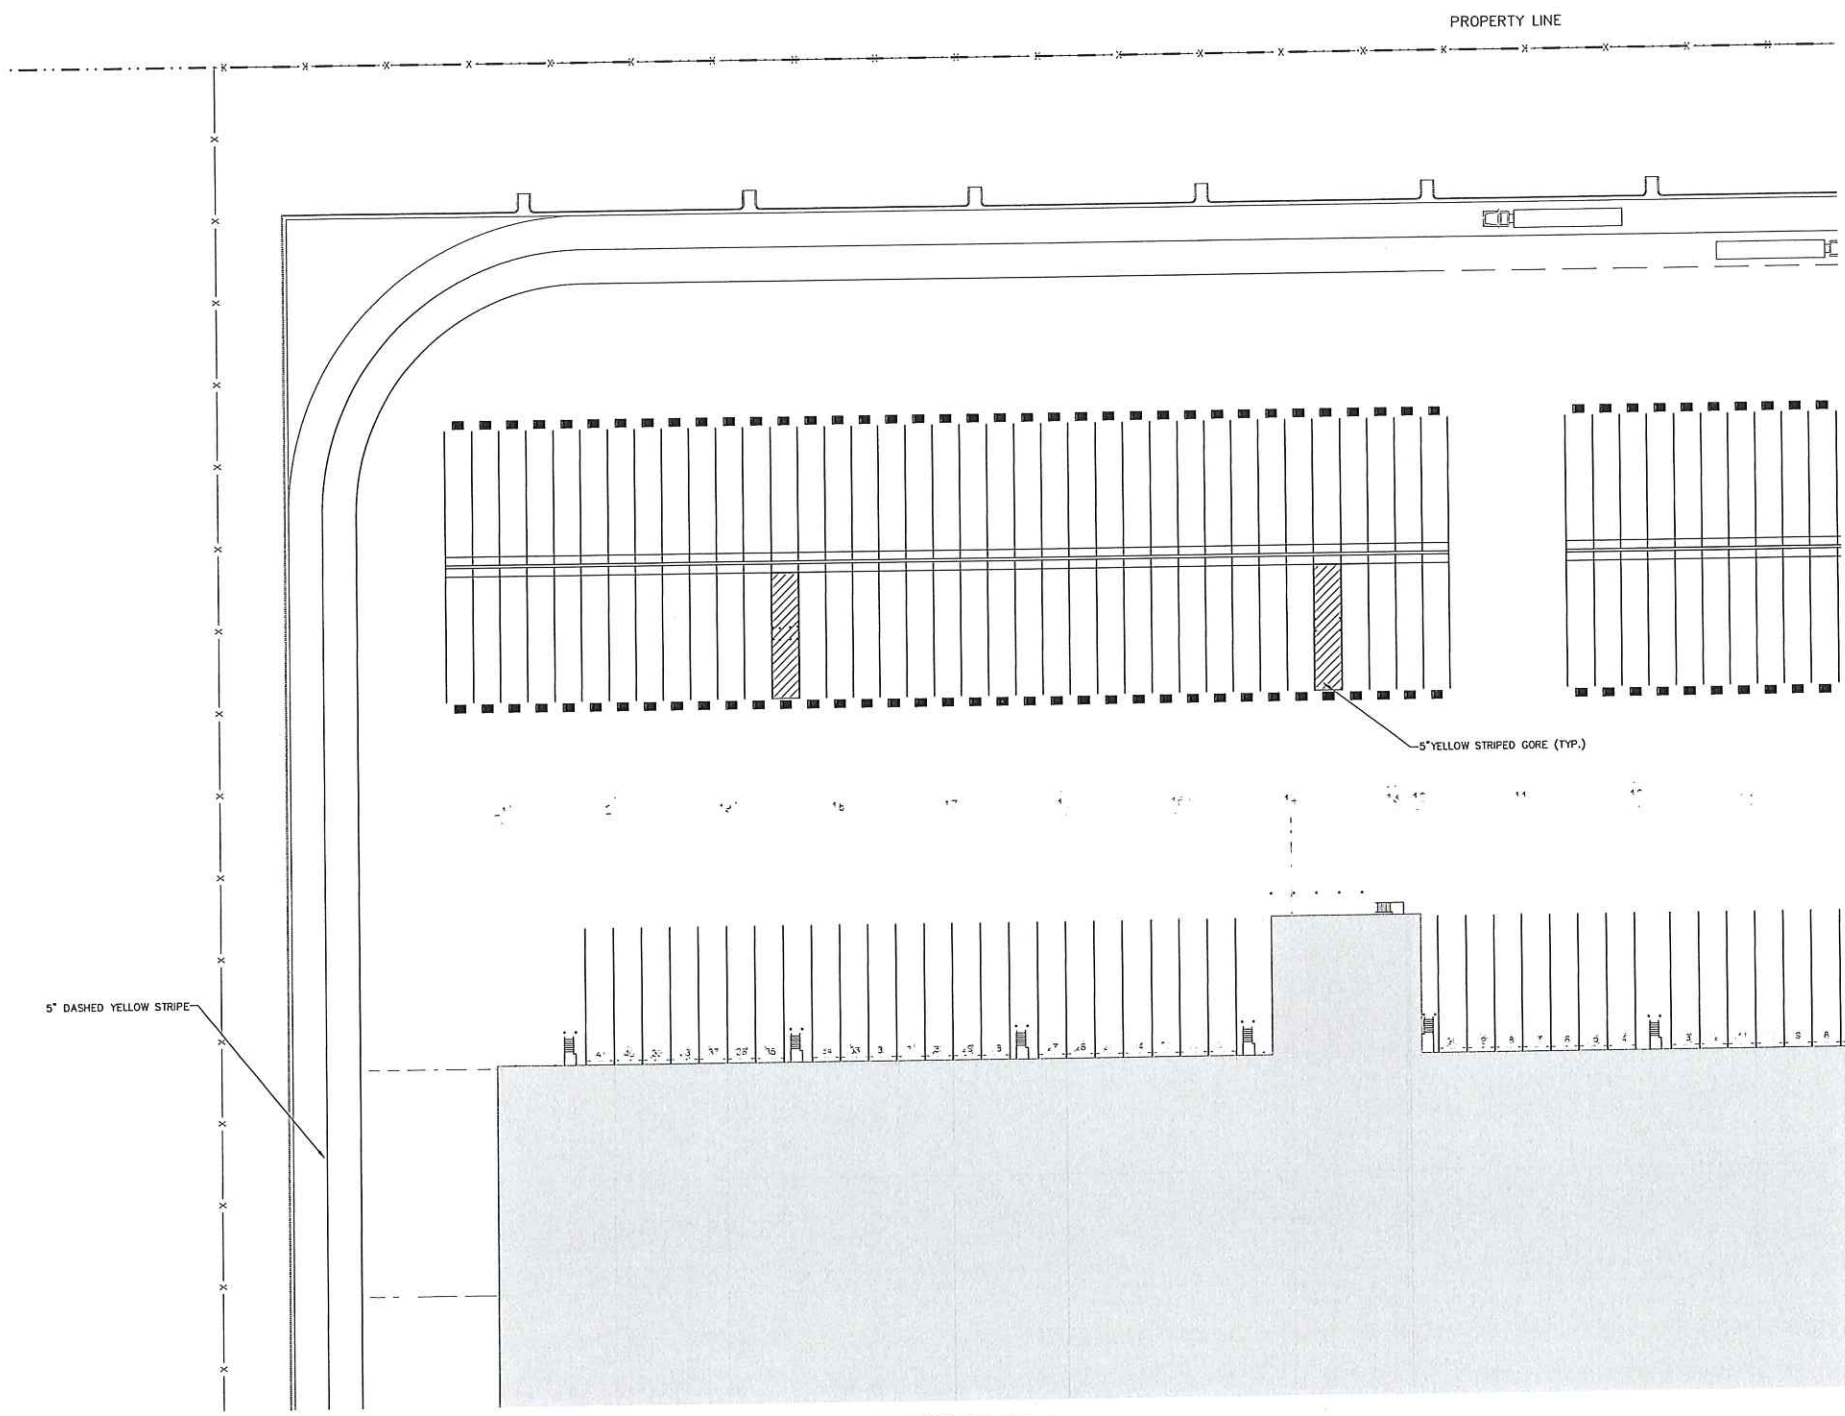

C1

MATCH SHEET C5.3


MATCH SHEET C5.4

C1C2
C3C4
GRID MAP




Design Group
DG ARCHITECTURAL AND ENGINEERING FACILITY SOLUTIONS, PLLC
105 WINDWARD RIDGE WAY, SUITE 100, CANTON, MS 39046
PHONE: (769) 467-1941 FAX: (769) 467-4261

REVISION	DATE	BY	WAC	ISSUED FOR BID
0	5/17/2023			

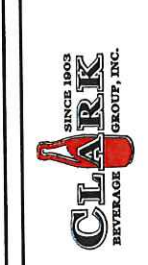


CLIENT	CLARK BEVERAGE GROUP, INC. OAKLAND, KY
PROJECT	PROJECT JOY SALES CENTER CANTON, MS
DRAWING TITLE	SITE STRIPING AND SIGNAGE LAYOUT

PROJECT NO.	2200538
ISSUED	5-17-2023
SCALE	AS NOTED
DRAWN BY	WAC
DRAWING NO.	C5.2

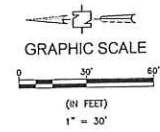

C2

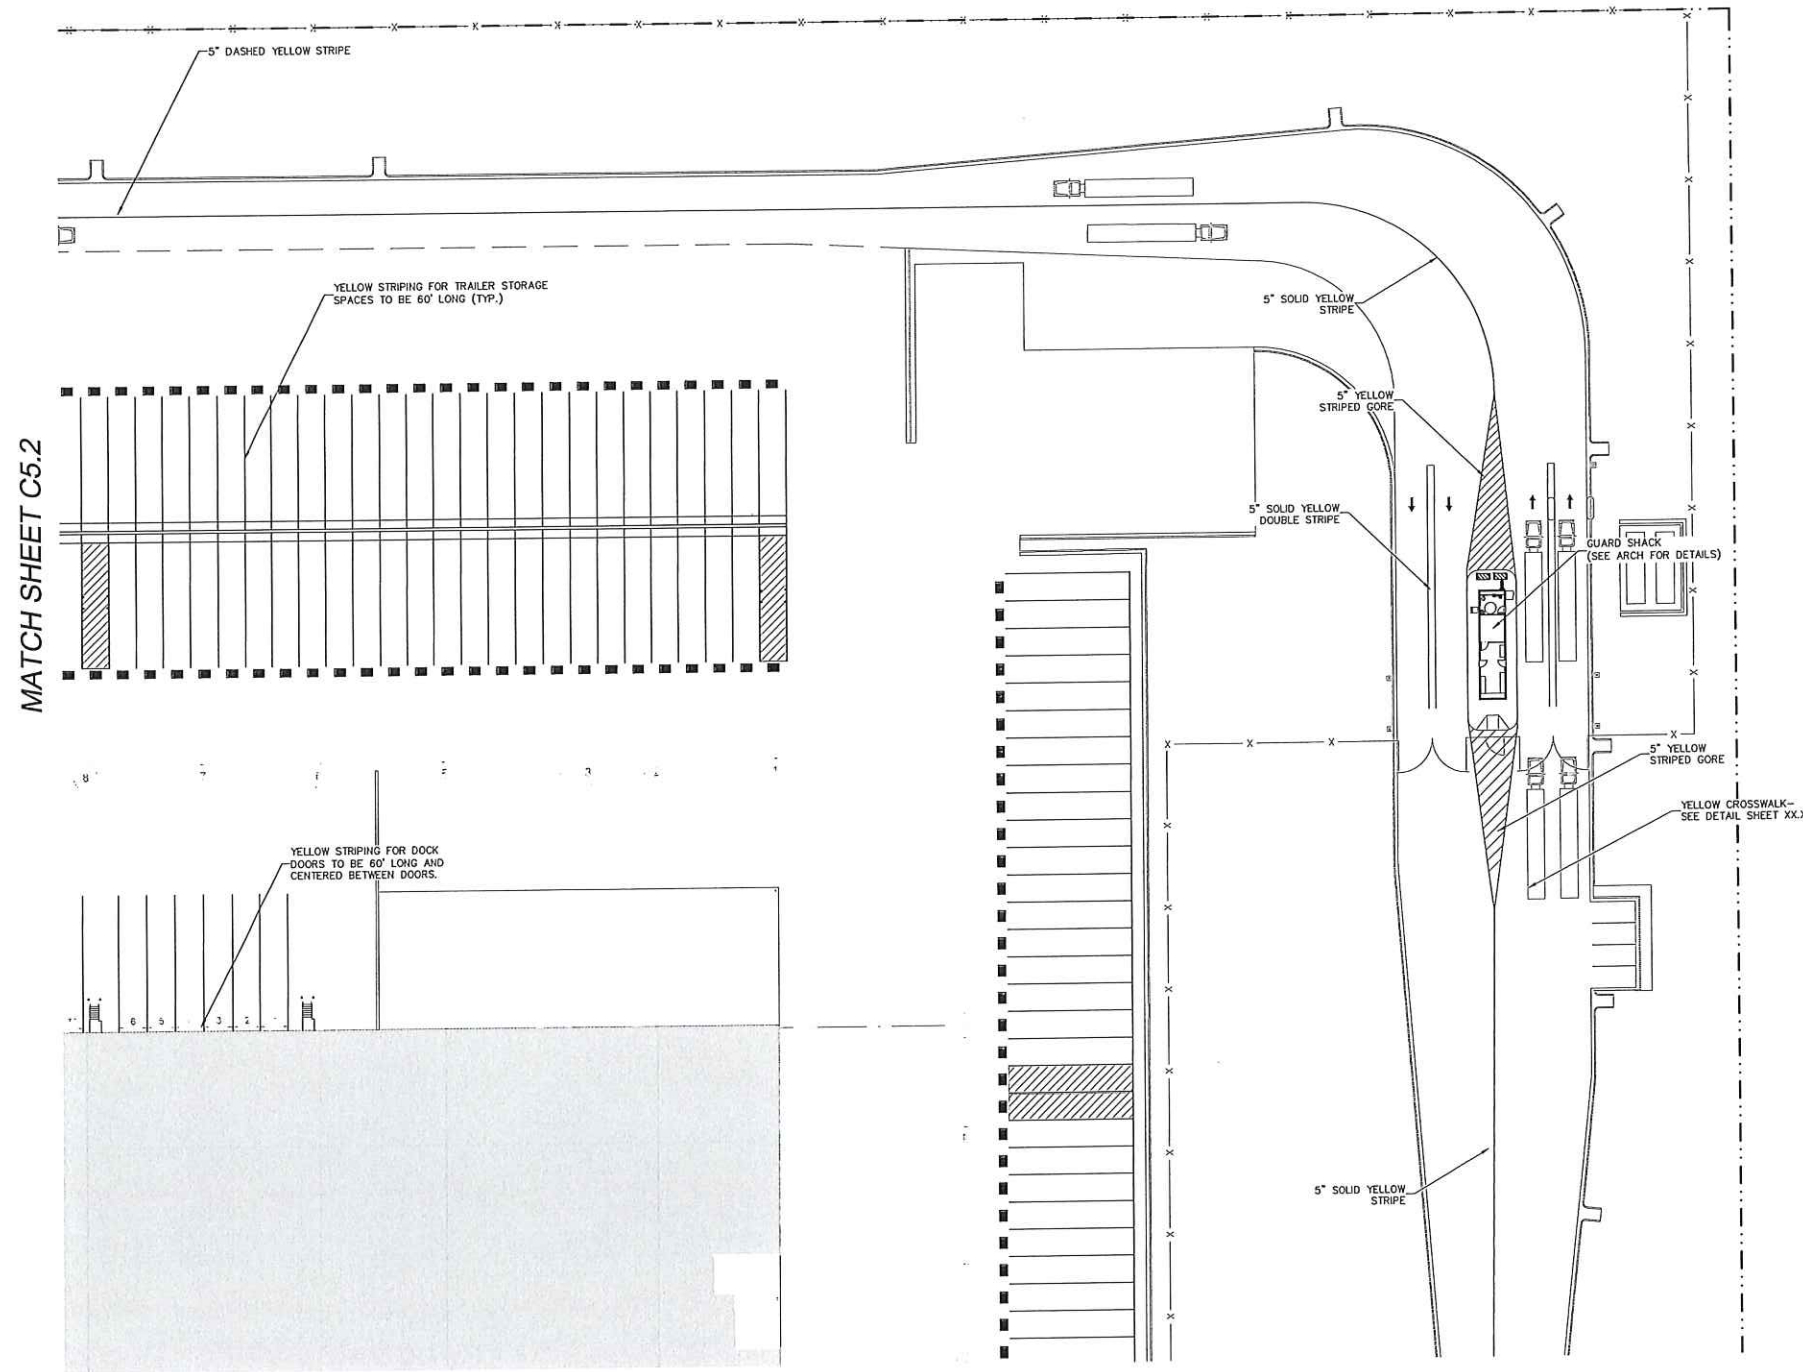

MATCH SHEET C5.2

MATCH SHEET C5.5

C1C2
C3C4
GRID MAP



Design Group
DIG ARCHITECTURAL AND ENGINEERING FACILITY SOLUTIONS, PLLC
305 WINDWARD RIDGE PKWY, STE 100, ASPENHETTER, GA 30005
PHONE: (770) 497-1900 FAX: (770) 497-1901

REVISION	DATE	BY	WAC	ISSUED FOR BID
0	5/17/2023			




CLIENT: CLARK BEVERAGE GROUP, INC.
OAKLAND, KY
PROJECT: PROJECT JOY SALES CENTER
CANTON, MS
DRAWING TITLE: SITE STRIPING AND SIGNAGE LAYOUT

PROJECT NO. 2200638
ISSUED: 5-17-2023
SCALE: AS NOTED
DRAWN BY: WLC
DRAWING NO.


C5.3

MATCH SHEET C5.2

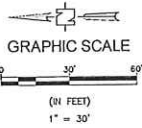

PROPOSED WAREHOUSE
AND SALES CENTER
400,000 S.F.
F.F.E.=257.33.

C3

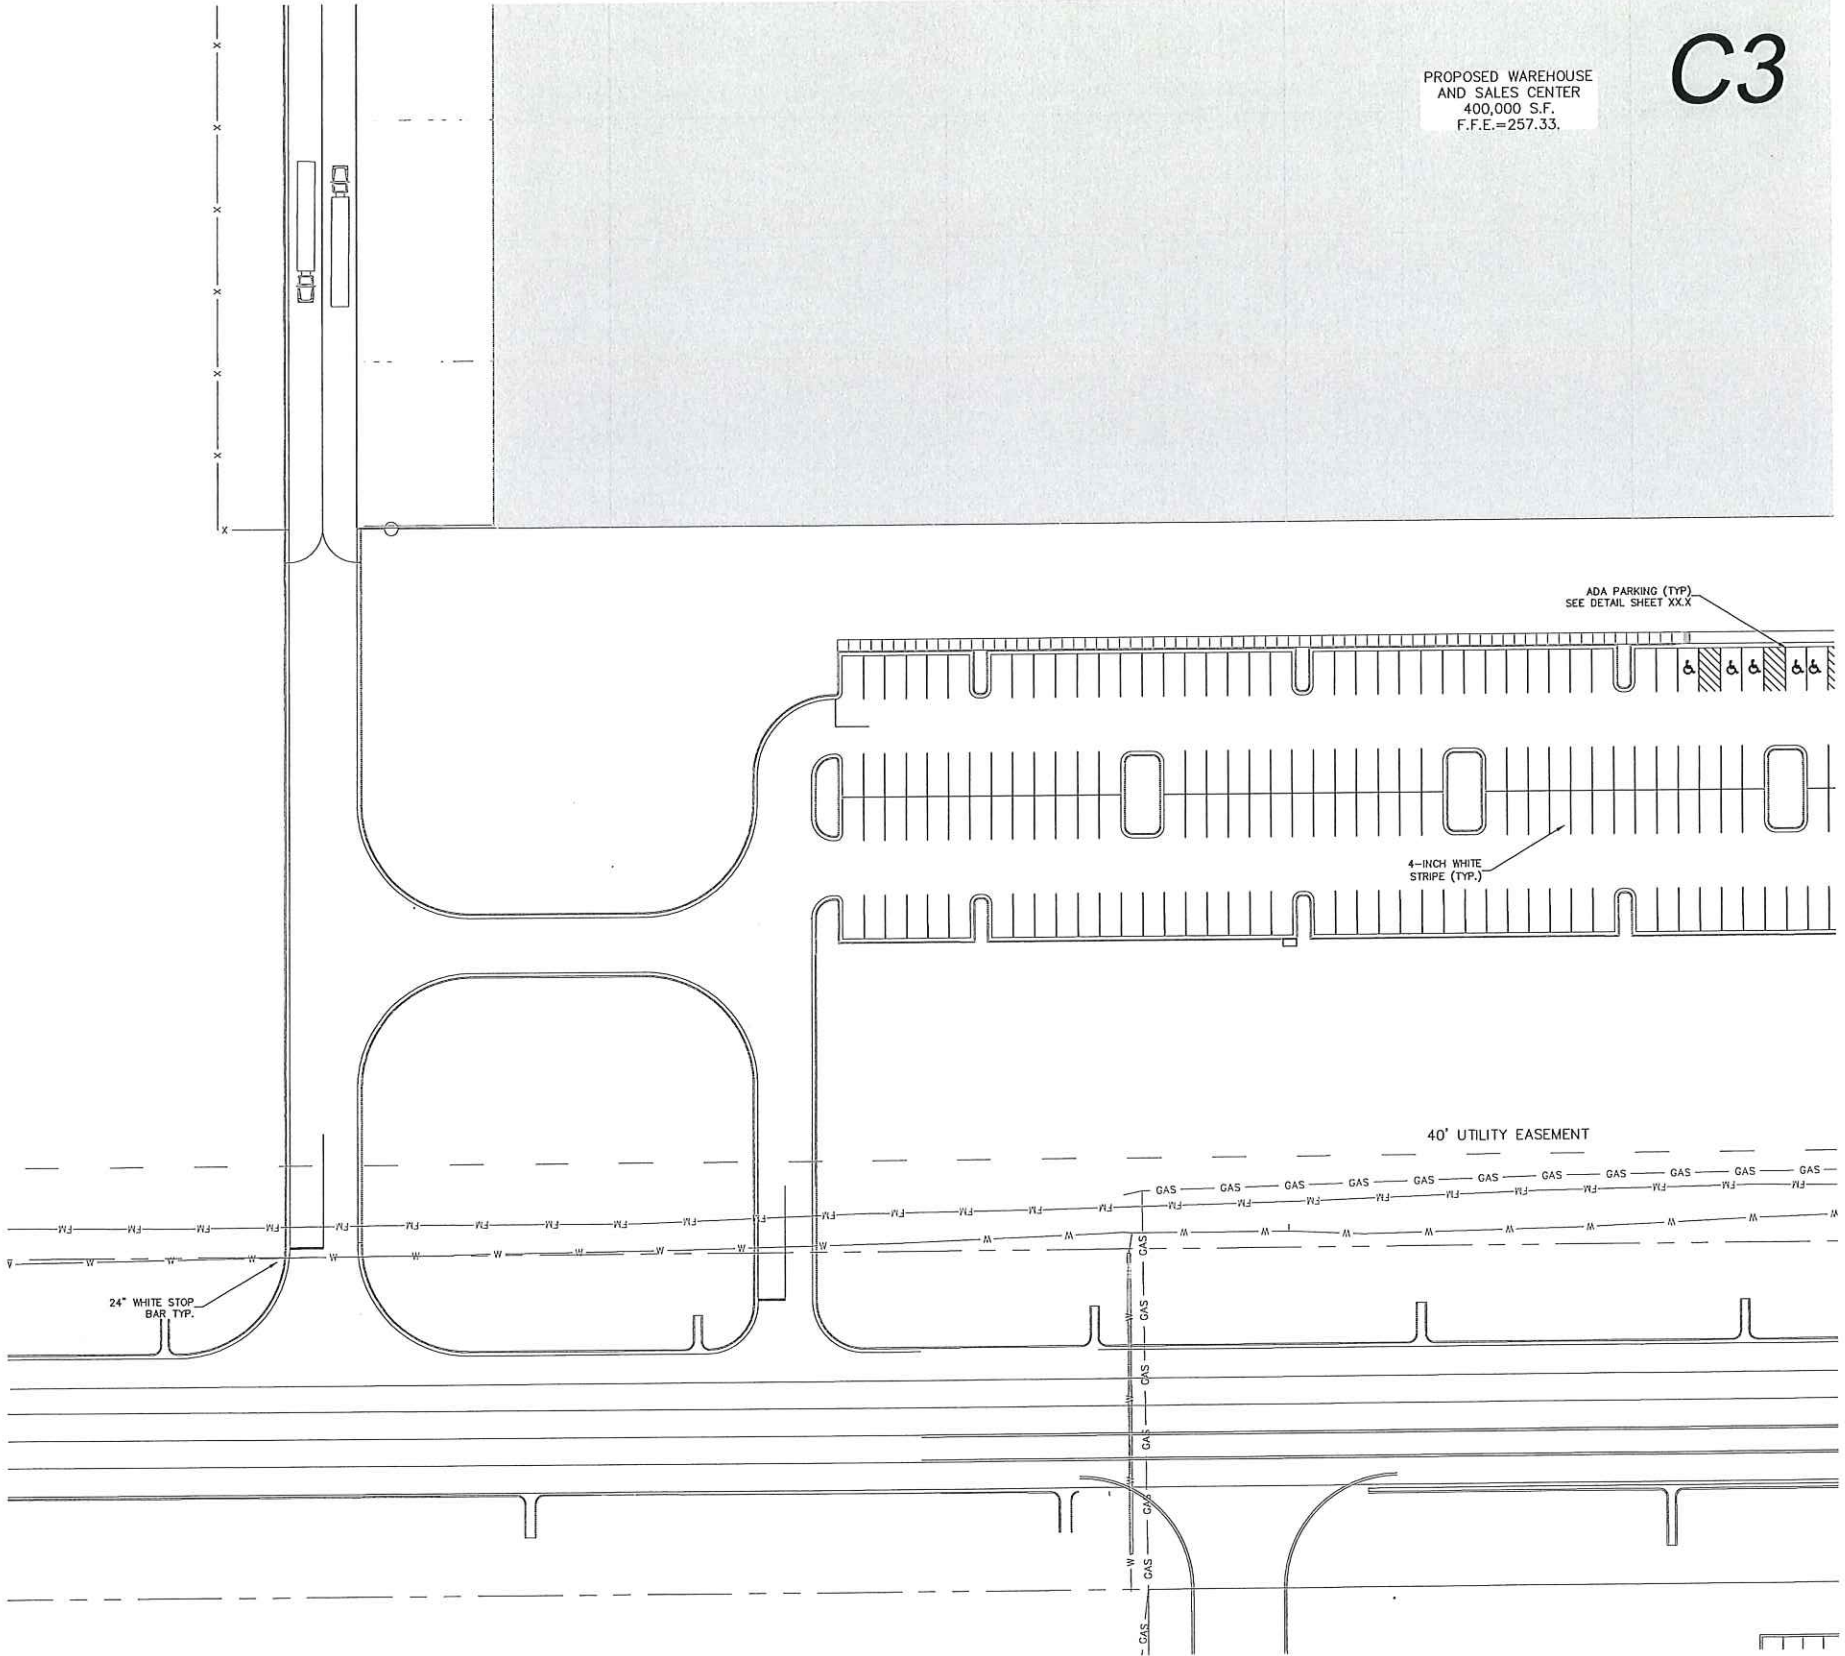

MATCH SHEET C5.5

C1C2
C3C4
GRID MAP




Design Group
DG ARCHITECTURAL AND ENGINEERING FACILITY SOLUTIONS, PLLC
3075 WILLOW RIDGE WAY, STE 100, ALPHARETTA, GA 30205
PHONE: (770) 667-6330 FAX: (770) 667-6331



CLIENT	CLARK BEVERAGE GROUP, INC. OAKLAND, KY
PROJECT	PROJECT JOY SALES CENTER CANTON, MS
DRAWING TITLE	SITE STRIPING AND SIGNAGE LAYOUT

PROJECT NO. 2300633
ISSUED: 5-17-2023
SCALE: AS NOTED
DRAWN BY: WAC
DRAWING NO.
C5.4

MATCH SHEET C5.4

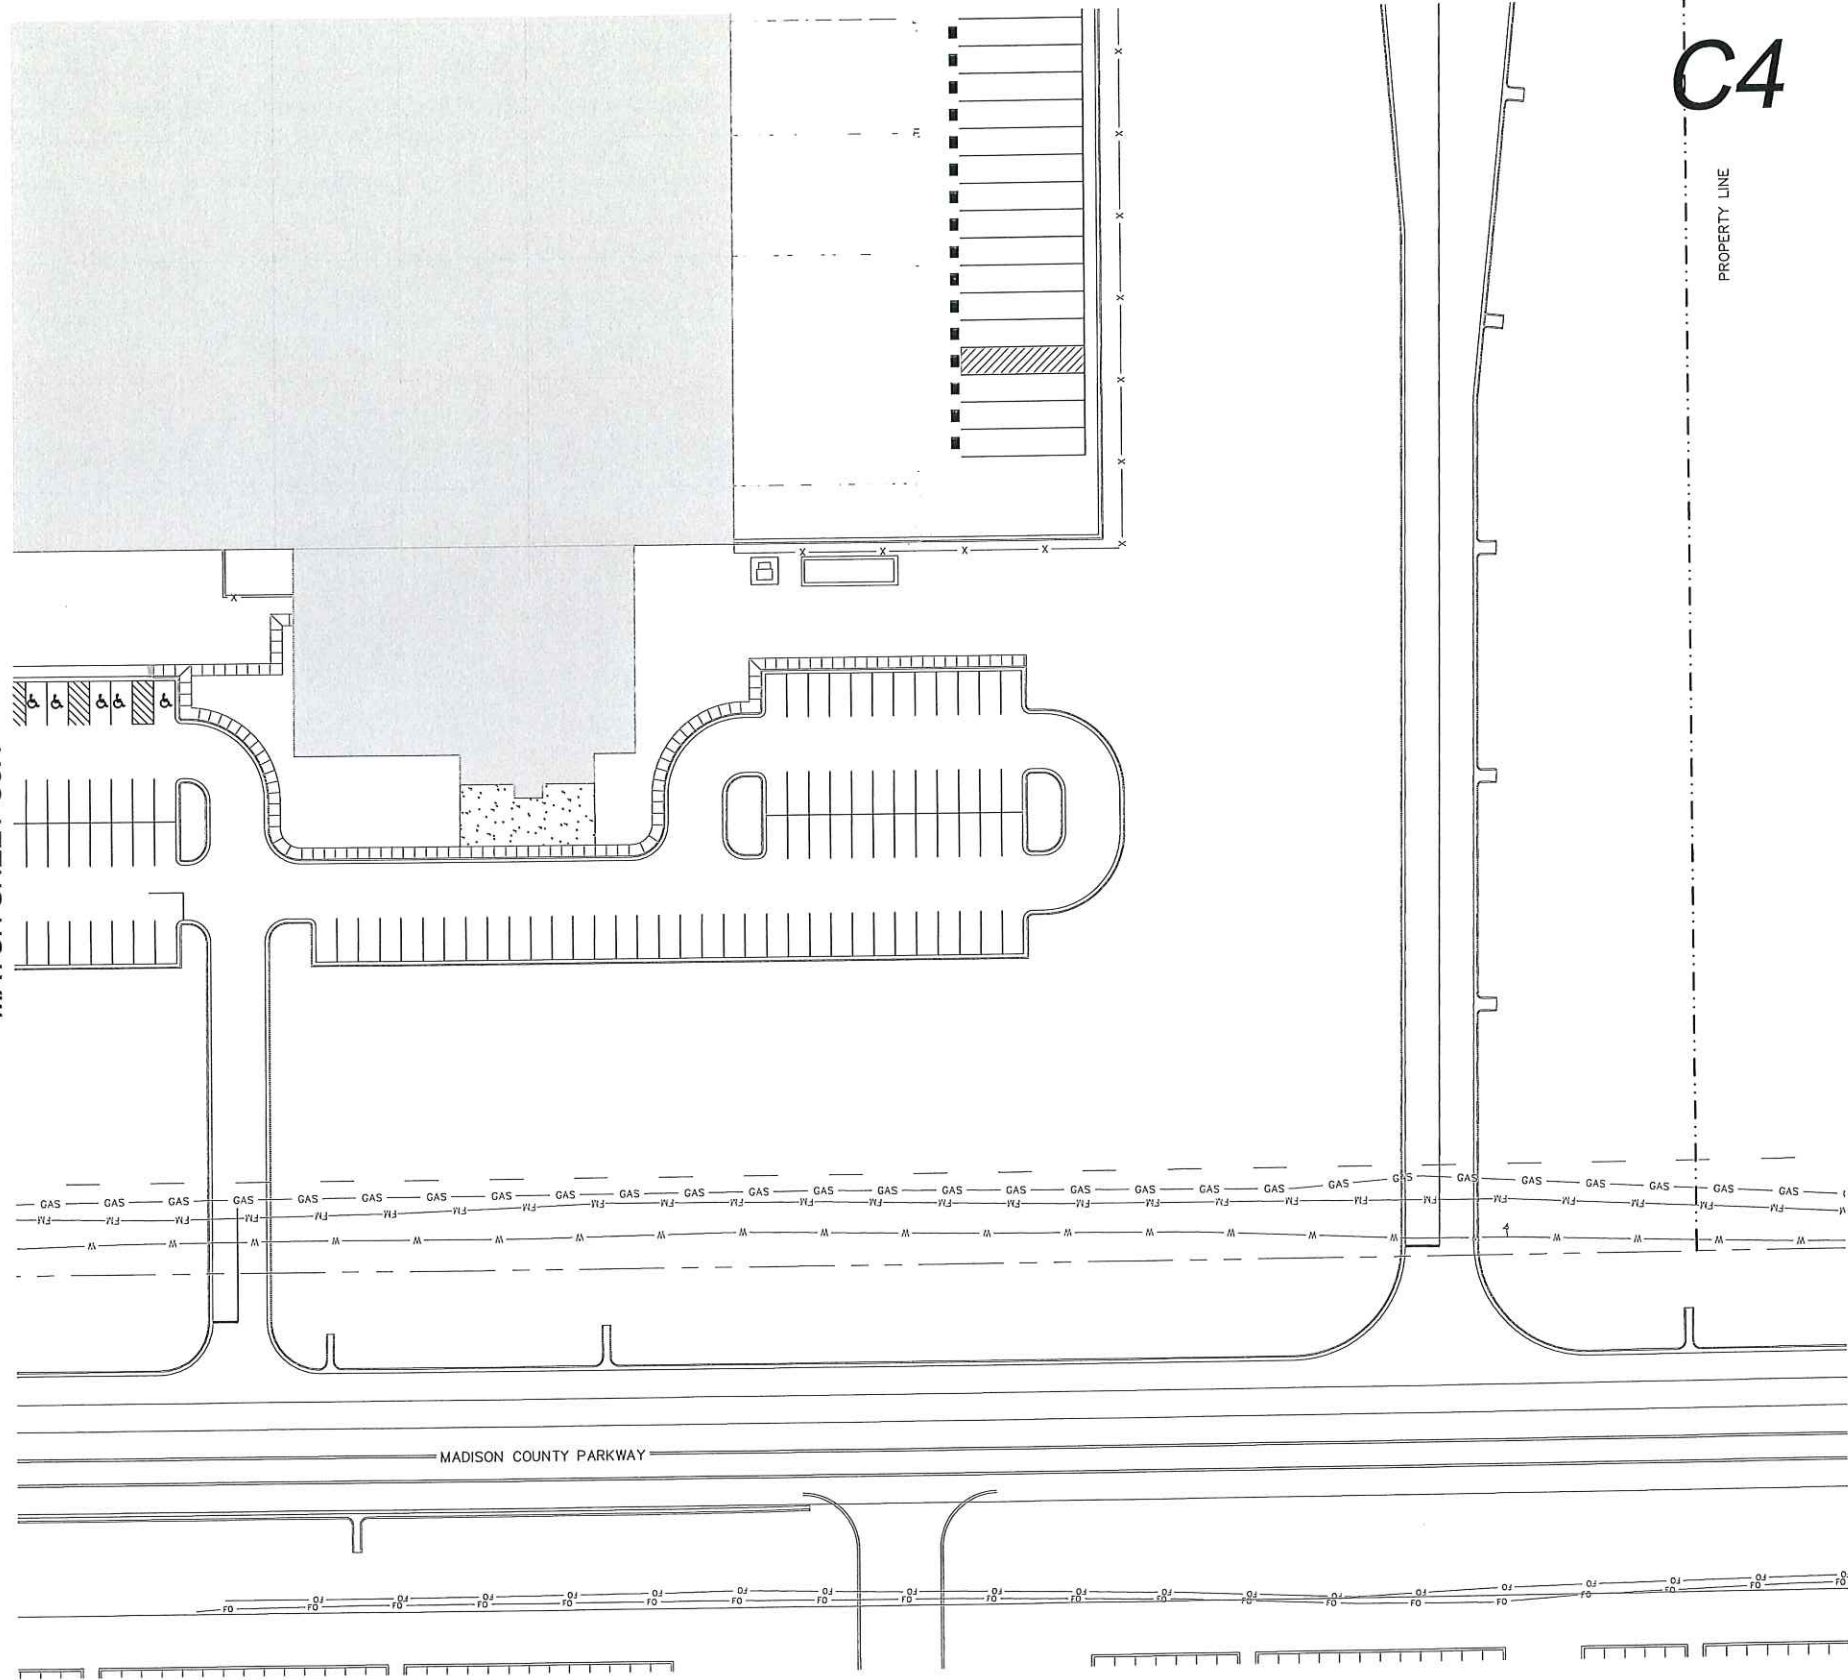


MATCH SHEET C5.3

C4

PROPERTY LINE

C1C2
C3C4
GRID MAP

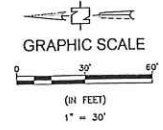

CLIENT
CLARK BEVERAGE GROUP, INC.
OAKLAND, KY



PROJECT
PROJECT JOY SALES CENTER
CANTON, MS

DRAWING
TITLE
SITE STRIPING AND SIGNAGE LAYOUT


PROJECT NO. 2300633
ISSUED: 5-17-2023
SCALE: AS NOTED
DRAWN BY: WLC
DRAWING NO.
C5.5

Design Group
DG ARCHITECTURAL AND ENGINEERING FACILITY SOLUTIONS, PLLC
305 WILSON ROAD, SUITE 100, ALPHARETTA, GA 30005
PHONE: (770) 667-5500 FAX: (770) 667-6231





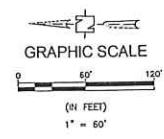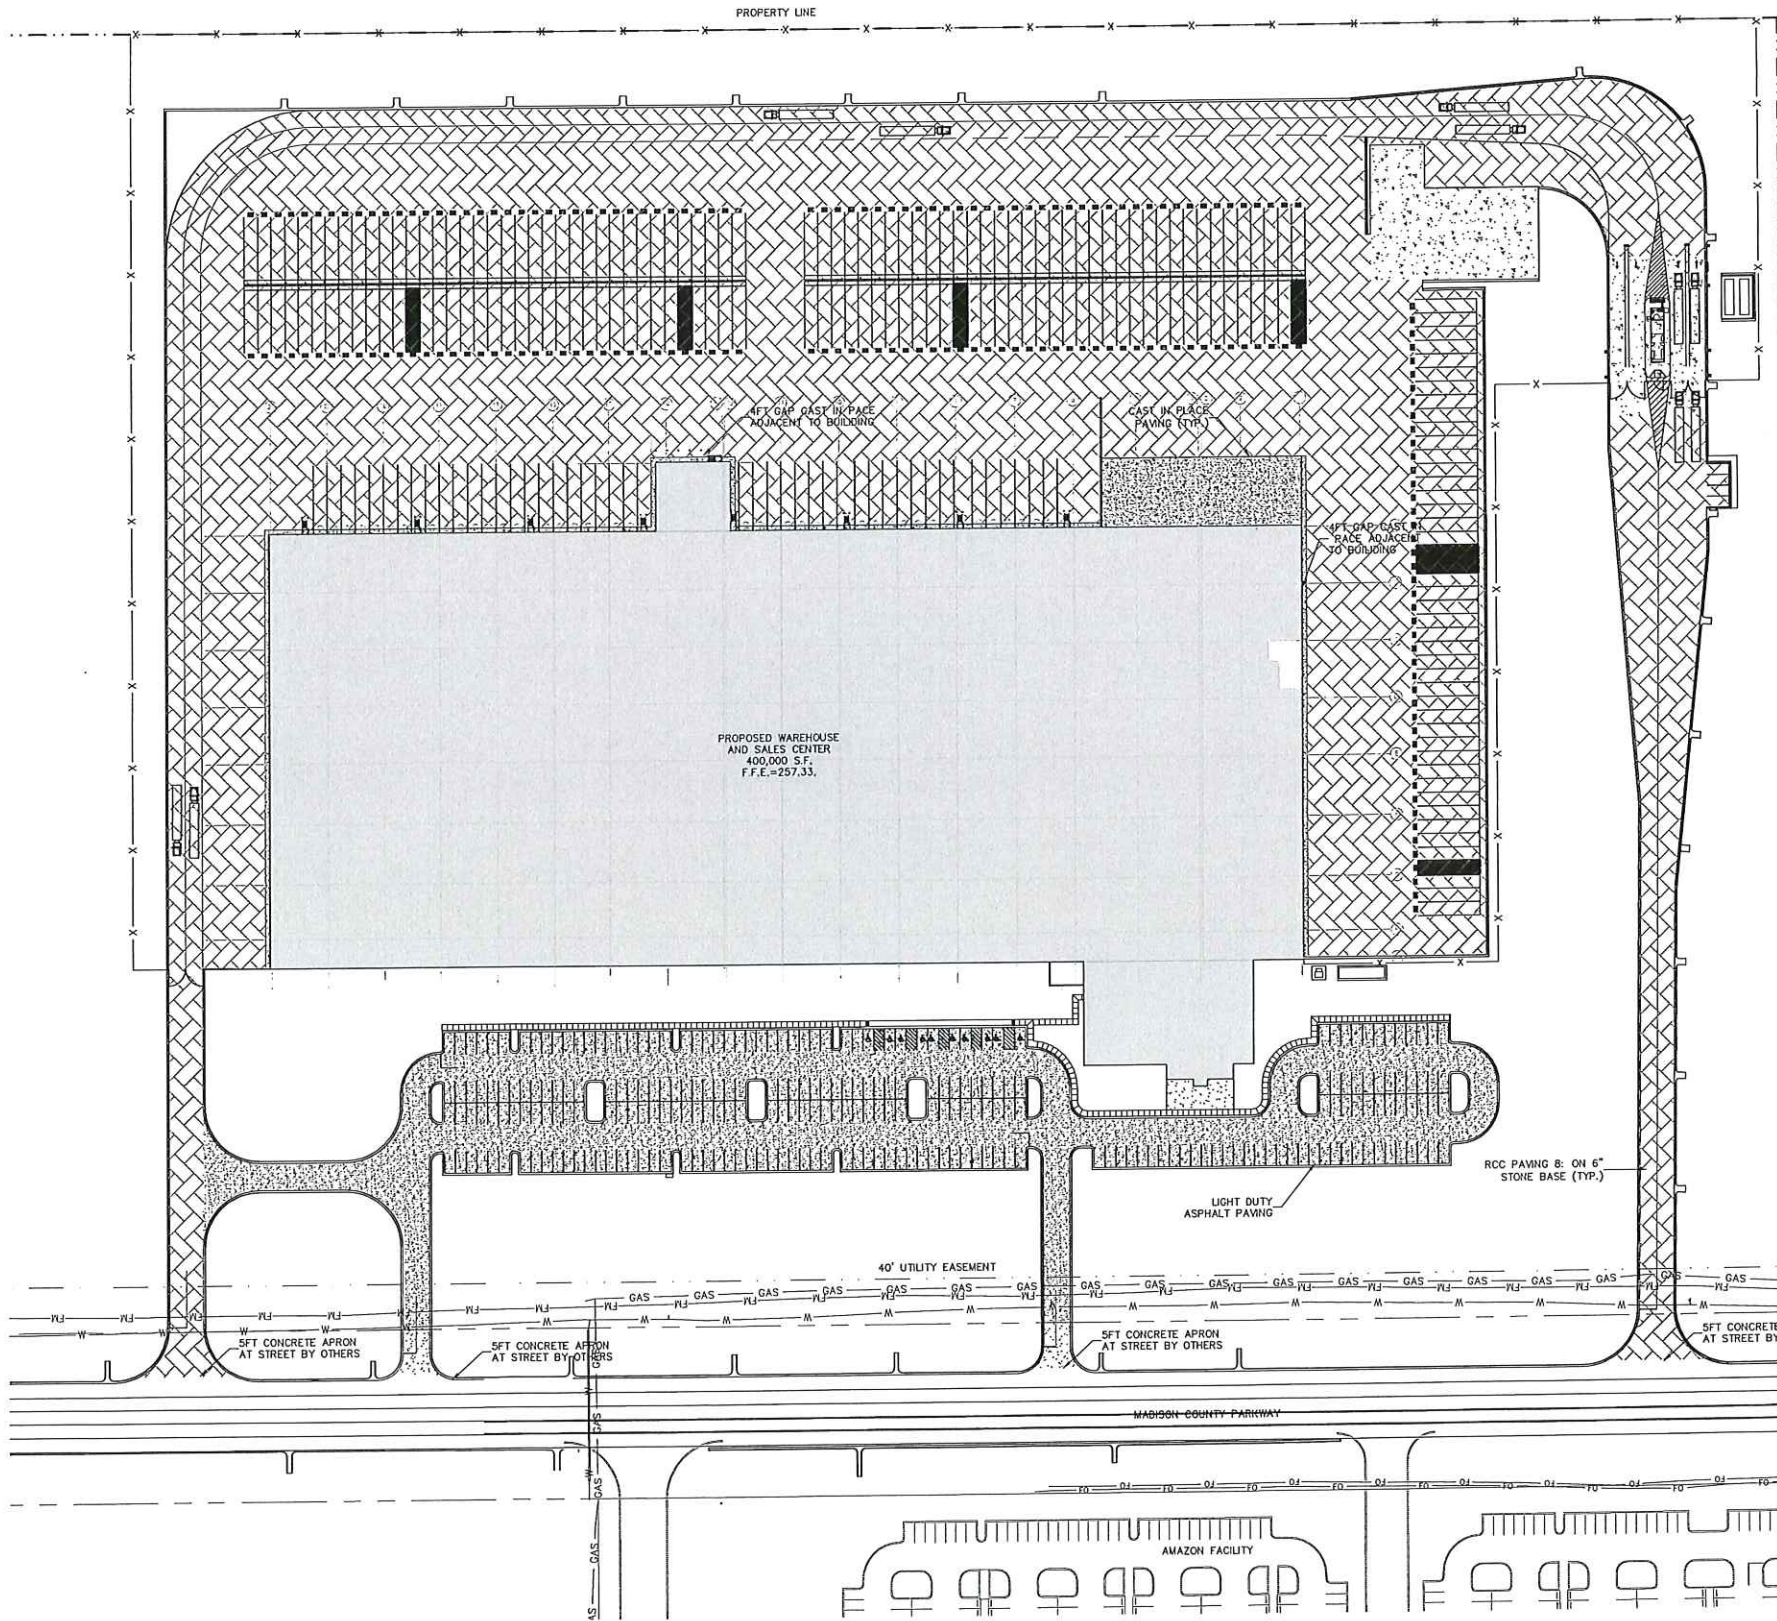

- LEGEND**
- RCC PAVING 8" ON 6" STONE
 - CAST IN PLACE PAVING
 - LIGHT DUTY ASPHALT PAVING

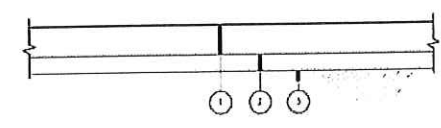


- 8" OF ROLLER-COMPACTED CONCRETE PAVING.
 - 6 INCH 610 CRUSHED AGGREGATE BASE COURSE
 - COMPACTED SUB-GRADE TOP 12 INCHES - 98% COMPACTION ASTM DE98. LIME-SOIL-MIXING 12" 6% HYDRATED LIME
- SEE TECHNICAL SPECIFICATION SECTION 321314 RCC PAVING
- ROLLER-COMPACTED CONCRETE PAVING**
N.T.S.

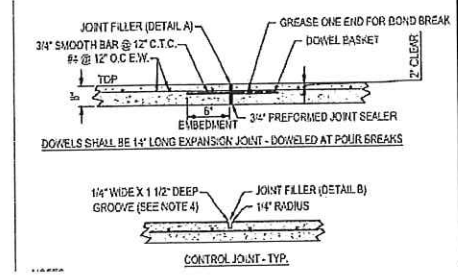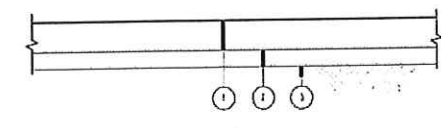

- 8" PCC PAVEMENT 4000 PSI MIX
- 6 INCH 610 CRUSHED Limestone SUB-BASE COURSE
- COMPACTED SUB-GRADE TOP 12 INCHES - 98% COMPACTION ASTM DE98. LIME-SOIL-MIXING 12" 6% HYDRATED LIME
- CONCRETE SHALL HAVE 4000 PSI AT 28 DAYS
- CONTRACTOR SHALL INSTALL CONTROL JOINTS IN CONCRETE PAVING AT 15' MAX SPACING BOTH WAYS. COORDINATE WITH ARCHITECTURAL PLANS FOR SCORING PATTERN.
- CONTROL JOINT TO BE 1 1/2" DEEP
- EXPANSION JOINTS AT POUR BREAKS AND 100' MAX SPACING. COORDINATE WITH CONTROL JOINTS WHERE CONCRETE PAVING ABUTS BUILDING STRUCTURES, COLUMNS, FOOTINGS, POLE BASES, INLETS AND OTHER SIMILAR IMMOVABLE OBJECTS. CONTRACTOR SHALL PROVIDE EXPANSION JOINT WITH FILLER MATERIAL CONTRACTOR SHALL ALSO PROVIDE CONTROL JOINTS TO MINIMIZE POTENTIAL FOR CRACKLING. COORDINATE WITH ENGINEER FOR LOCATIONS.

HEAVY DUTY CONCRETE
N.T.S.

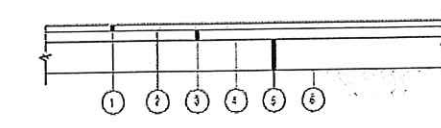

- 2 INCH ASPHALT SURFACE COURSE SC-1 TYPE 8
- REQUIRED TACK COAT
- 4 INCH ASPHALT BASE COURSE BB-1, TYPE 6
- REQUIRED BITUMINOUS TREATMENT (PRIME)
- COMPACTED SUB-GRADE TOP 12 INCHES - 98% COMPACTION ASTM DE98. LIME-SOIL-MIXING 12" 6% HYDRATED LIME
- SUB-GRADE


NOTE: ALL MIX DESIGNS ARE PER THE MDOT STANDARD SPECIFICATIONS FOR HIGHWAY CONSTRUCTION - LATEST EDITION.

STANDARD DUTY ASPHALT PAVING
N.T.S.



Design Group
DG ARCHITECTURAL AND ENGINEERING FACILITY SOLUTIONS, PLLC
305 WOODWARD ROAD, SUITE 100, DUBLIN, OHIO 43017
PHONE: (614) 845-1400 FAX: (614) 845-1401

REVISION	BY	DATE	ISSUED FOR BID - EARTHWORK
1	WLC	5/17/23	

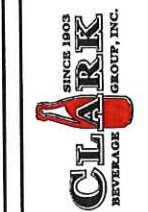


CLARK BEVERAGE GROUP, INC.
OAKLAND, KY
PROJECT JOY SALES CENTER
CANTON, MS
DRAWING TITLE PAVING SITE LAYOUT



PROJECT NO. 2300638
ISSUED: 5-17-2023
SCALE: AS NOTED
DRAWN BY: WLC
DRAWING NO.

C6.0

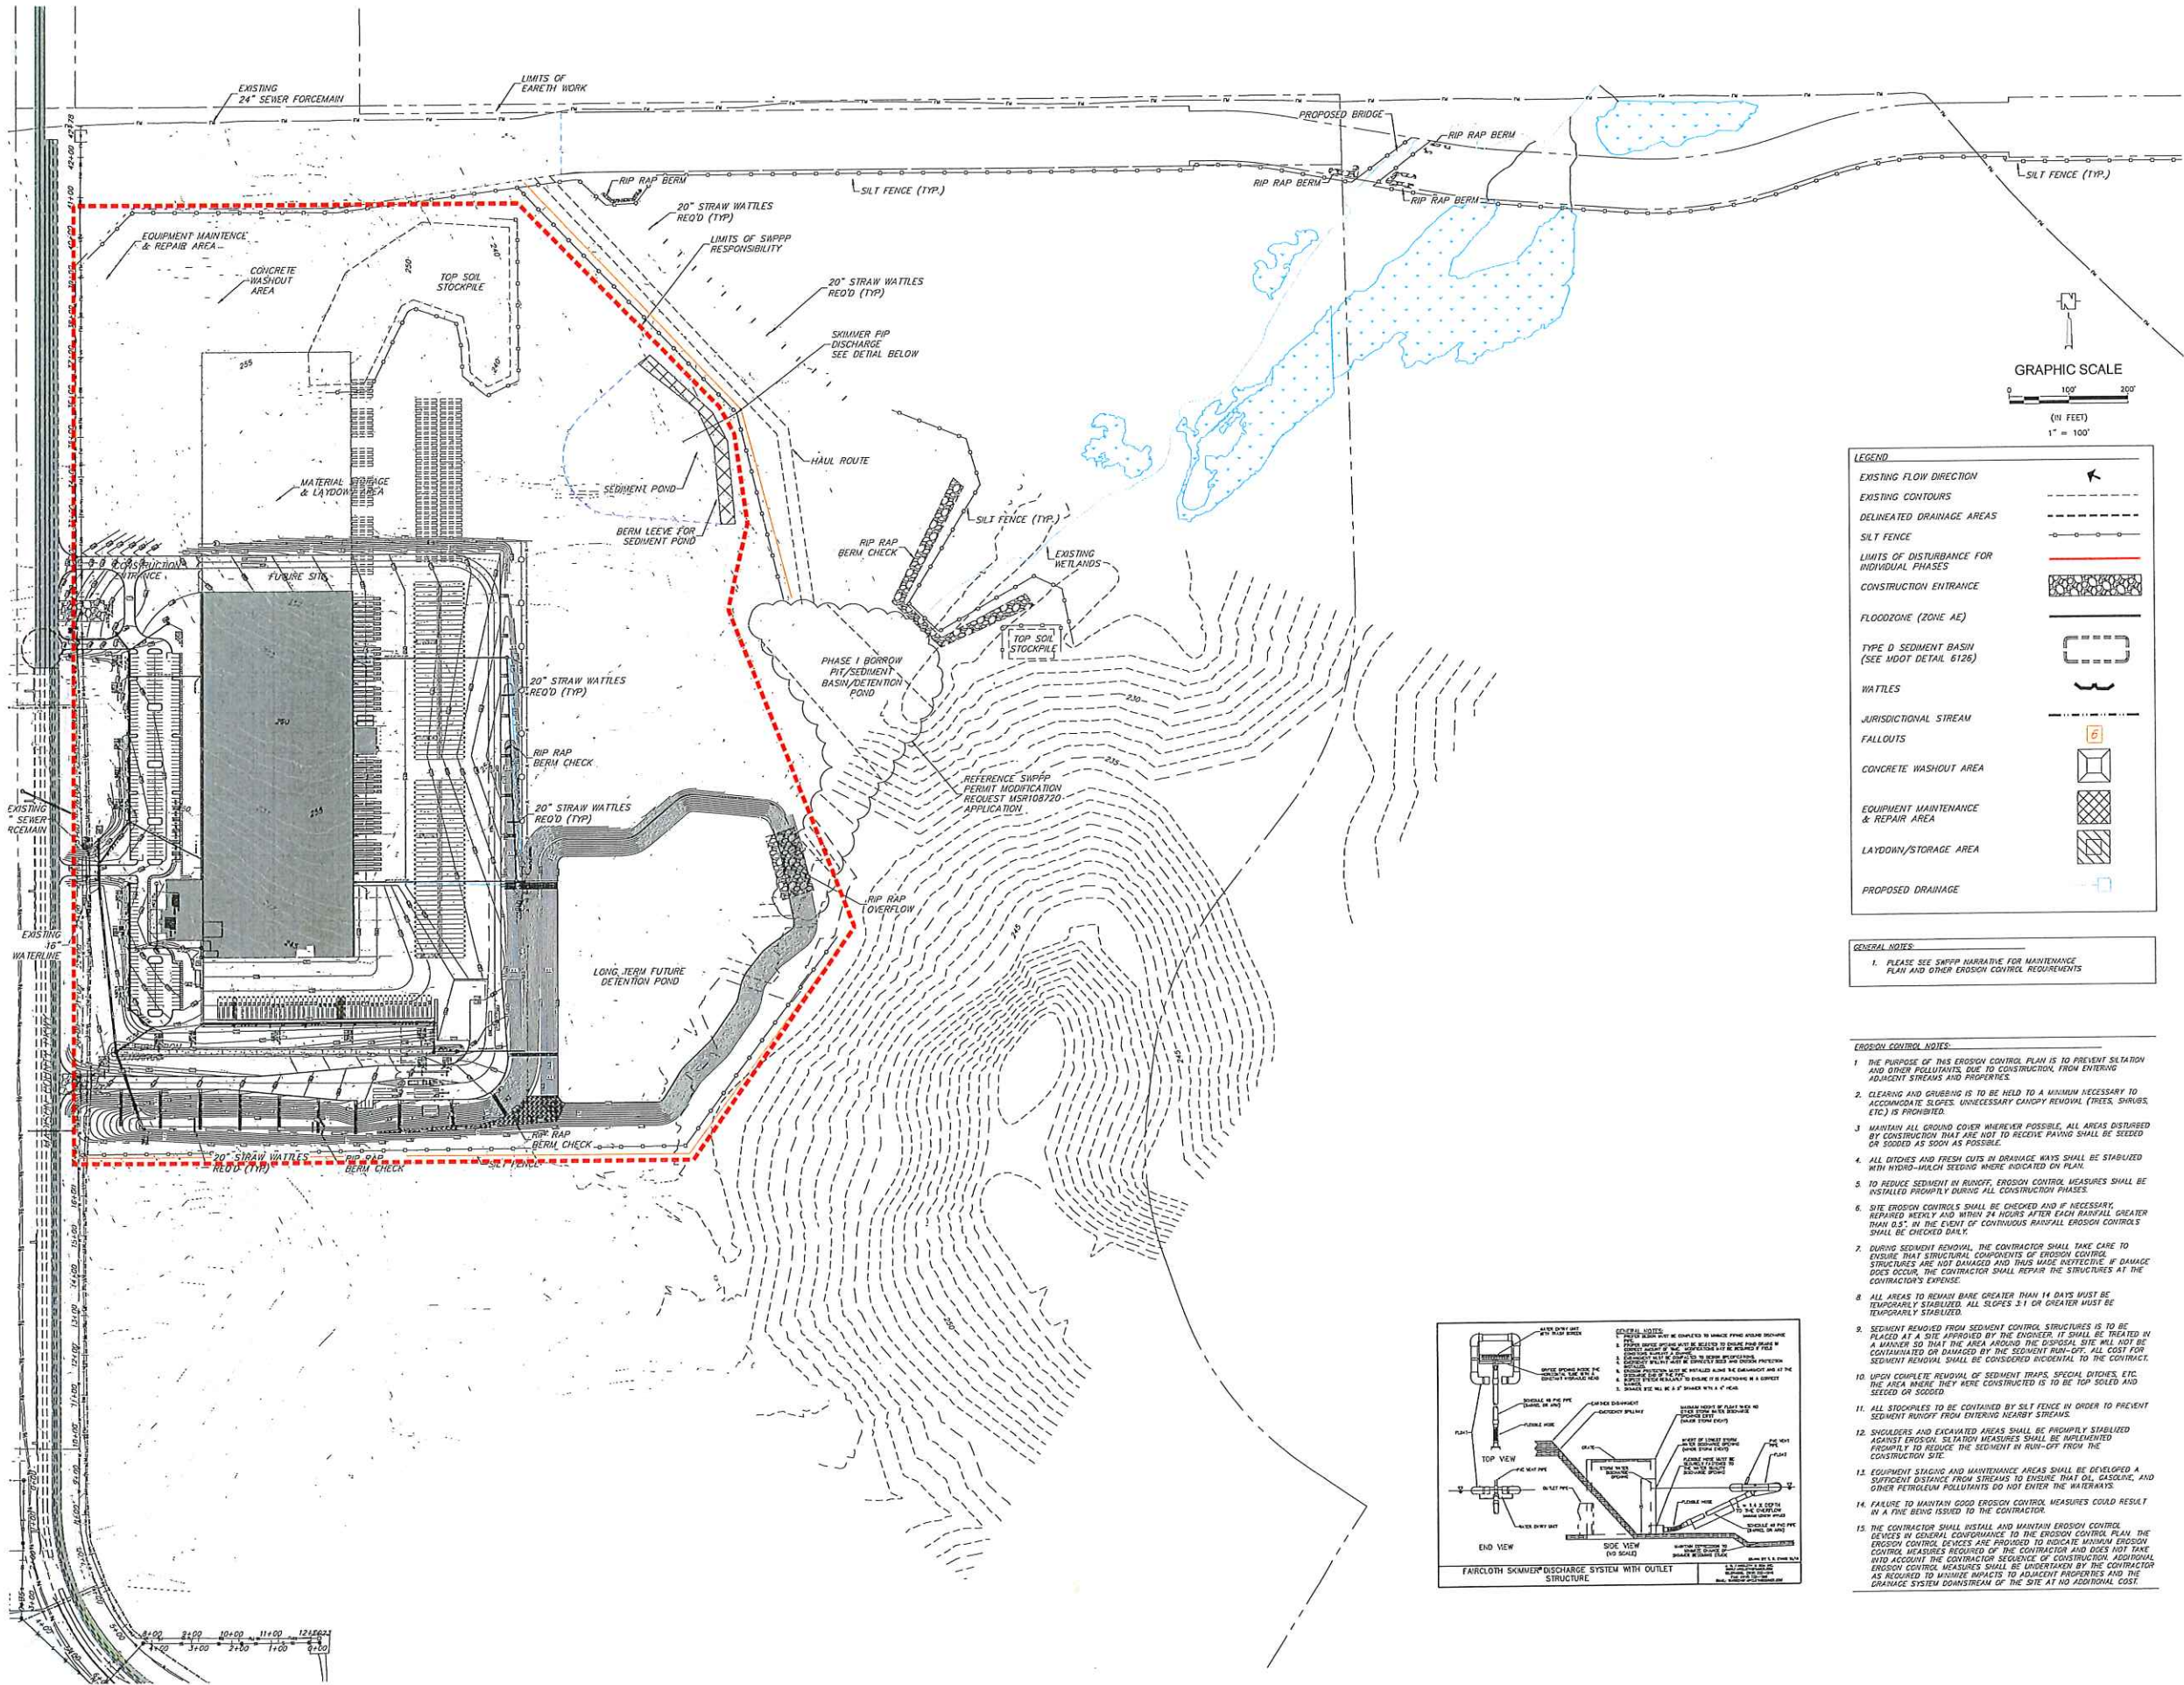

DATE PLOTTED: 3/11/2023 11:24:03 AM



Design Group
DO ARCHITECTURAL AND ENGINEERING FACILITY SOLUTIONS, PLLC
1025 WILKINSON AVENUE, SUITE 101, ALPHARETTA, GA 30205
PHONE: (770) 867-5200 FAX: (770) 867-9421

Table with 4 columns: DATE, BY, VAC, REVISION. Contains project revision history.



Table with 2 columns: CLIENT, PROJECT. Contains client and project information.



Table with 2 columns: PROJECT NO, ISSUED, SCALE, DRAWN BY, DRAWING NO. Contains project metadata.

C7.0





